

Civil/Structural Engineer

Engineering Ventures, PC
85 Mechanic Street, Suite E2-3
Lebanon, NH 03766
P (603) 442-9333
F (603) 442-9331

Mechanical Engineer

VHV Company
16 Teegan Street
Winooski, VT 05404
P (802) 655-8805
F (802) 655-8809

Electrical Engineer

Interstate Electrical Services
15 Cote Lane
Bedford, NH 03110
P (603) 627-3230

Fire Protection Engineer

John L. Carter Sprinkler
Company, Inc.
9 Dunklee Road
Bow, NH 03304
P (603) 224-5438
F (603) 224-6481

© 2018, Bread Loaf Corporation
Seal:

Revised


No.	Date	Description
A	1/31/19	DESIGN DEVELOPMENT

NEWPORT
COMMUNITY CENTER


NEWPORT, NH

Proj. No: 5205 Drawn: COH
Date: 1/31/2019 Chk'd: NHC
FIRST FLOOR HVAC
NORTH

H1.0

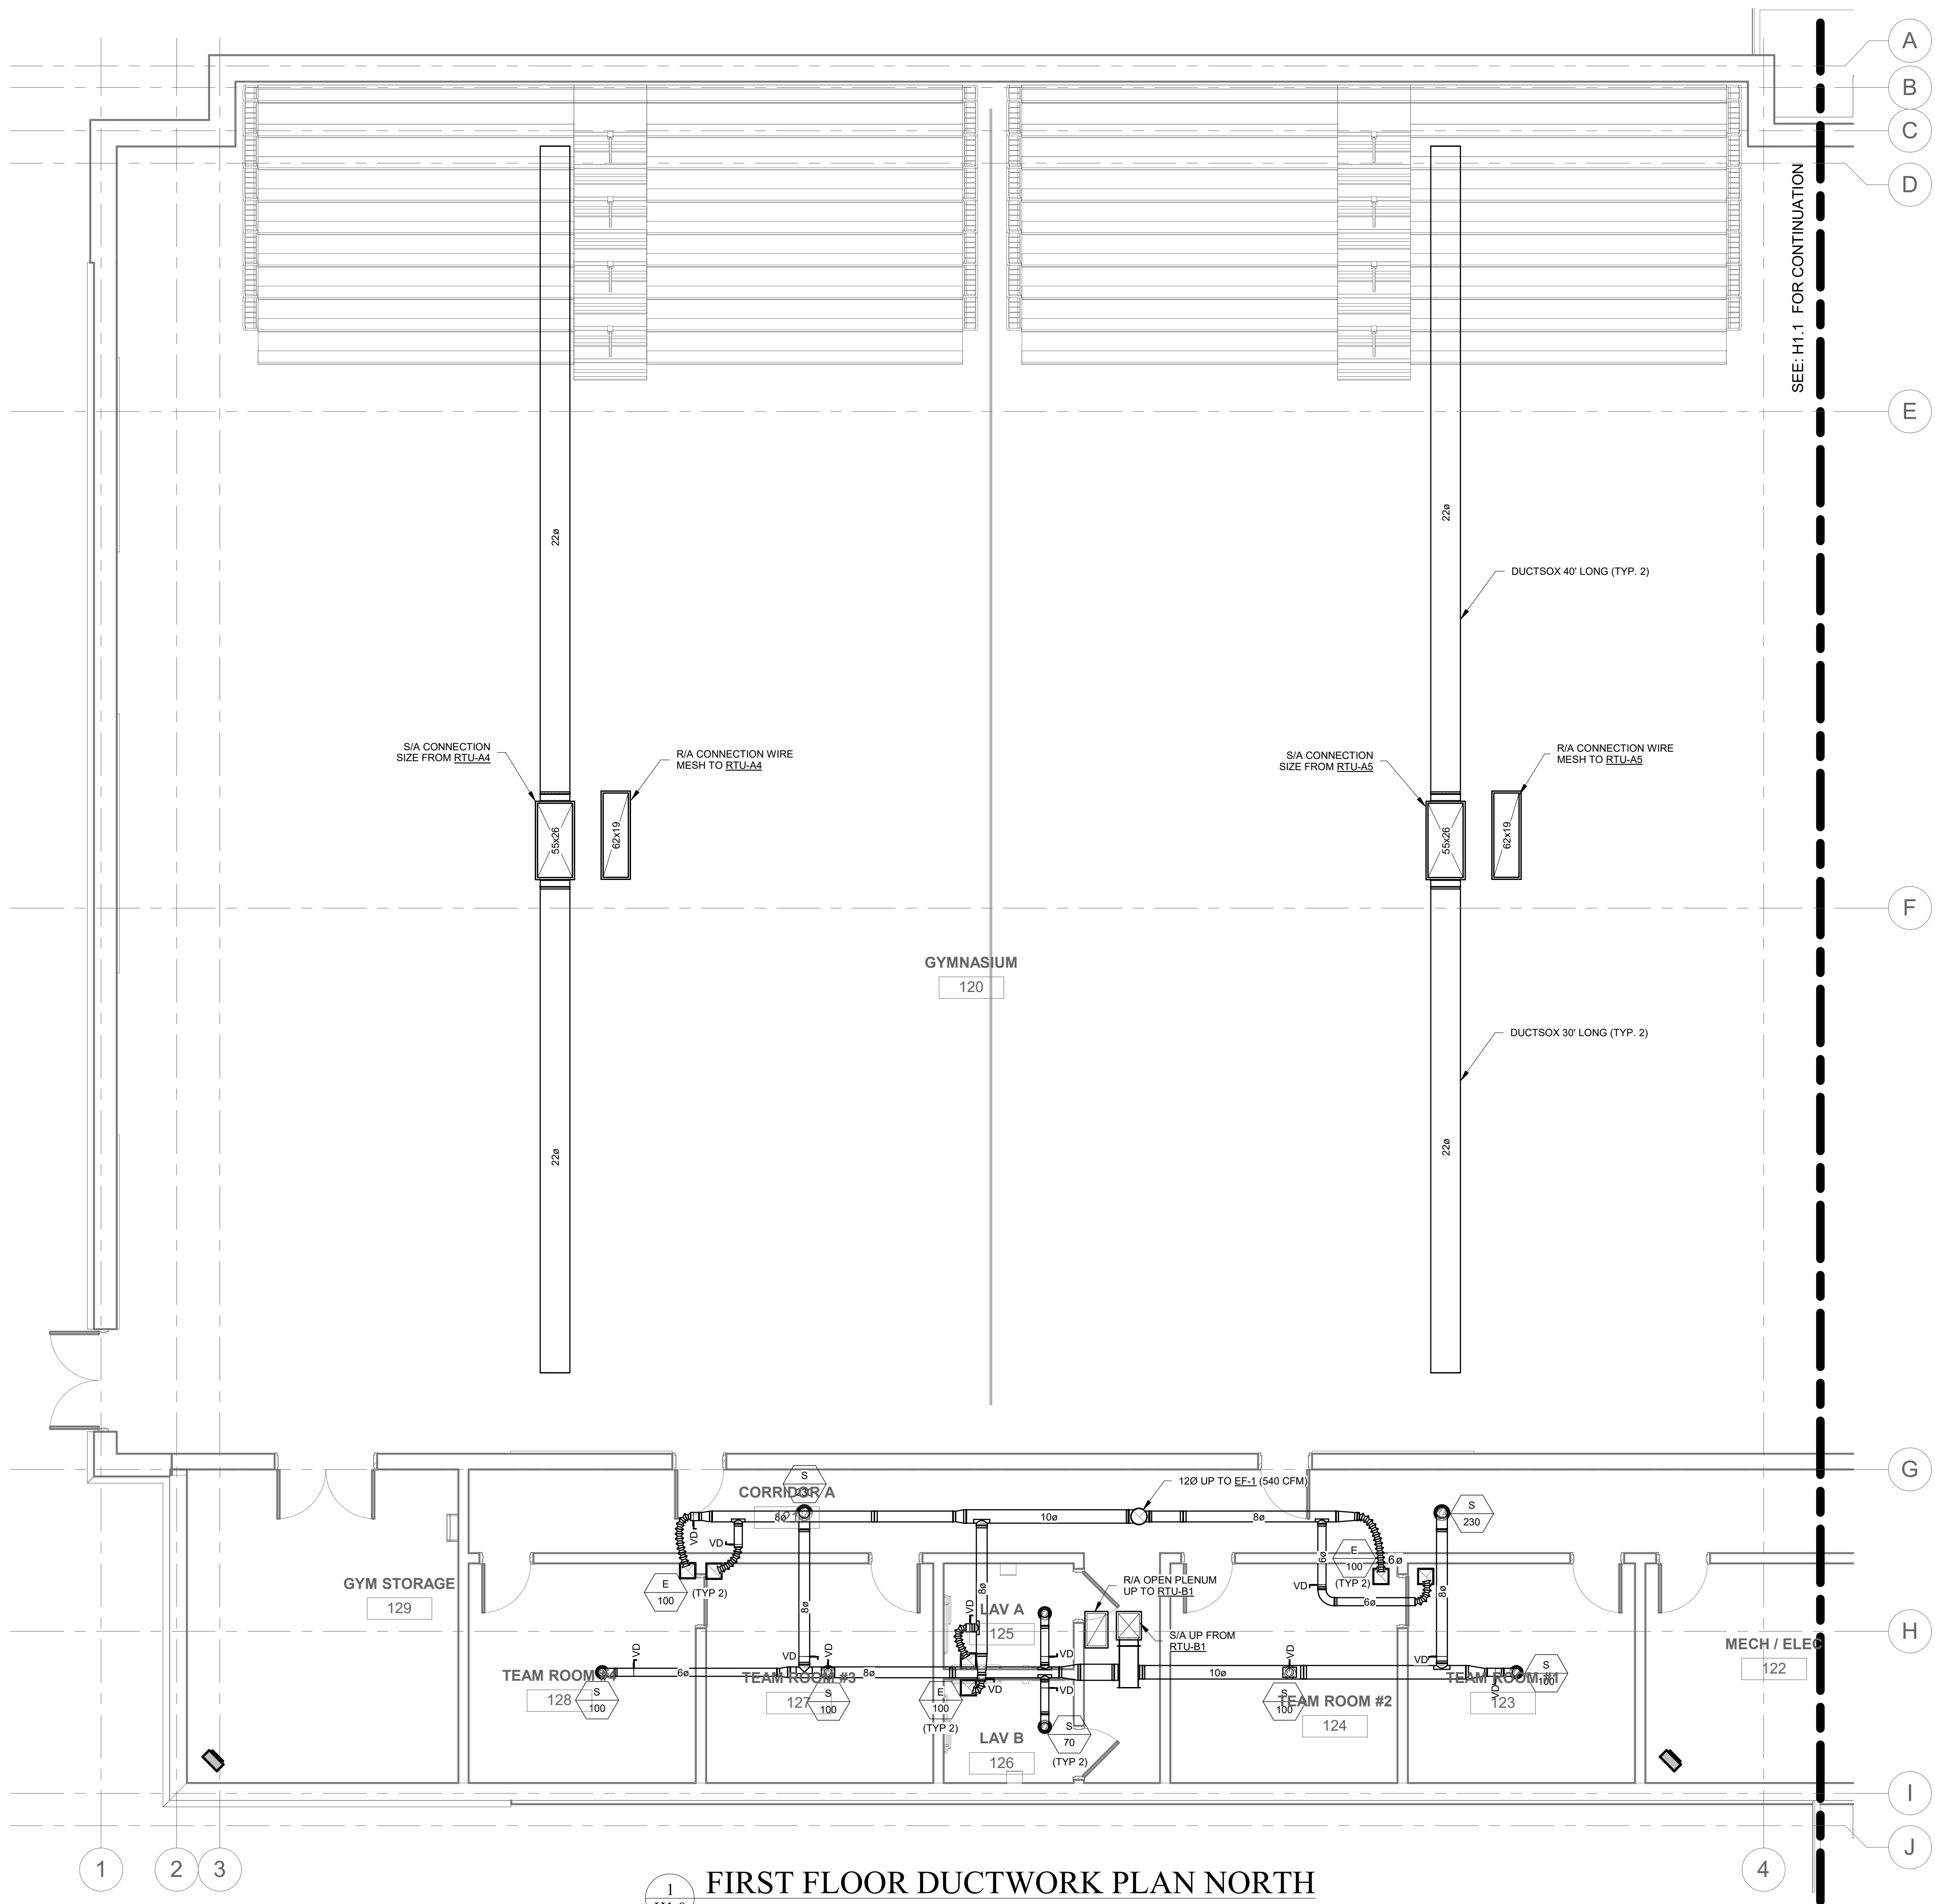

1
H1.0
FIRST FLOOR DUCTWORK PLAN NORTH
SCALE: 3/16" = 1'-0"

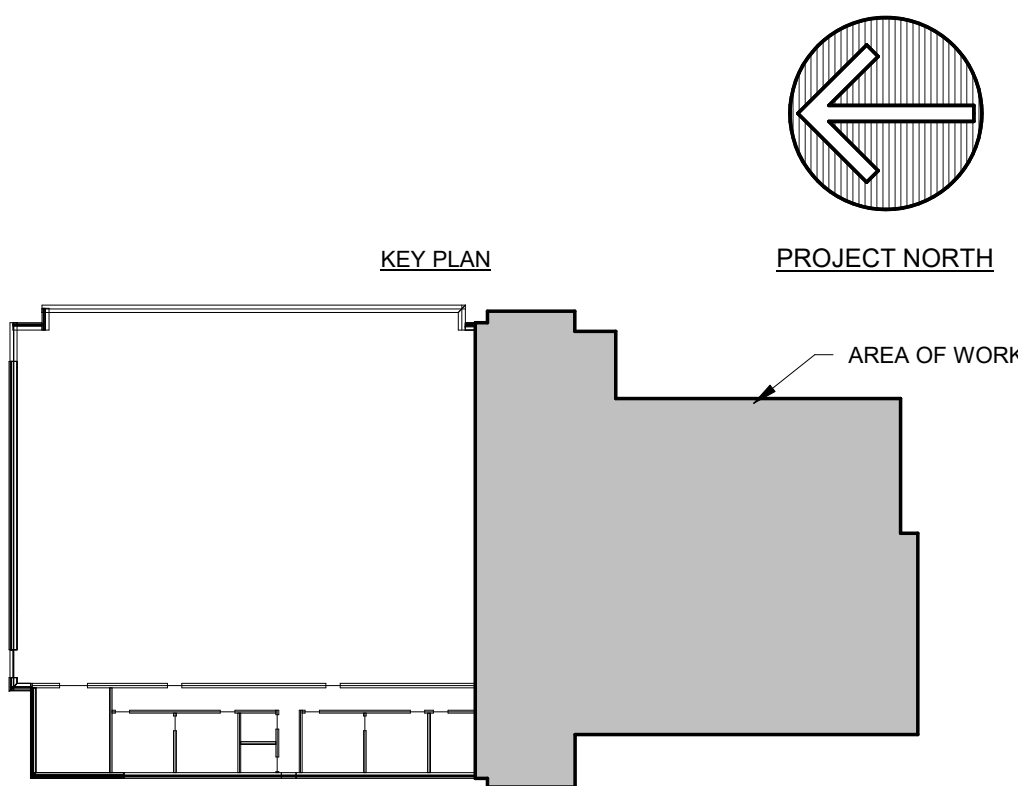

DESIGN DEVELOPMENT

Civil/Structural Engineer

Engineering Ventures, PC
85 Mechanic Street, Suite E2-3
Lebanon, NH 03766
P (603) 442-9333
F (603) 442-9331

Mechanical Engineer

VHV Company
16 Teegan Street
Winooski, VT 05404
P (802) 655-8805
F (802) 655-8809

Electrical Engineer

Interstate Electrical Services
15 Cote Lane
Bedford, NH 03110
P (603) 627-3230

Fire Protection Engineer

John L. Carter Sprinkler
Company, Inc.
9 Dunklee Road
Bow, NH 03304
P (603) 224-5438
F (603) 224-6481



© 2018, Bread Loaf Corporation
Seal:

Revised		
No.	Date	Description
A	1/31/19	DESIGN DEVELOPMENT


NEWPORT
COMMUNITY CENTER
NEWPORT, NH

Proj. No: 5205 Drawn: COH
Date: 1/31/2019 Chk'd: NHC
FIRST FLOOR HVAC
SOUTH

H1.1

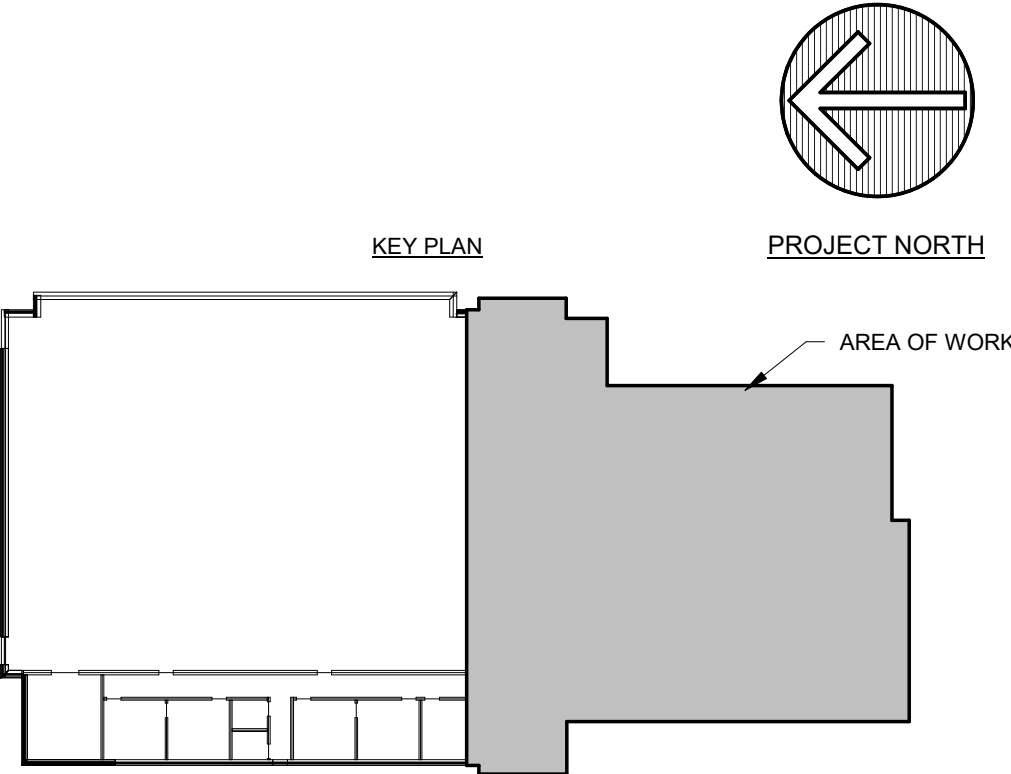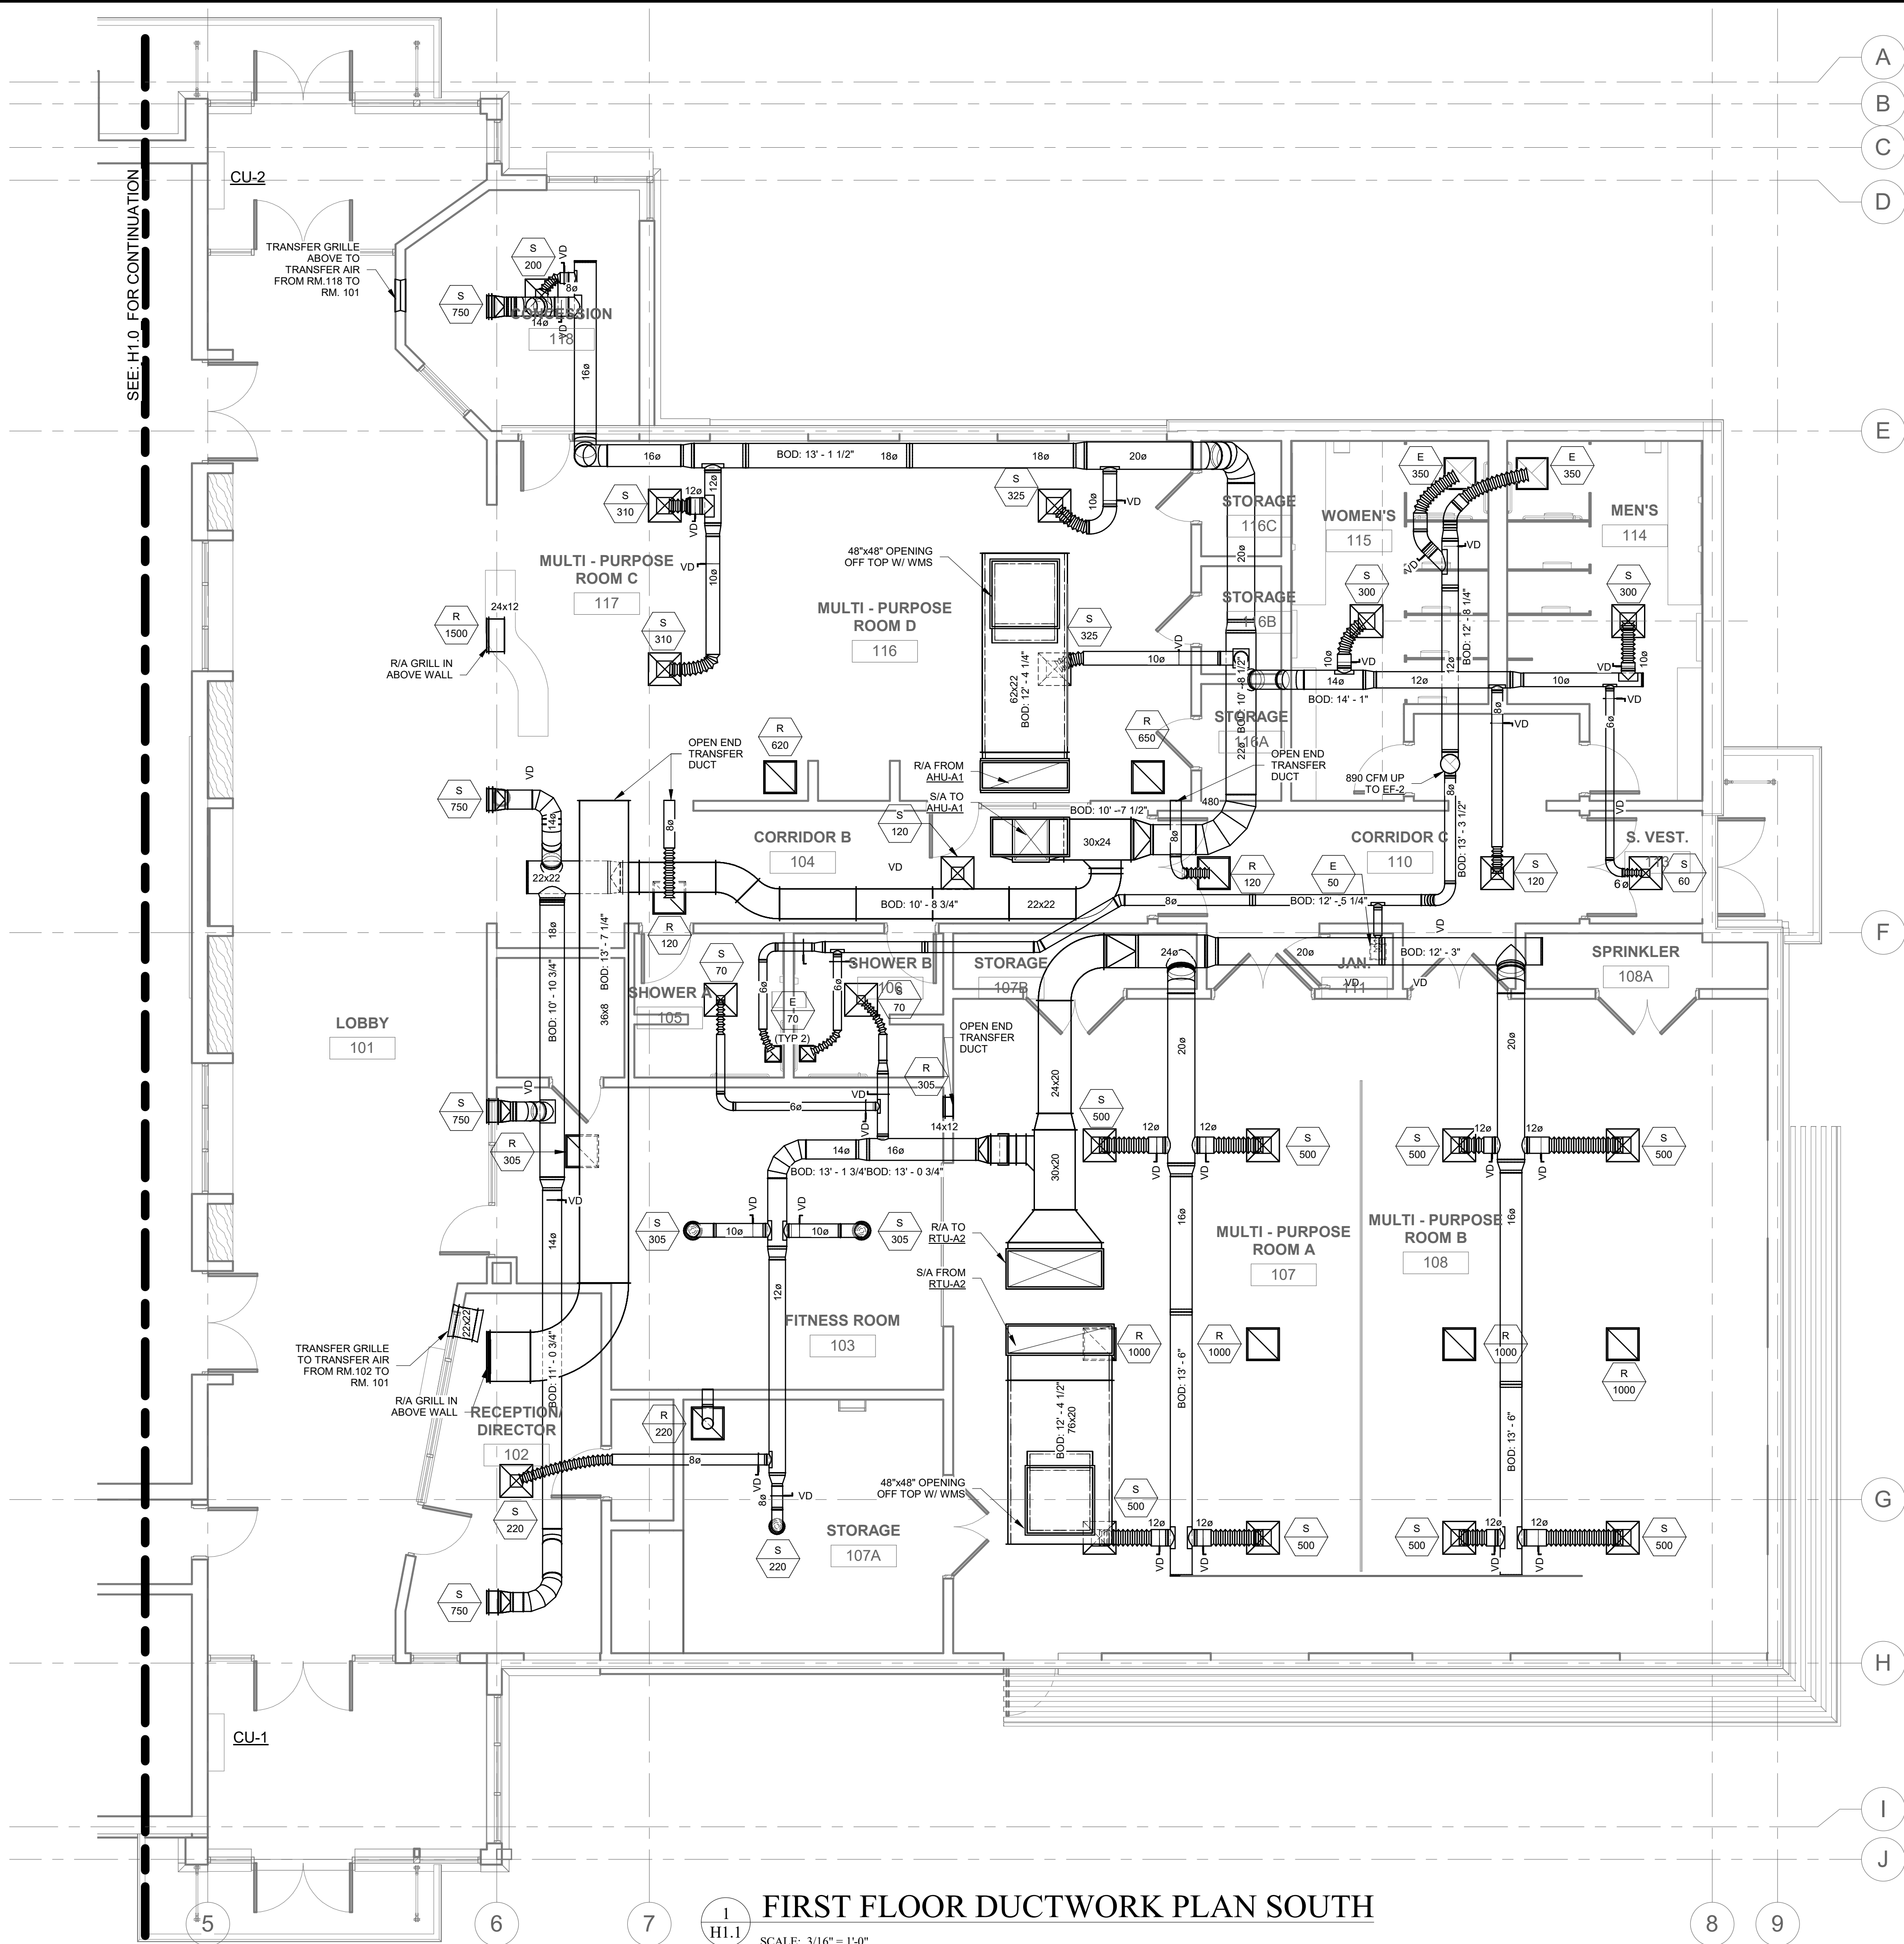


DESIGN DEVELOPMENT

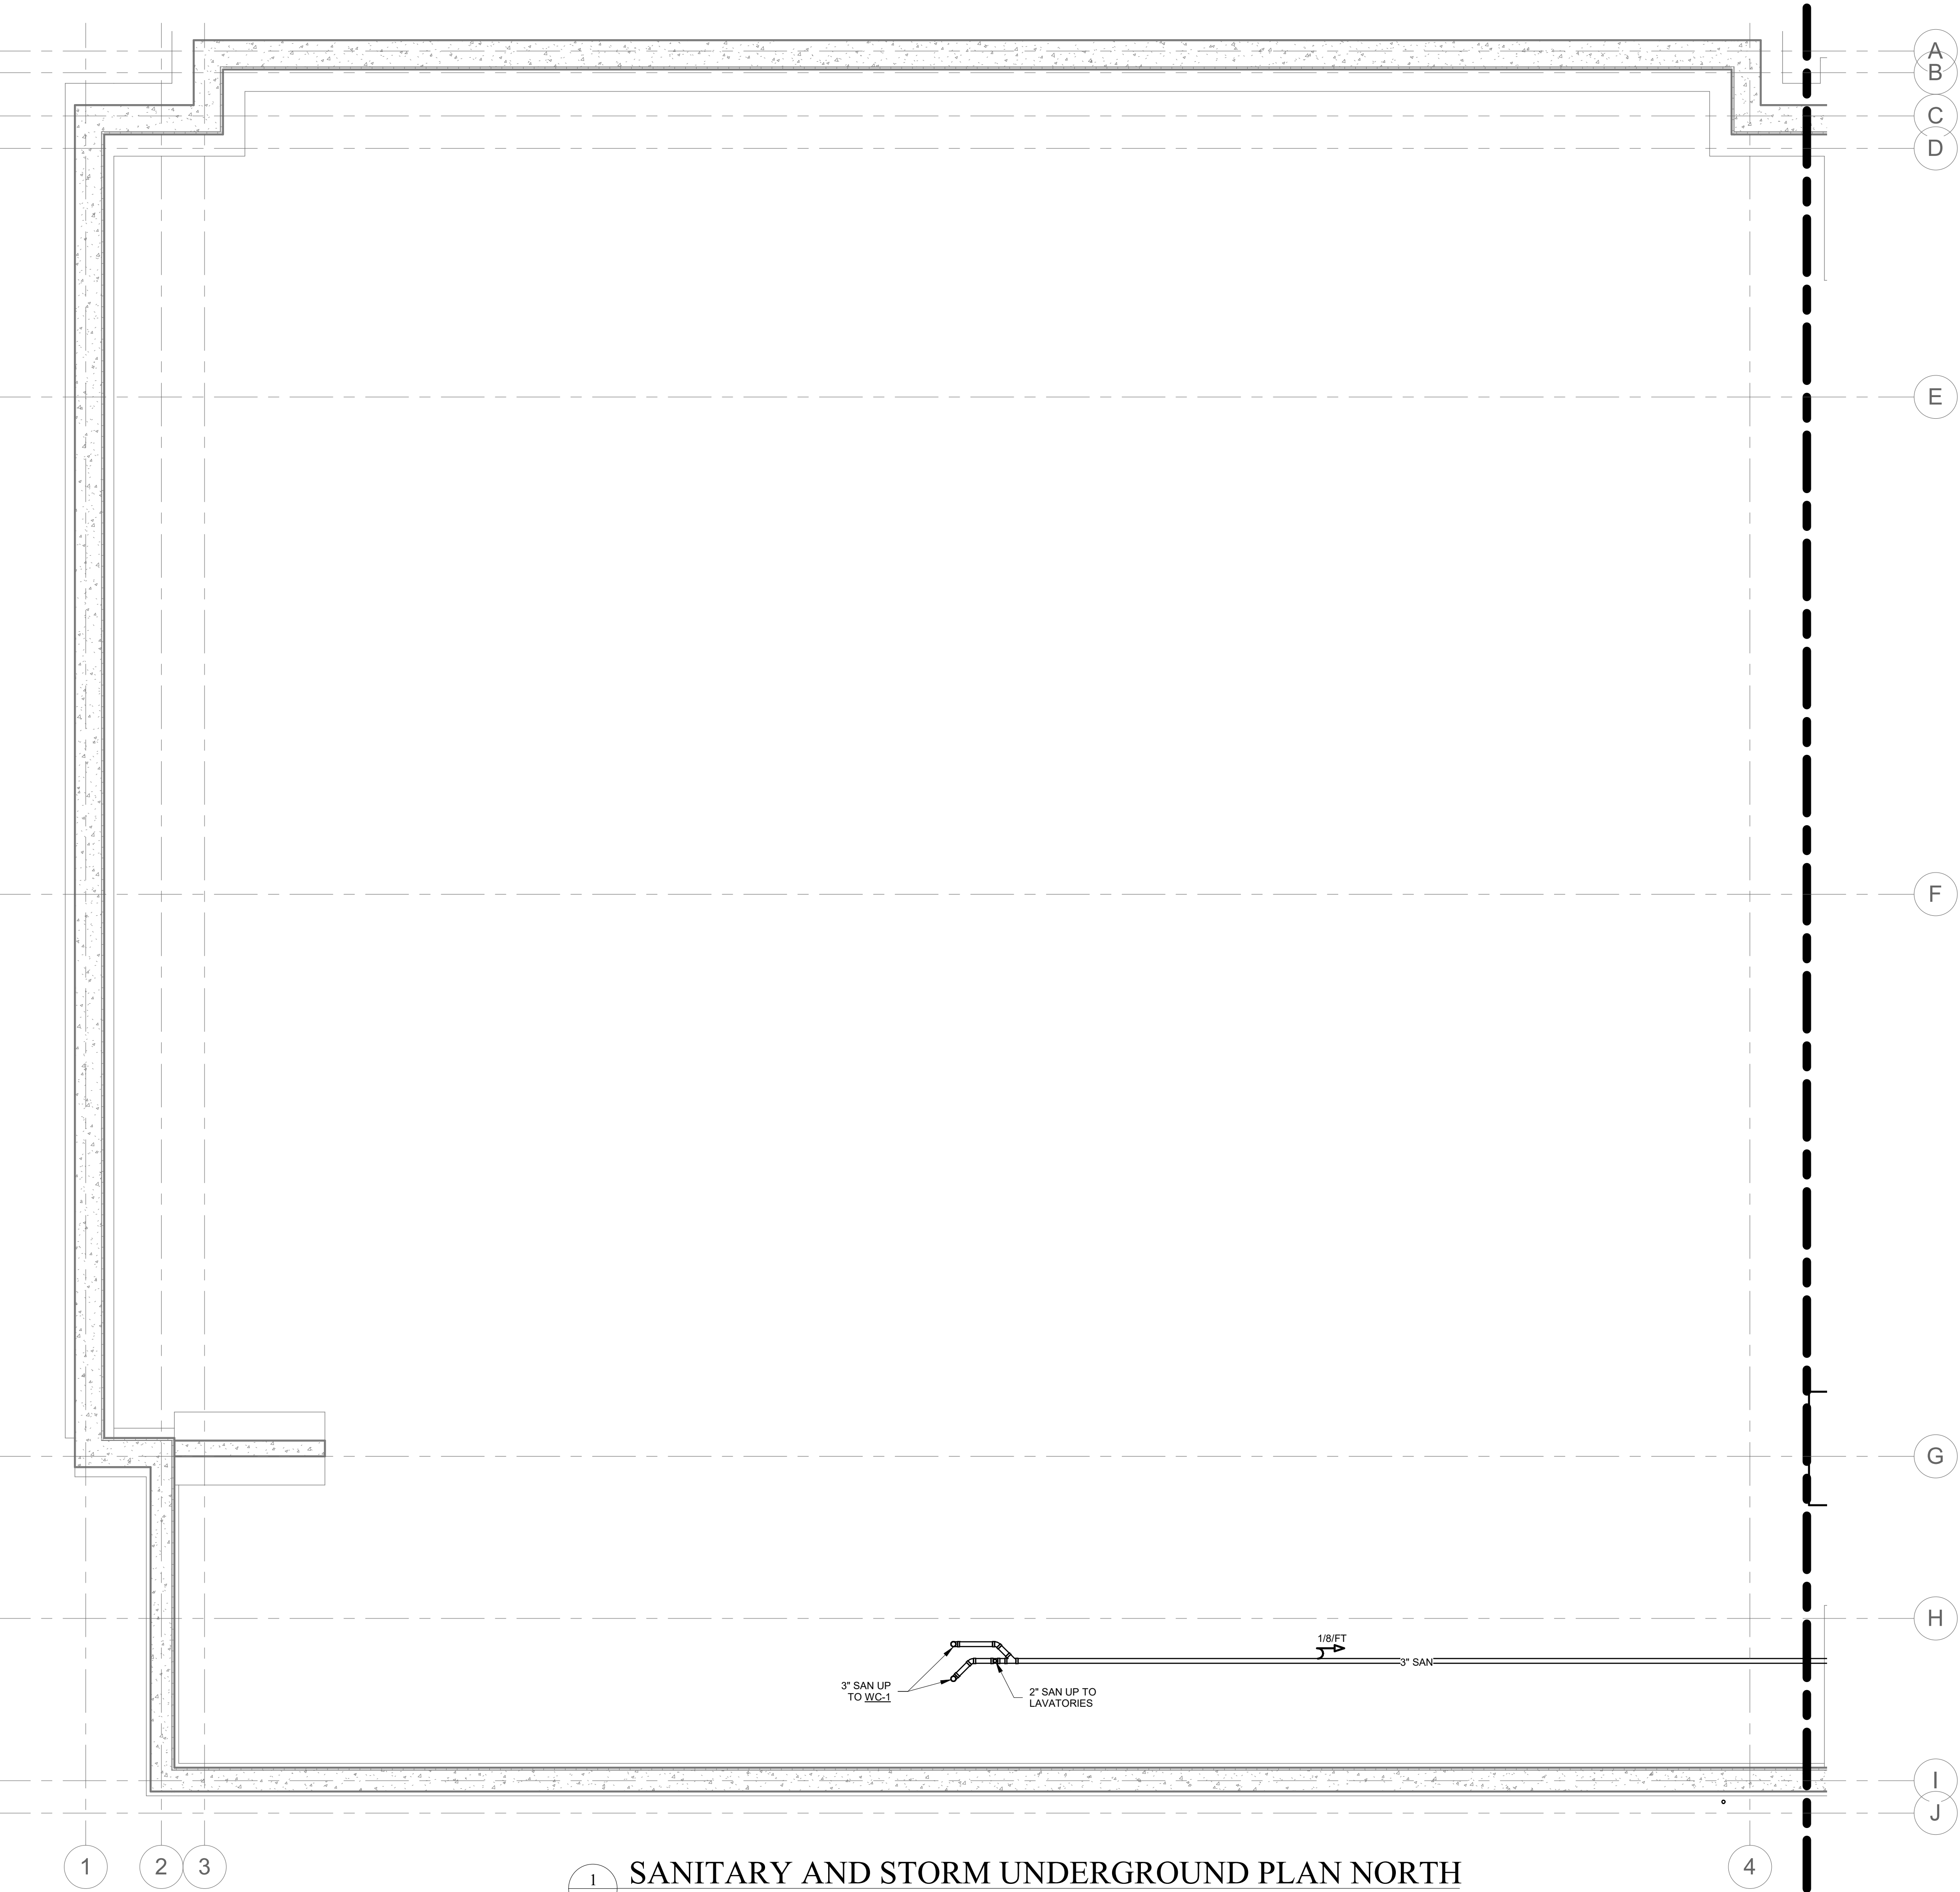

1
P1.0

SANITARY AND STORM UNDERGROUND PLAN NORTH

SCALE: 3/16" = 1'-0"

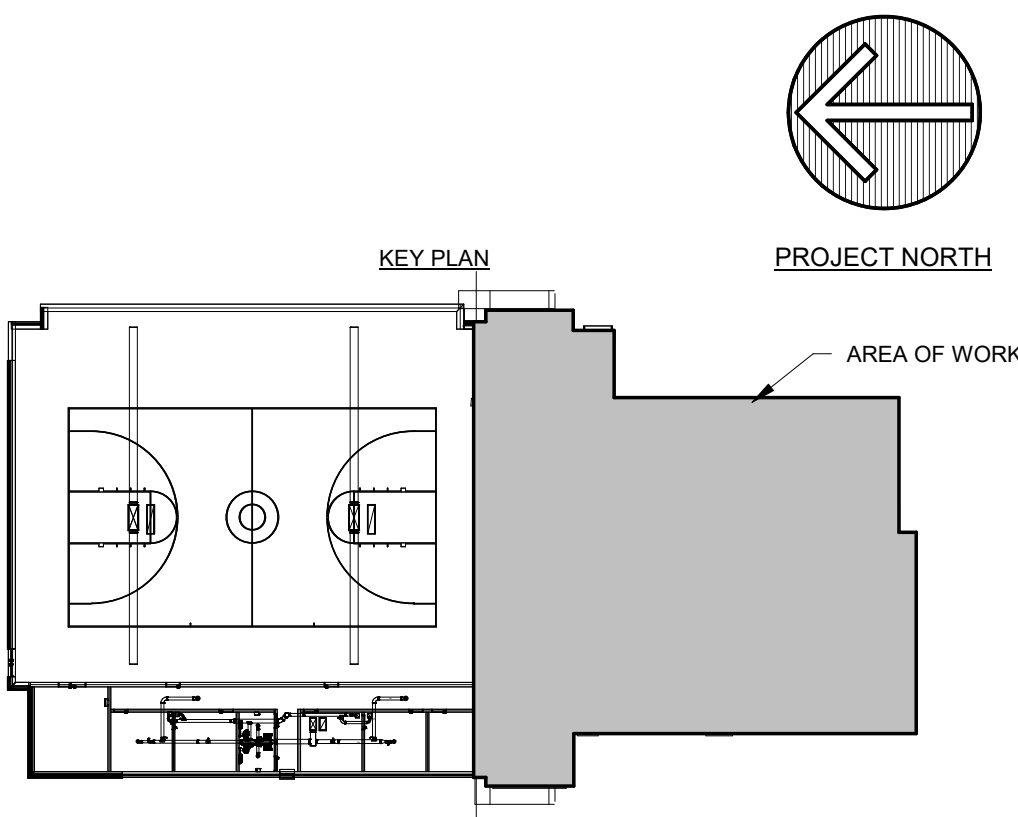

DESIGN DEVELOPMENT

BreadLoaf

Architects
Planners
Builders

1293 Route 7 South
Middlebury, VT 05753
P (802) 388-9871
F (802) 388-3815
www.breadloaf.com

Civil/Structural Engineer

Engineering Ventures, PC
85 Mechanic Street, Suite E2-3
Lebanon, NH 03766
P (603) 442-9333
F (603) 442-9331

Mechanical Engineer

VHV Company
16 Teegan Street
Winooski, VT 05404
P (802) 655-8805
F (802) 655-8809

Electrical Engineer

Interstate Electrical Services
15 Cote Lane
Bedford, NH 03110
P (603) 627-3230

Fire Protection Engineer

John L. Carter Sprinkler
Company, Inc.
9 Dunklee Road
Bow, NH 03304
P (603) 224-5438
F (603) 224-6481

© 2018, Bread Loaf Corporation
Seal:

Revised		
No.	Date	Description
A	1/31/19	DESIGN DEVELOPMENT

NEWPORT
COMMUNITY CENTER

NEWPORT, NH

Proj. No: 5205 Drawn: COH
Date: 1/31/2019 Chk'd: NHC

UNDERGROUND
SANITARY AND
SOTRM PLAN NORTH

P1.0

Civil/Structural Engineer

Engineering Ventures, PC
85 Mechanic Street, Suite E2-3
Lebanon, NH 03766
P (603) 442-9333
F (603) 442-9331

Mechanical Engineer

VHV Company
16 Teegan Street
Winooski, VT 05404
P (802) 655-8805
F (802) 655-8809

Electrical Engineer

Interstate Electrical Services
15 Cote Lane
Bedford, NH 03110
P (603) 627-3230

Fire Protection Engineer

John L. Carter Sprinkler
Company, Inc.
9 Dunklee Road
Bow, NH 03304
P (603) 224-5438
F (603) 224-6481

© 2018, Bread Loaf Corporation
Seal:

Revised

No.	Date	Description
A	1/31/19	DESIGN DEVELOPMENT


NEWPORT
COMMUNITY CENTER

NEWPORT, NH


Proj. No: 5205 Drawn: COH
Date: 1/31/2019 Chk'd: NHC

UNDERGROUND
SANITARY AND
STORM PLAN SOUTH

P1.1

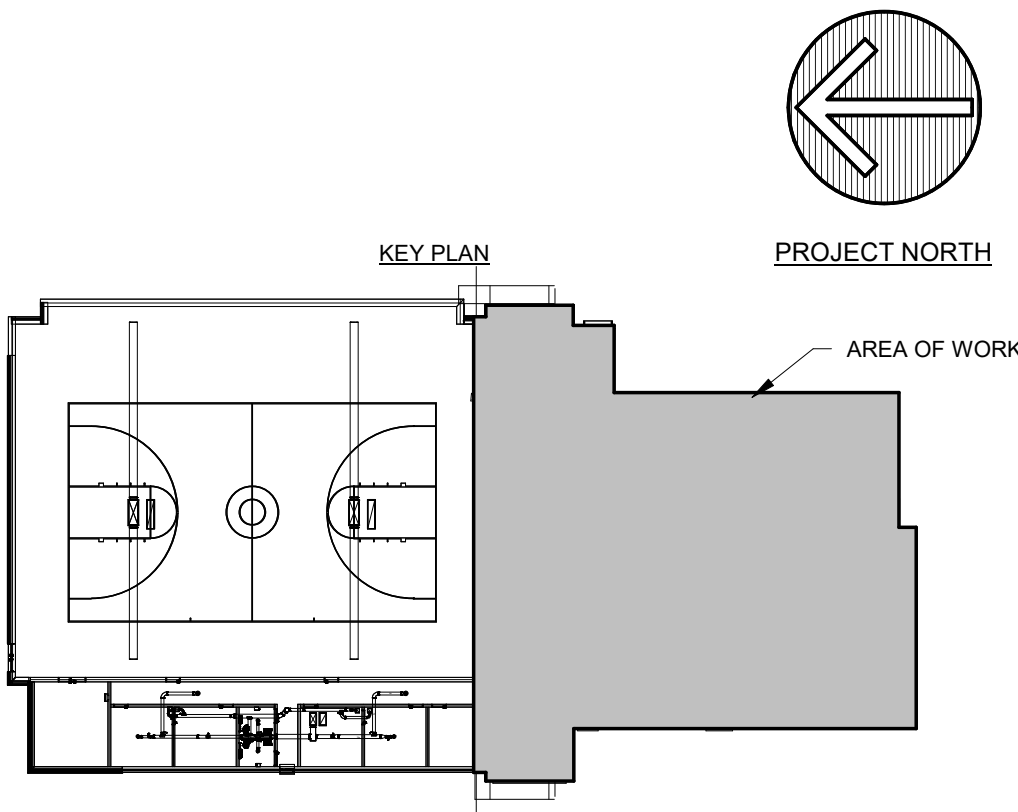

DESIGN DEVELOPMENT

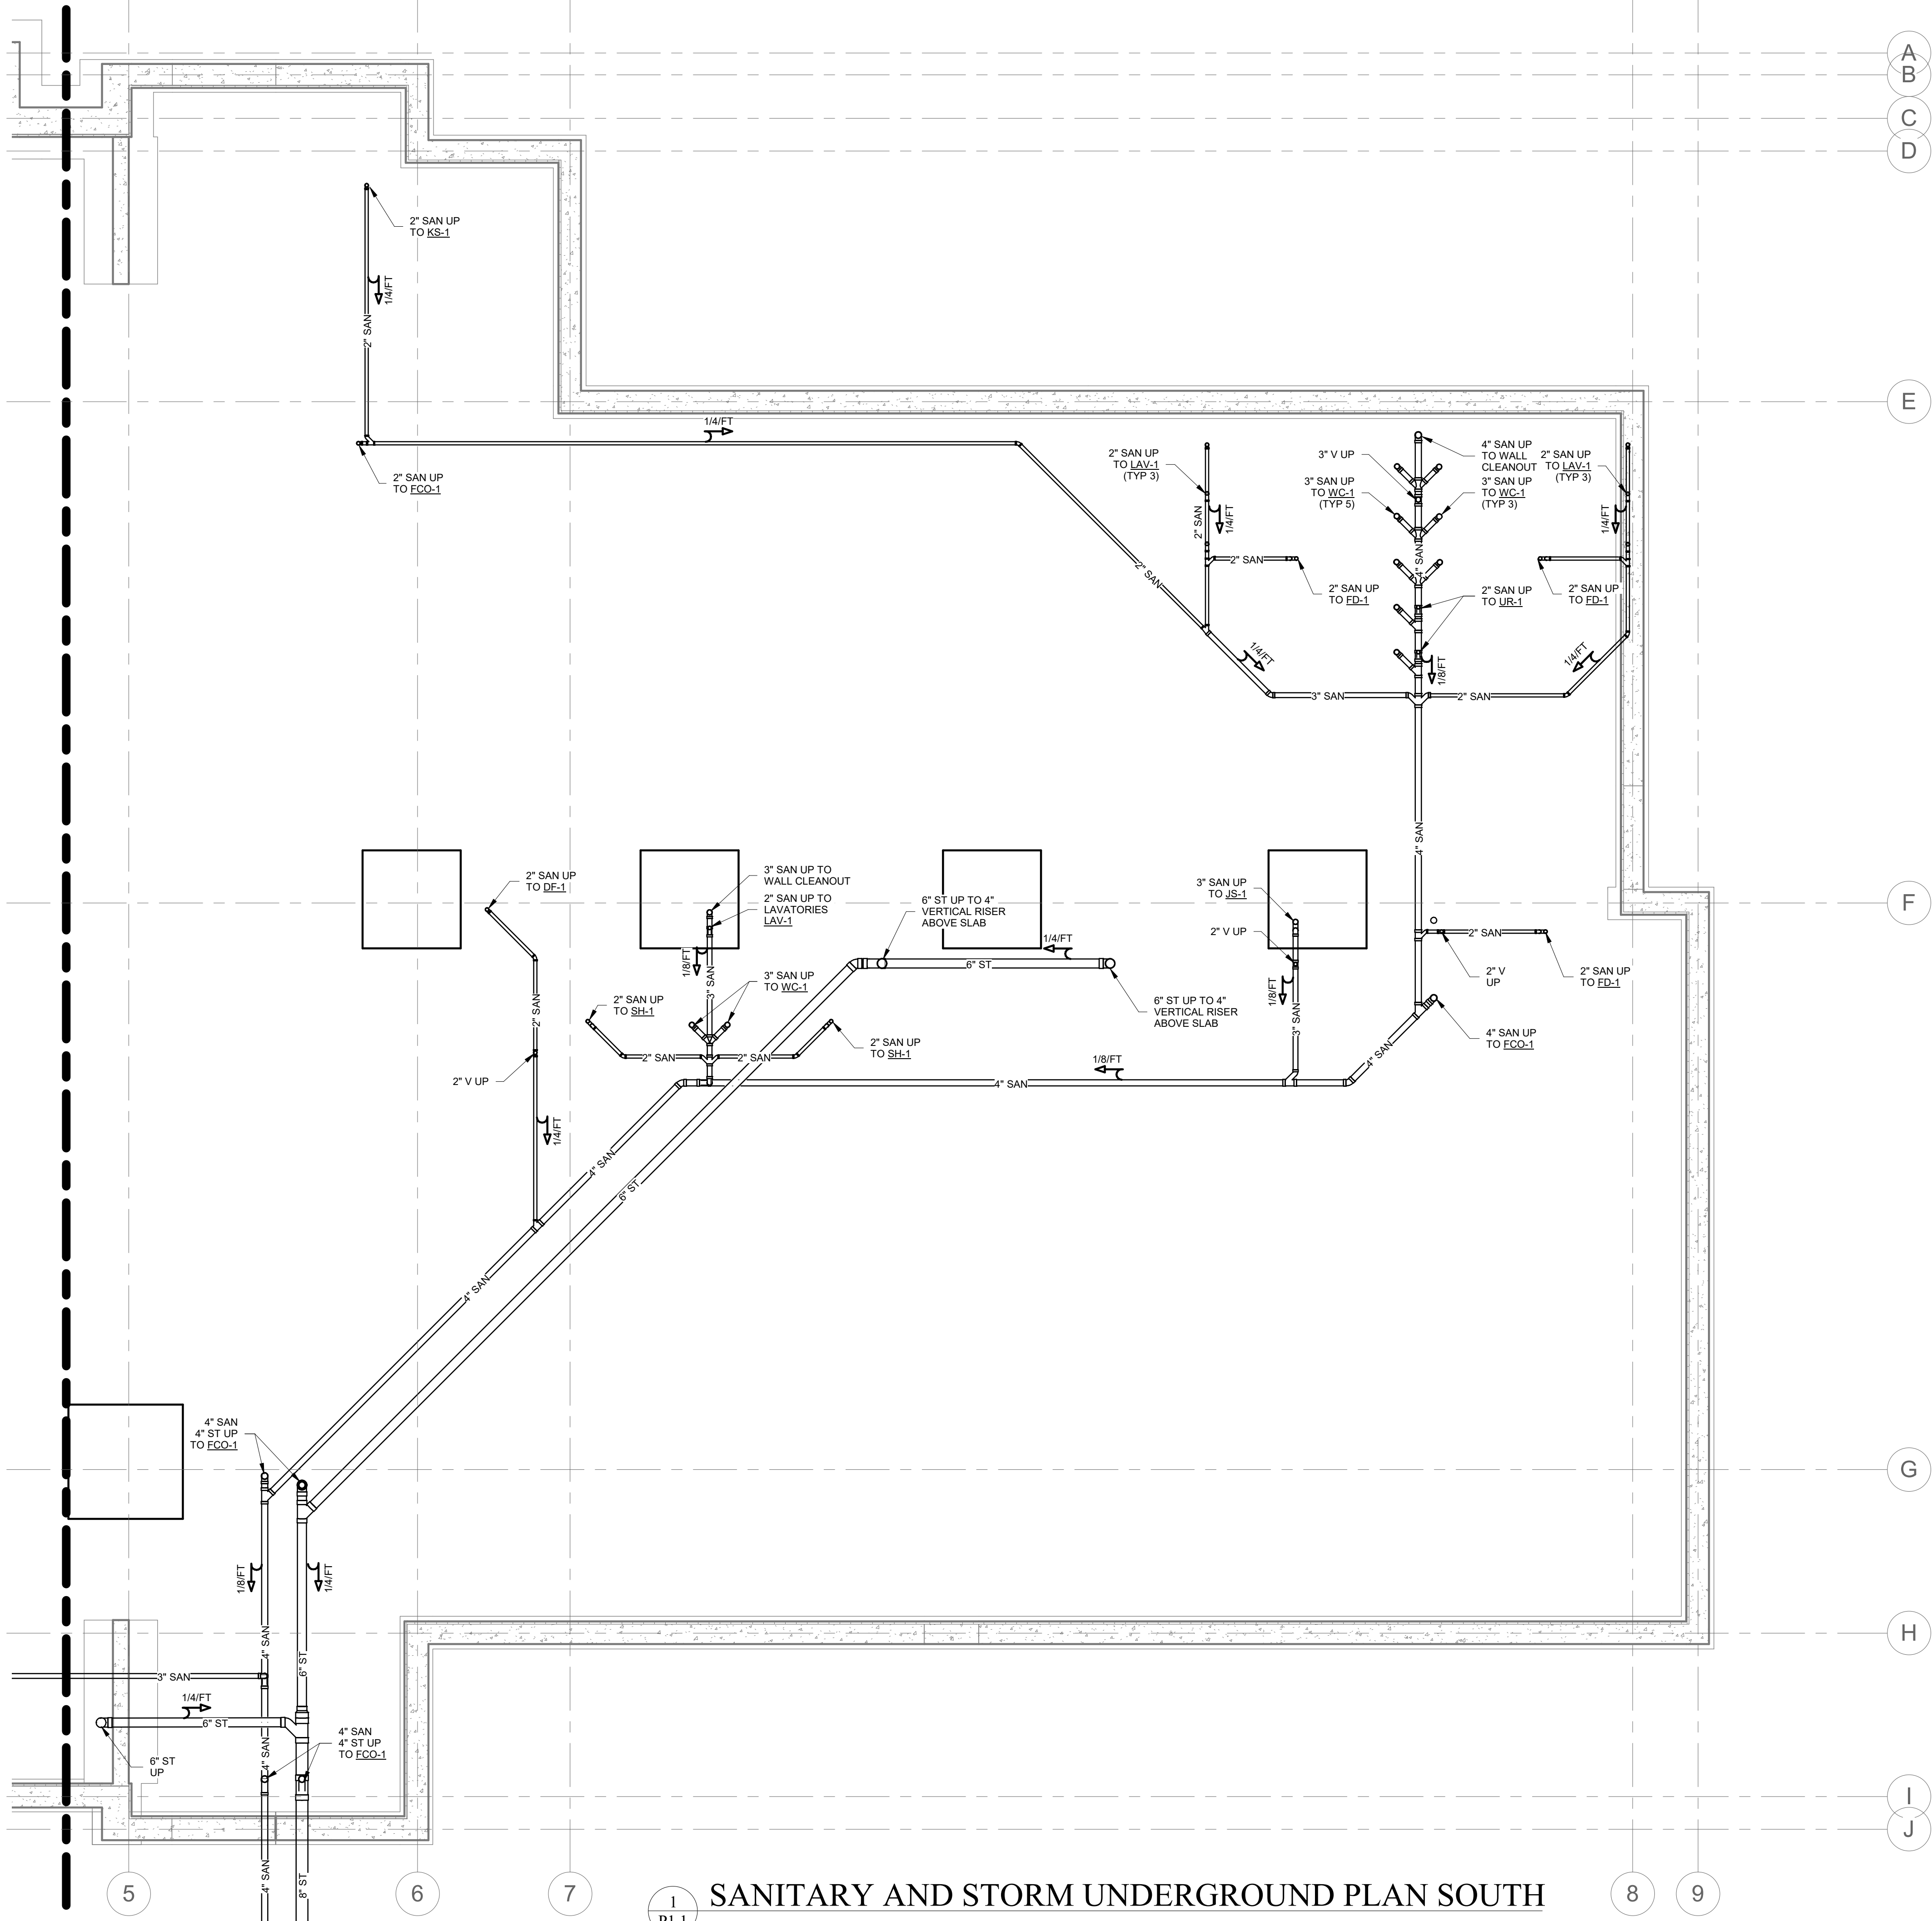

1
P1.1
SANITARY AND STORM UNDERGROUND PLAN SOUTH
SCALE: 3/16" = 1'-0"

Civil/Structural Engineer

Engineering Ventures, PC
85 Mechanic Street, Suite E2-3
Lebanon, NH 03766
P (603) 442-9333
F (603) 442-9331

Mechanical Engineer

VHV Company
16 Teegan Street
Winooski, VT 05404
P (802) 655-8805
F (802) 655-8809

Electrical Engineer

Interstate Electrical Services
15 Cote Lane
Bedford, NH 03110
P (603) 627-3230

Fire Protection Engineer

John L. Carter Sprinkler
Company, Inc.
9 Dunklee Road
Bow, NH 03304
P (603) 224-5438
F (603) 224-6481

© 2018, Bread Loaf Corporation
Seal:

Revised

No.	Date	Description
A	1/31/19	DESIGN DEVELOPMENT



NEWPORT
COMMUNITY CENTER

NEWPORT, NH

Proj. No: 5205 Drawn: COH
Date: 1/31/2019 Chk'd: NHC


GROUND FLOOR
SANITARY AND
STORM PLAN NORTH

P1.2

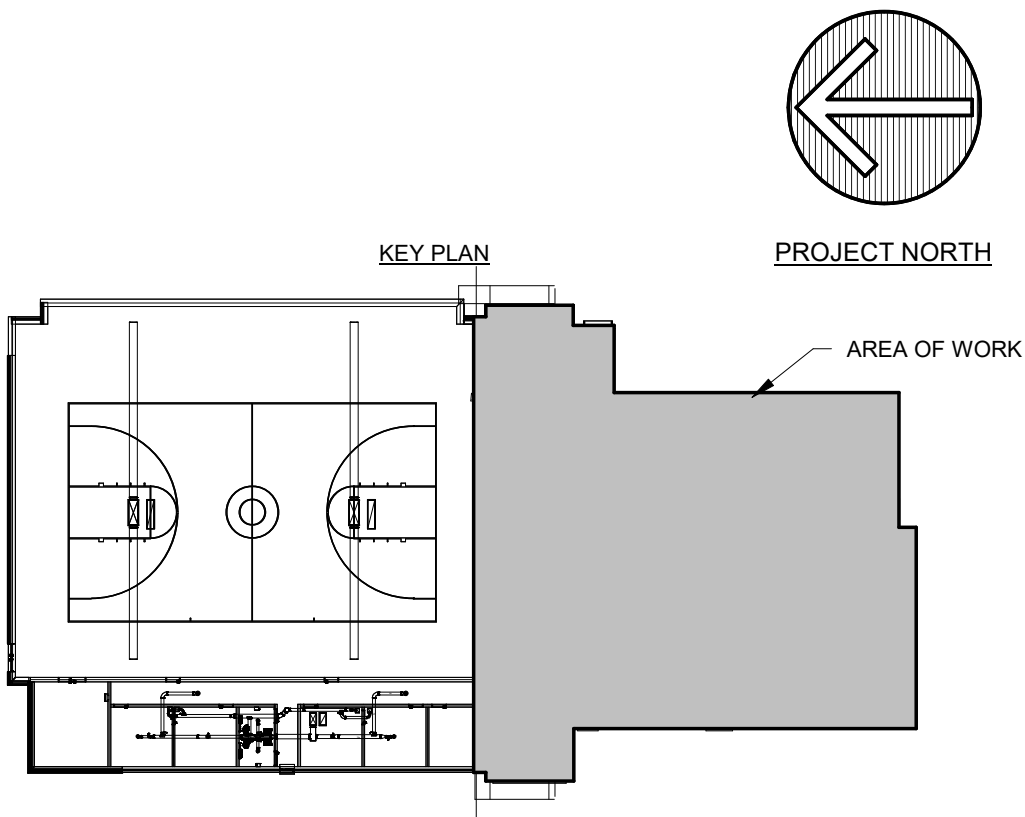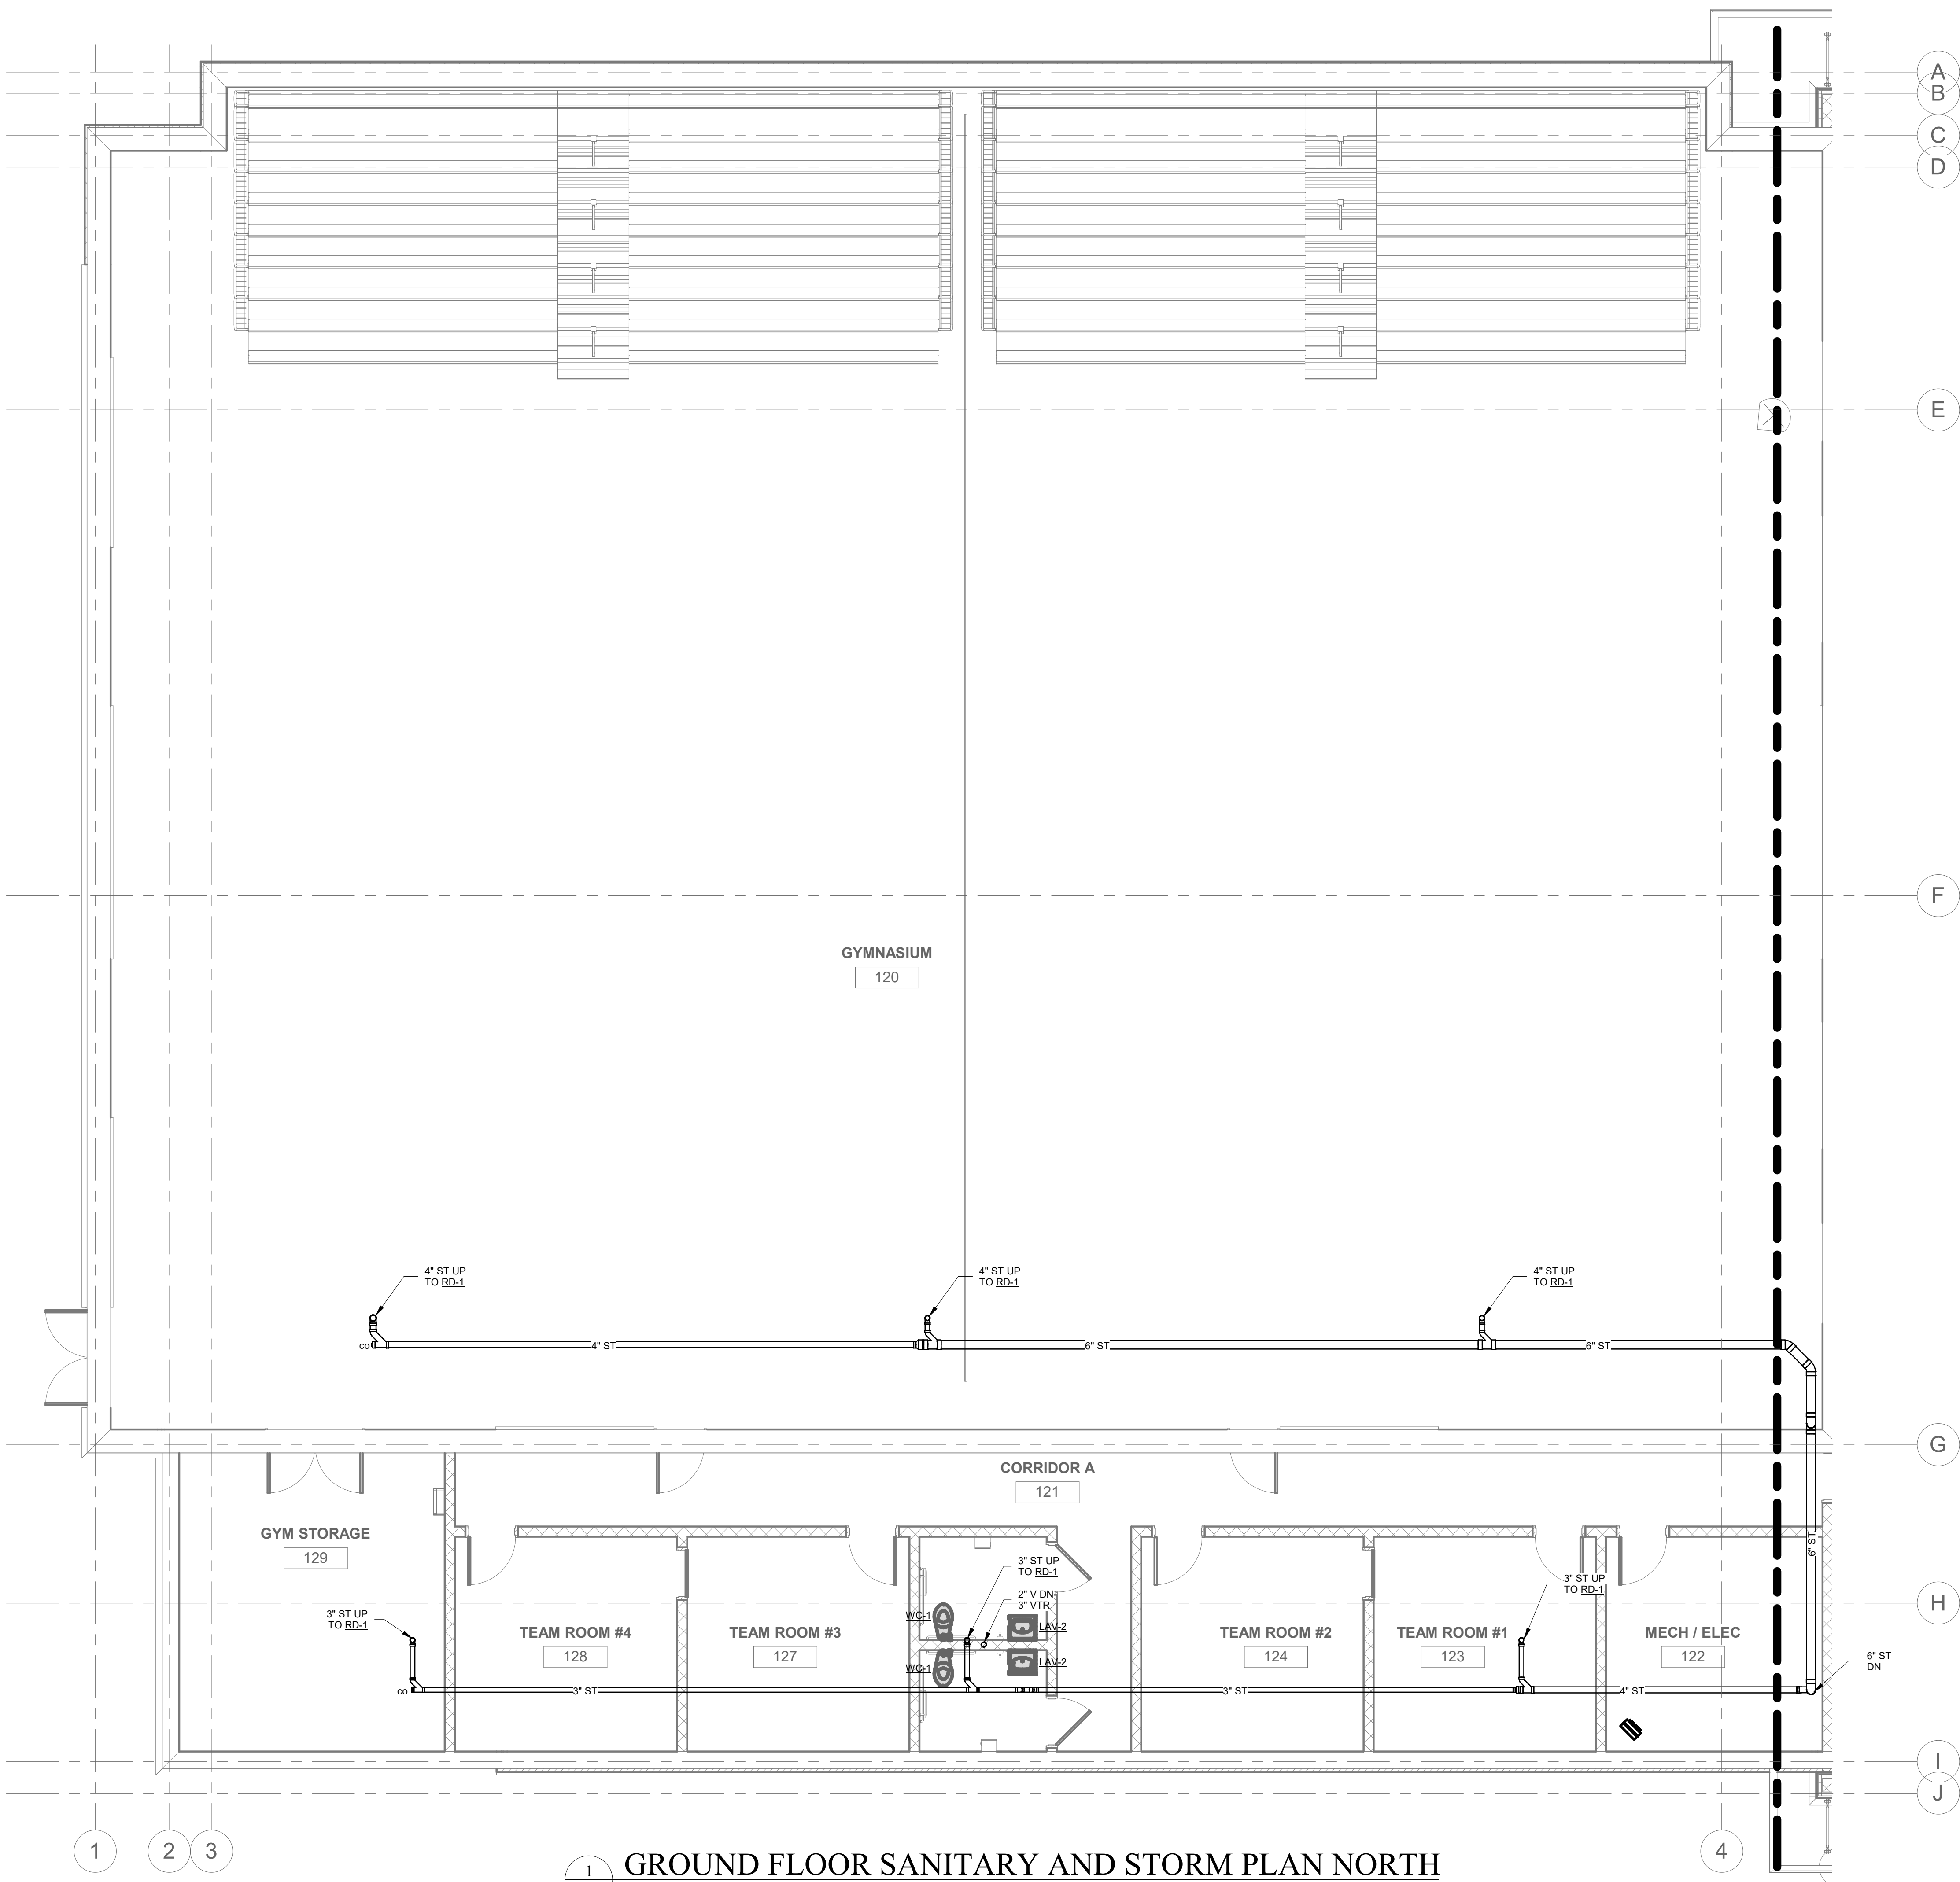


DESIGN DEVELOPMENT

No.	Date	Description
A	1/31/19	DESIGN DEVELOPMENT

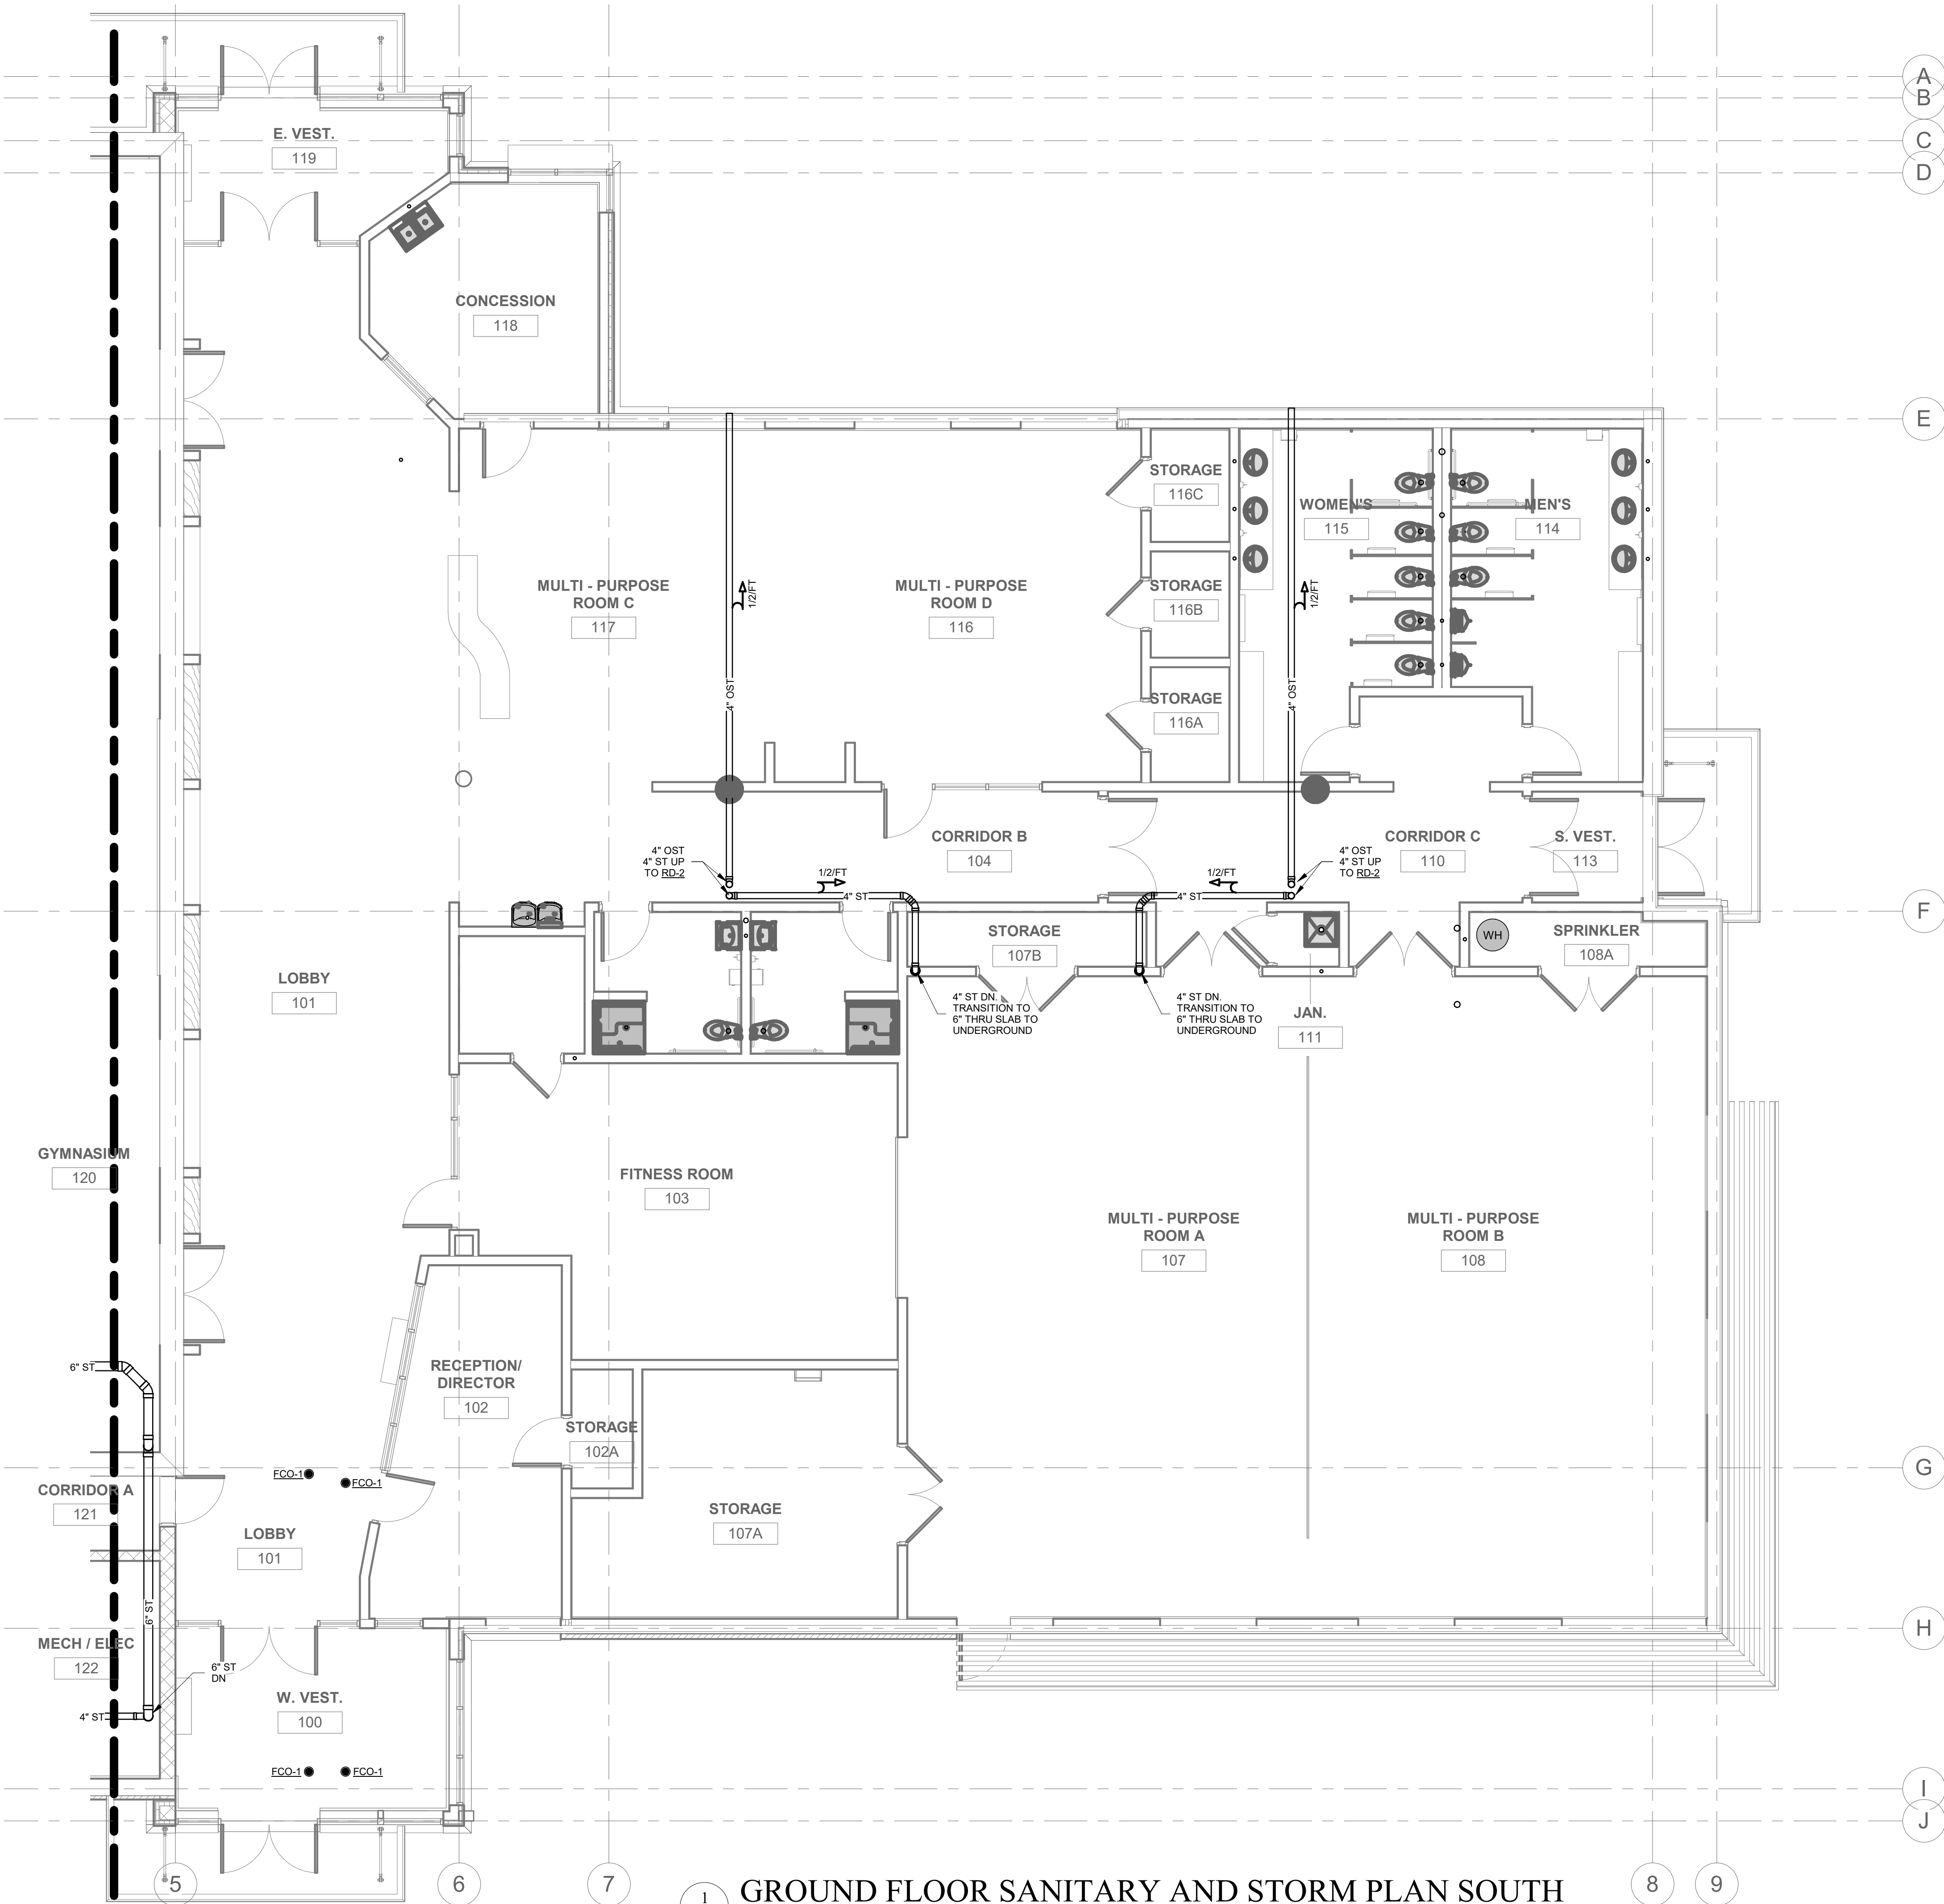

1
P1.3
SCALE: 3/16" = 1'-0"

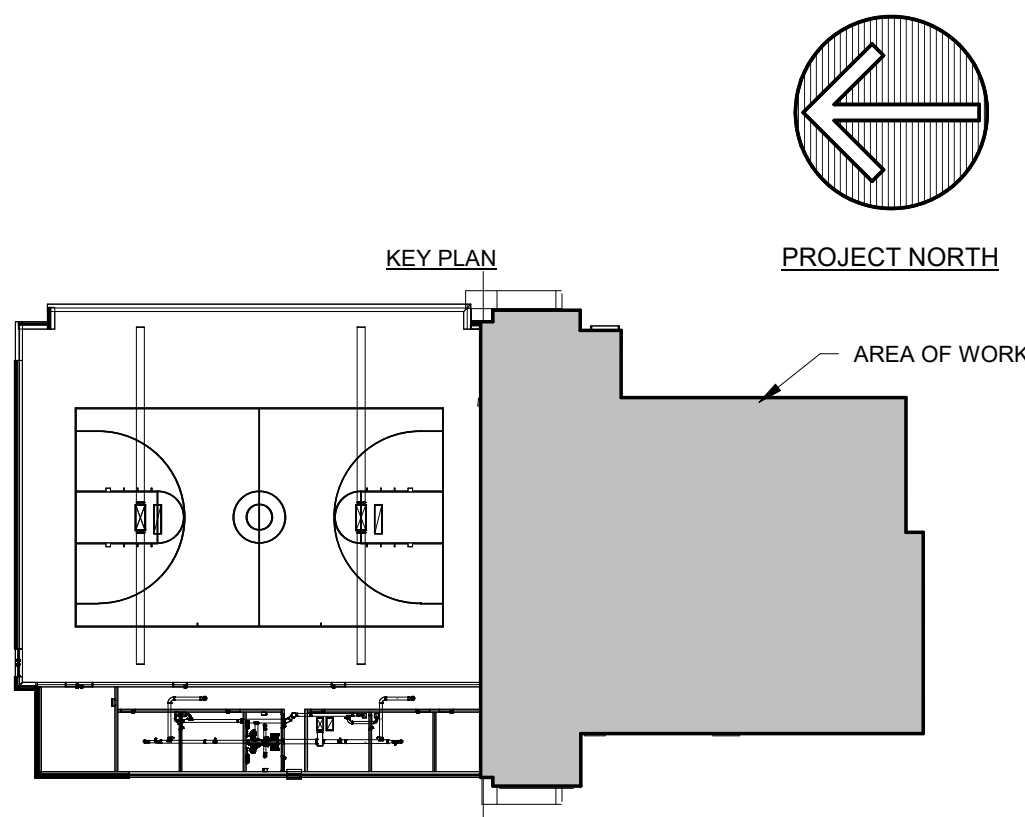

DESIGN DEVELOPMENT

Civil/Structural Engineer

Engineering Ventures, PC
85 Mechanic Street, Suite E2-3
Lebanon, NH 03766
P (603) 442-9333
F (603) 442-9331

Mechanical Engineer

VHV Company
16 Teegan Street
Winooski, VT 05404
P (802) 655-8805
F (802) 655-8809

Electrical Engineer

Interstate Electrical Services
15 Cote Lane
Bedford, NH 03110
P (603) 627-3230

Fire Protection Engineer

John L. Carter Sprinkler
Company, Inc.
9 Dunklee Road
Bow, NH 03304
P (603) 224-5438
F (603) 224-6481

© 2018, Bread Loaf Corporation
Seal:

Revised

No.	Date	Description
A	1/31/19	DESIGN DEVELOPMENT



NEWPORT
COMMUNITY CENTER

NEWPORT, NH

Proj. No: 5205 Drawn: COH
Date: 1/31/2019 Chk'd: NHC

GROUND FLOOR
DOMESTIC WATER
PLAN NORTH

P1.4

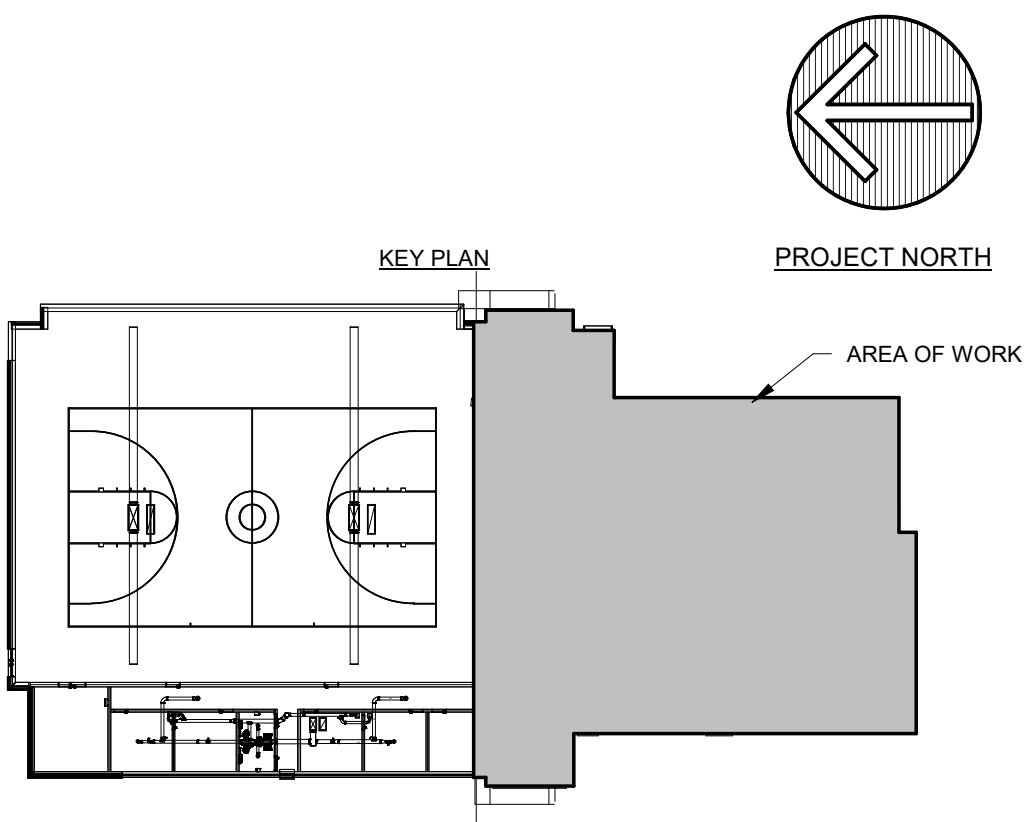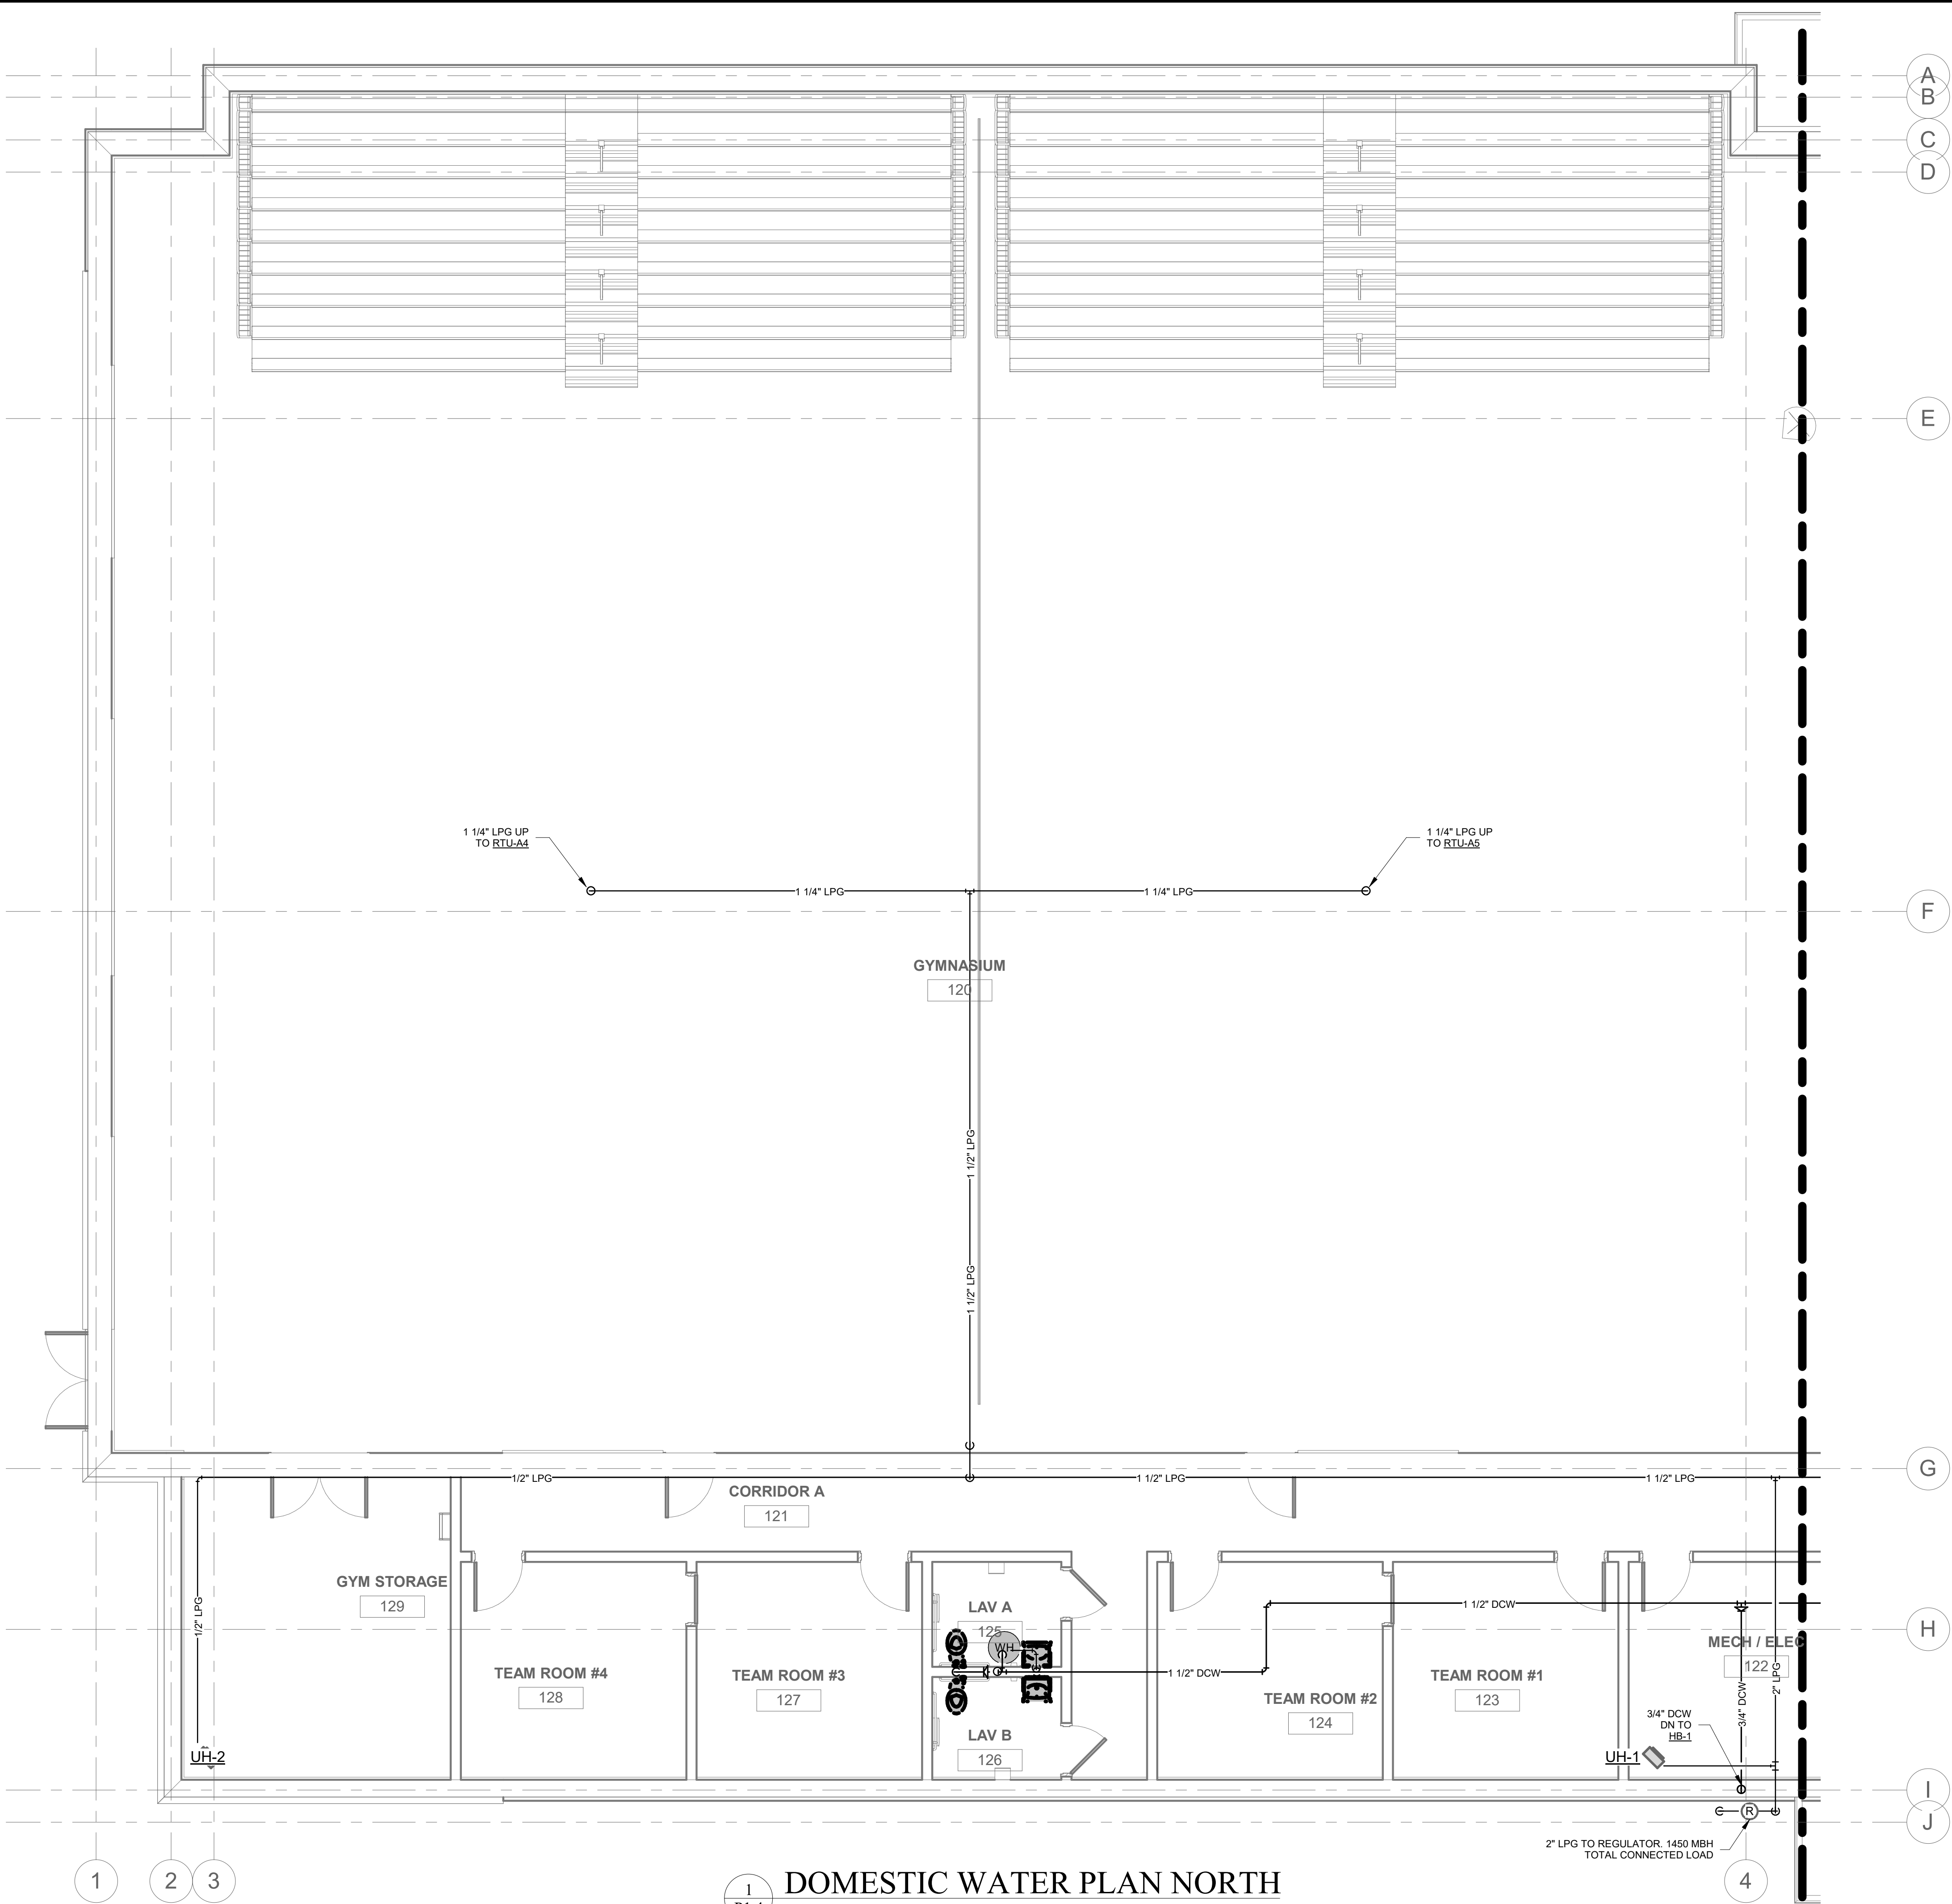

DESIGN DEVELOPMENT

Civil/Structural Engineer

Engineering Ventures, PC
85 Mechanic Street, Suite E2-3
Lebanon, NH 03766
P (603) 442-9333
F (603) 442-9331

Mechanical Engineer

VHV Company
16 Teegan Street
Winooski, VT 05404
P (802) 655-8805
F (802) 655-8809

Electrical Engineer

Interstate Electrical Services
15 Cote Lane
Bedford, NH 03110
P (603) 627-3230

Fire Protection Engineer

John L. Carter Sprinkler
Company, Inc.
9 Dunklee Road
Bow, NH 03304
P (603) 224-5438
F (603) 224-6481

© 2018, Bread Loaf Corporation
Seal:


Revised

No.	Date	Description
A	1/31/19	DESIGN DEVELOPMENT


NEWPORT
COMMUNITY CENTER
NEWPORT, NH

Proj. No: 5205 Drawn: COH
Date: 1/31/2019 Chk'd: NHC
GROUND FLOOR
DOMESTIC WATER
PLAN SOUTH

P1.5

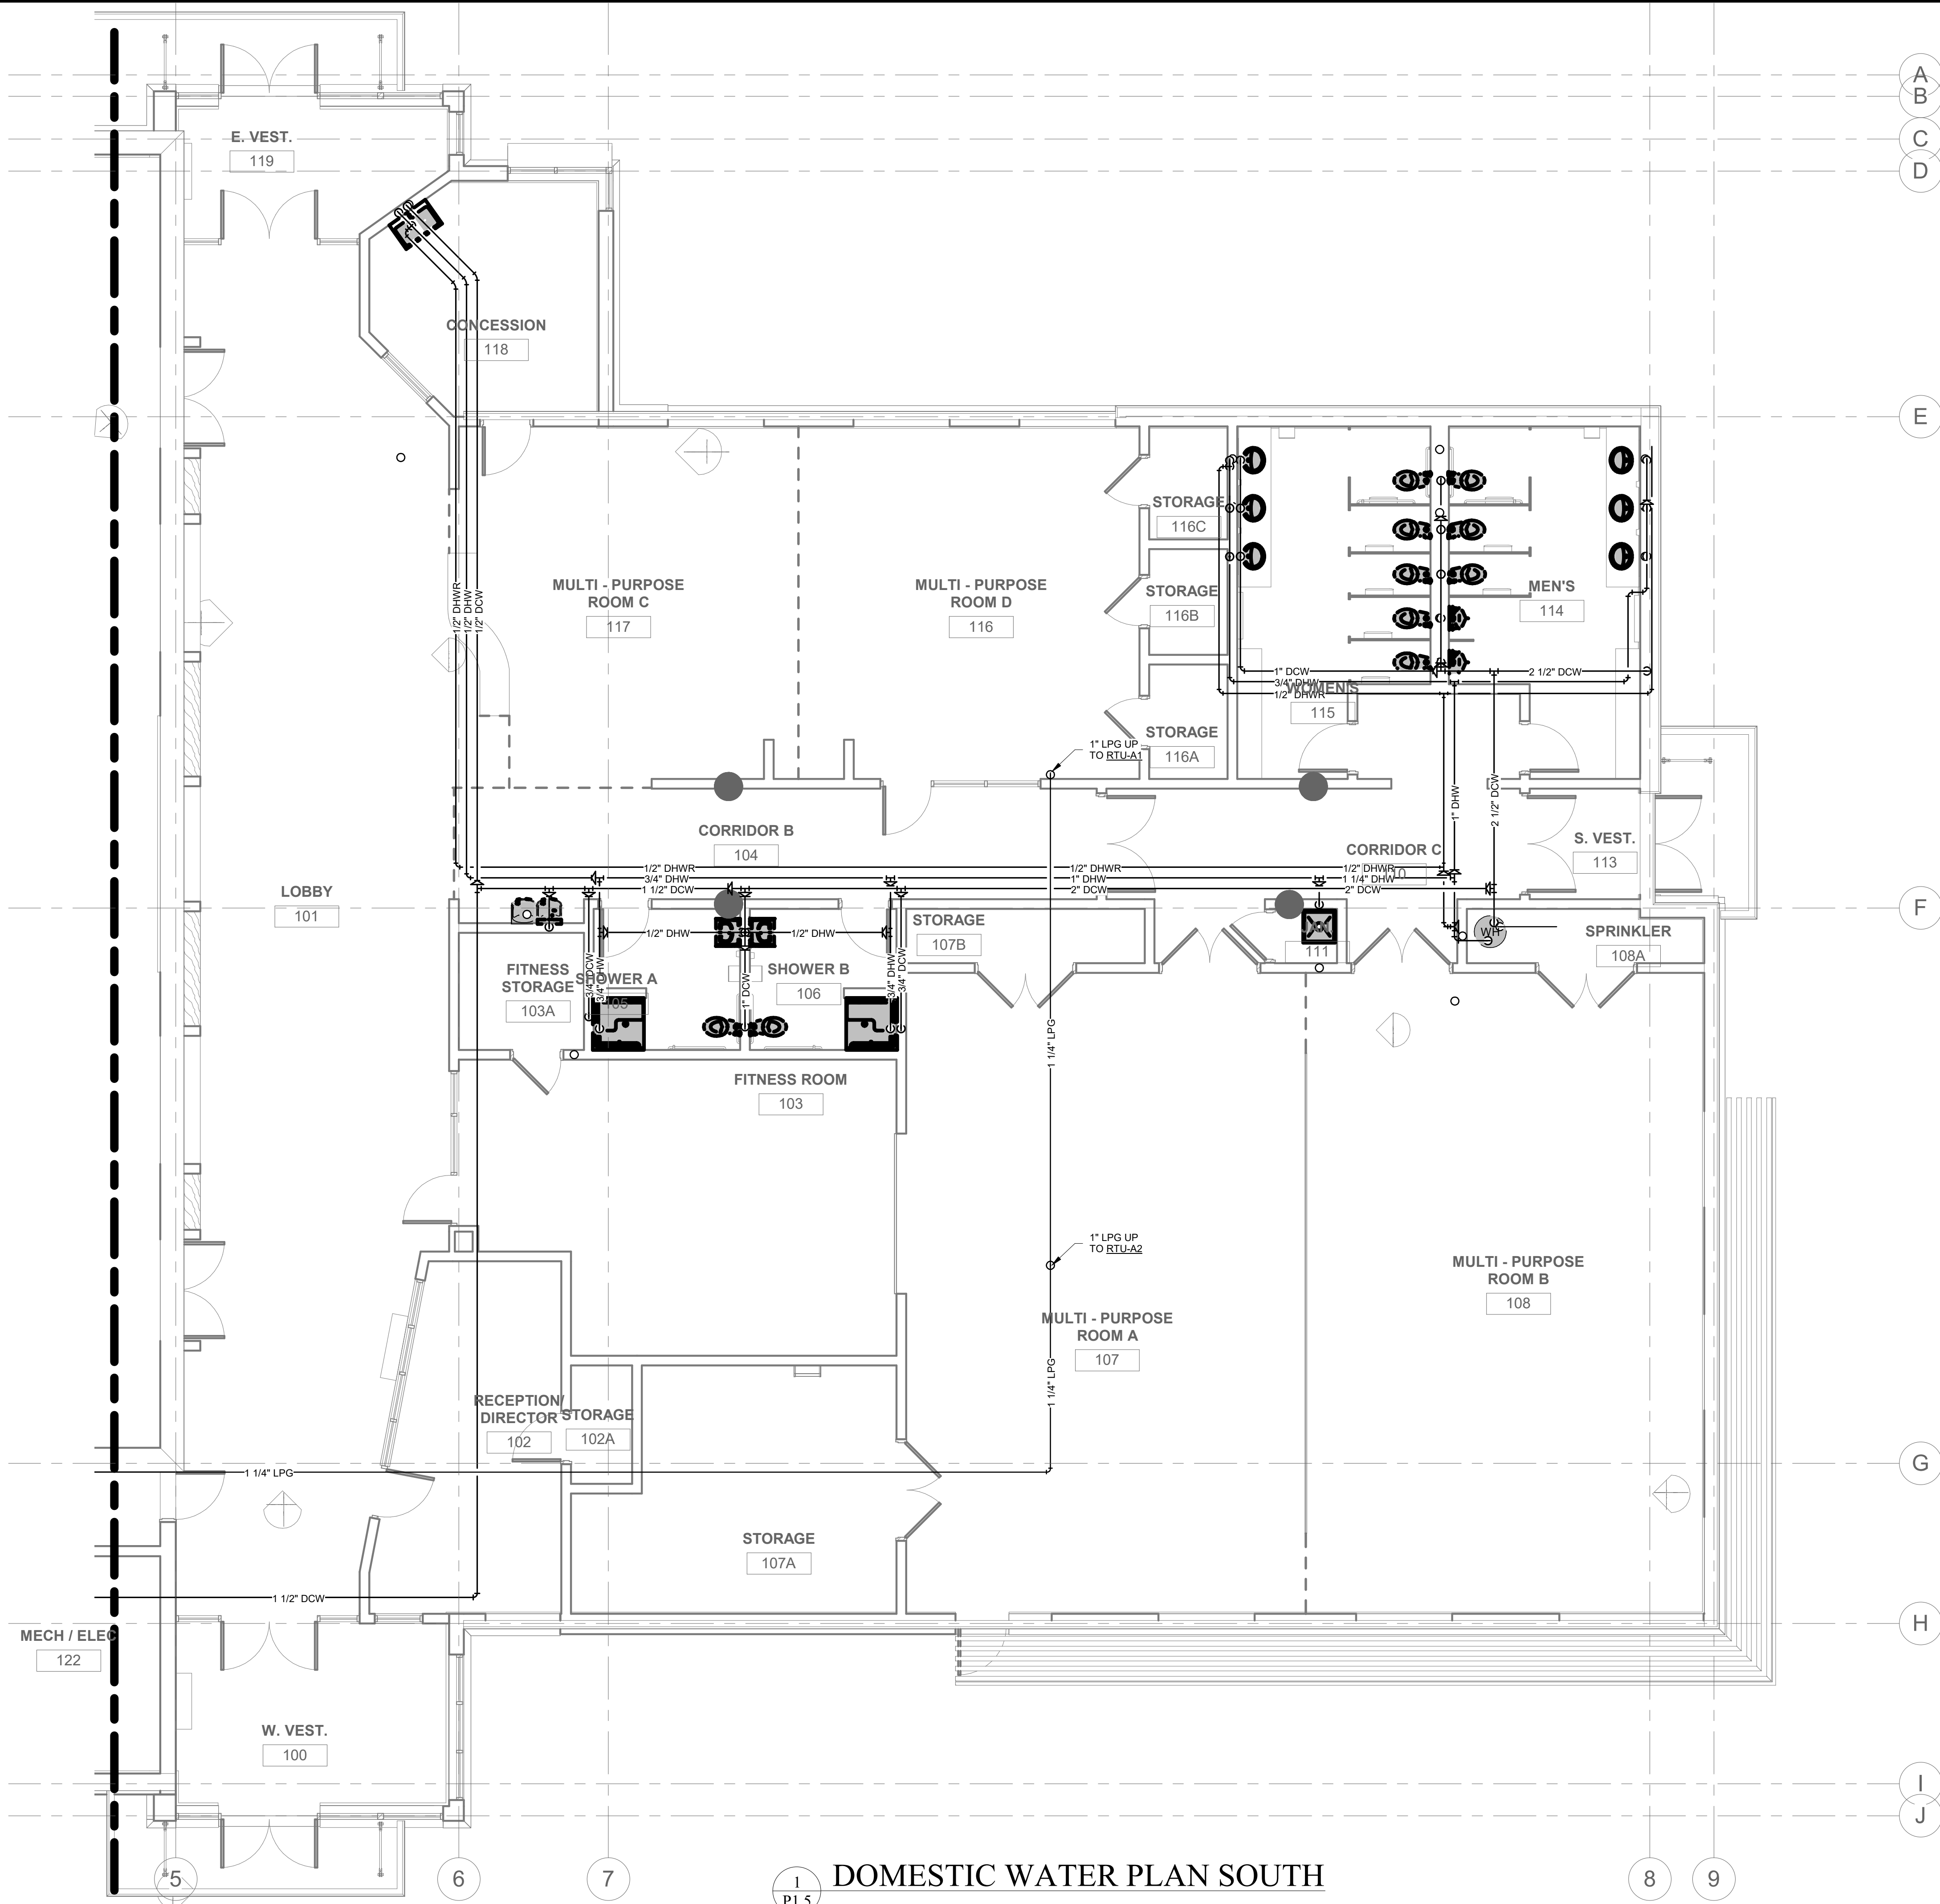

1
P1.5 DOMESTIC WATER PLAN SOUTH
SCALE: 3/16" = 1'-0"

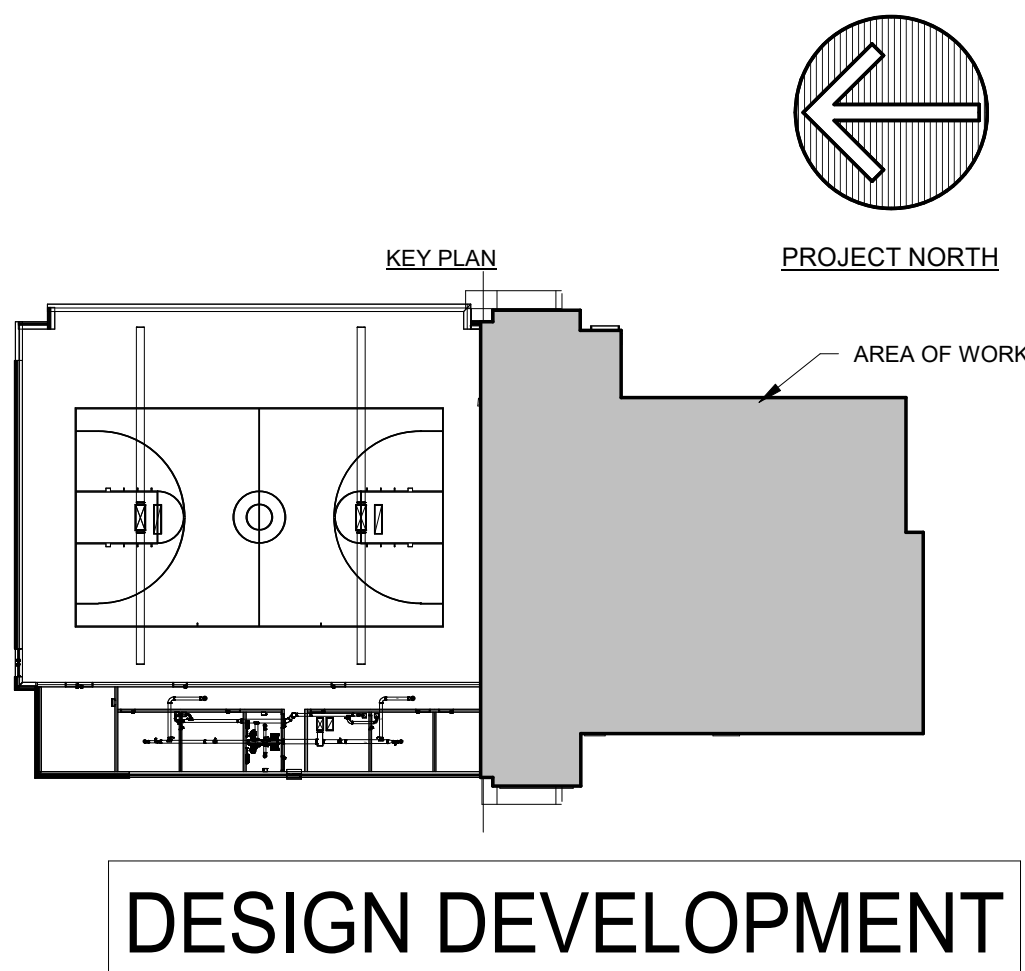

DESIGN DEVELOPMENT