


NEWPORT COMMUNITY CENTER

NEWPORT, NH



DRAWING LIST

Life Safety / Civil	Architectural	Structural	Mechanical	Plumbing	Electrical
LS-1.0 Life Safety Plan C2.0 Site Plan C3.0 Site Details C3.1 Utility Details	A-1.1 Graphic Legend - Exterior Wall Types A-1.2 Architectural Site Plan A-2.1 First Floor Plan A-2.2 High Lobby Plan and Plan Dtls. A-2.3 Roof Plan A-3.1 Reflected Ceiling Plan A-4.1 West and South Bldg. Elevations A-4.2 North and East Bldg. Elevations A-5.1 Building Sections A-6.1 Exterior Wall Sections A-6.2 Exterior Wall Sections A-6.3 Exterior Wall Sections A-8.1 Door Schedule & Details A-8.2 Exterior Storefront Elevations A-8.4 Interior Storefront Elevations & Details A-9.1 Finish Schedule A-9.2 Partition Types and Notes A-9.3 Restroom Plans and Elevations A-9.4 Gymnasium Interior Elevations A-9.5 Gymnasium Interior Elevations A-9.6 Gym Floor Layout Plan A-9.7 Lobby Interior Elevations A-9.8 Multi - Purpose AB Interior Elevations	S0.01 - GENERAL NOTES AND B.O.D. S0.02 - GENERAL NOTES S0.03 - SCHEDULES S1.01 - FOUNDATION PLAN S1.02 - LOW ROOF FRAMING PLAN S1.03 - HIGH ROOF FRAMING PLAN S2.01 - TYPICAL FOUNDATION DETAILS S2.10 - FOUNDATION DETAILS S3.01 - TYPICAL FRAMING DETAILS S3.02 - TYPICAL JOIST DETAILS S3.03 - TYPICAL MASONRY DETAILS S3.10 - FRAMING DETAILS S4.01 - BRACING DETAILS S4.10 - BRACED FRAME ELEVATIONS			

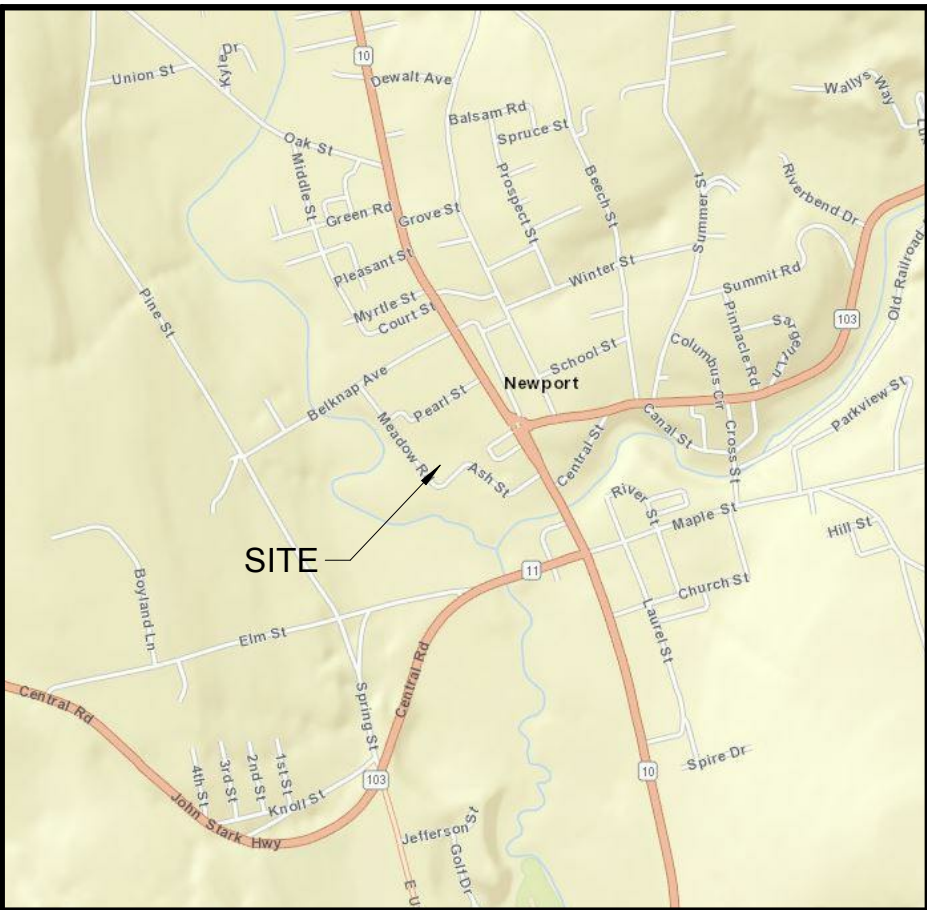

Location Map

Revised		
No.	Date	Description

NEWPORT
COMMUNITY CENTER

NEWPORT, NH

Proj. No: 18412 Drawn: SR
Date: 12/20/2018 Chk'd: JD

Cover Sheet

DESIGN DEVELOPMENT

CS-1

CODE SUMMARY

PROJECT TYPE

☒ NEW CONSTRUCTION
☐ ADDITION
☐ RENOVATION

☐ MODIFICATION
☐ RECONSTRUCTION
☐ CHANGE OF USE

Newport Building Regulations

APPLICABLE CODES

NEWPORT / NH STATE BUILDING CODES

NH STATE FIRE CODE SAF-C 6000
(2015 NFPA 101 LIFE SAFETY)

2009 IBC / 2009 IECC

2010 NFPA 13 SPRINKLERS

2010 ADA STANDARDS
2009 IBC CHAPTER 11 ACCESSIBILITY / ICC A117.1

2009 INTERNATIONAL PLUMBING CODE

2014 NATIONAL ELECTRICAL CODE

2010 NFPA 72 FIRE ALARM

USE AND OCCUPANCY CLASSIFICATION - List ALL occupancies

LIFE SAFETY OCCUPANCY

Assembly

MIXED USE: ☐ yes ☒ no

LS Section

Chptr 12

IF YES: ☐ NON-SEPARATED ☐ SEPARATED

IBC OCCUPANCY

A-3 Assembly

IBC Section

303.1

CLASSIFICATION OF HAZARD OF CONTENTS

☐ LOW

☒ ORDINARY

☐ HIGH

HEIGHT AND AREA LIMITATIONS

SPRINKLER INCREASE: ☐ N/A ☐ 200% ☒ 300%

FRONTAGE INCREASE: ☒ N/A ☐ YES _____ % ALLOWABLE INCREASE

HEIGHT AND AREA CALCULATIONS

BASE AREA From Table 503

9500

2

55

ALLOWABLE SPRINKLER INCREASE

28500

1

20

ALLOWABLE TOTALS WITH INCREASES

38000

3

75

USE GROUP: A-3

ALLOWED

PROPOSED

STORIES ABOVE GRADE

3

1

BUILDING HEIGHT

75FT

35FT

LARGEST FLOOR AREA

38,000

19,721

CONSTRUCTION TYPE

TYPE IIB, NON-COMBUSTIBLE,
UNPROTECTED
TYPE II (000)

IBC 602.5
LS 12.1.6 (Assembly at Level of Exit Discharge)

FIRE RESISTANCE RATINGS

BUILDING

PRIMARY STRUCTURAL FRAME

0 HR.

601

EXTERIOR BEARING WALLS

NA

601

INTERIOR BEARING WALLS

0 HR.

601

NONBEARING EXTERIOR WALLS

0 HR.

601

NONBEARING INTERIOR WALLS

0 HR.

601

FLOOR

0 HR.

601

ROOF

0 HR.

601

INCIDENTAL USE

BOILER ROOMS

SPRINKLED/SMOKE SEP.

Table 508.2.5, LS 12.3.2.1.2(1)

EGRESS ENCLOSURES

EXIT ACCESS CORRIDORS

0 HR. (SMOKE SEPARATION)

LS 12.3.6 (2)
IBC 1018.1

OCCUPANT LOAD

MAXIMUM DESIGN BUILDING OCCUPANT LOAD (SEE TABLE)

871

NUMBER OF EXITS

LEVEL / STORY

1

OCCUPANCY

500 < Occ Load > 1000

REQUIRED

3

CODE SECTION

LS 7.4.1.2
IBC 1021.1

EGRESS CAPACITY AND ARRANGEMENT - WITH SPRINKLER SYSTEM

ROOM / USE

MAIN EXIT

MINIMUM WIDTH OF STAIRWAYS

MINIMUM WIDTH OF CORRIDORS, DOORS AND RAMPS

ASSEMBLY AISLES / ACCESSWAYS

ALLOWED

1/2 OF TOTAL OCCP LOAD

SEE LIFE SAFETY FLOOR PLANS

0.2" / OCC. FOR DOORS, CORRIDORS, RAMPS
NOT LESS THAN 44" IF OVER 50 OCC

SEE LIFE SAFETY FLOOR PLANS

PROPOSED

SEE LIFE SAFETY FLOOR PLANS

SEE LIFE SAFETY FLOOR PLANS

SEE LIFE SAFETY FLOOR PLANS

Life Safety Section

LS 2.3.6.2(2)

LS 7.2.2.1.2(B)
IBC 1005.1

LS 7.3.3
IBC 1005.1

IBC 1028, LS 12.2 and 12.3

COMMON PATH OF TRAVEL

DEAD END CORRIDOR LENGTH

MAXIMUM TRAVEL DISTANCE TO EXITS

75ft < 50 occp
20ft > 50 occp
30ft in seating areas

20'-0"

250

SEE LIFE SAFETY FLOOR PLANS

SEE LIFE SAFETY FLOOR PLANS

SEE LIFE SAFETY FLOOR PLANS

LS 12.2.5.1.2
IBC 1028.8

LS 12.2.5.1.3
IBC 1018.4

LS 14.2.6.3
IBC 1028.7

FIRE PROTECTION SYSTEMS

FIRE ALARM: ☒ MANUAL ☒ AUTOMATIC DETECTION ☐ SINGLE STATION SMOKE ALARM ☐ CO ALARM

SPRINKLER SYSTEM: ☐ N/A ☒ COMPLETE ☐ LIMITED AREA ☒ 13 SYSTEM ☐ 13R SYSTEM ☐ 13D SYSTEM

STANDPIPES: ☐ yes ☒ no

FIRE PROTECTION WATER SUPPLY: ☒ TESTED MUNICIPAL SYSTEM ☐ ON SITE SYSTEM

PLUMBING FIXTURES BASED ON 871 OCCUPANTS / 2 = 435 PER SEX

FIXTURE

WATER CLOSETS

LAVATORIES

DRINKING FOUNTAINS

SERVICE SINK

MALE

1:125=4

1:200=3

1:500 = 2

1

FEMALE

1:65=7

1:200=3

IBC Section

Table 2902.1

Table 2902.1

Table 2902.1

Table 2902.1

INTERIOR FINISHES - SPRINKLERED

ROOM / SPACE

EXIT ENCLOSURES

CORRIDORS / LOBBIES / EXIT ACCESS

ALL OTHERS

WALL & CEILING

B

B


 
C

FLOOR

II

II

II

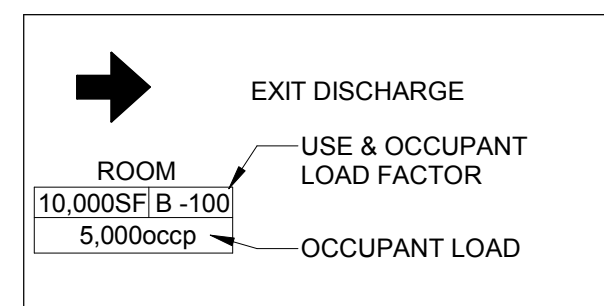

Loaf

1293 Route 7 South
Middlebury, VT 05753
P (802) 388-9871
F (802) 388-3815
www.breadloaf.com

Engineering Ventures, PC
85 Mechanic Street, Suite E2-3
Lebanon, NH 03766
P (603) 442-9333
F (603) 442-9331

VHV Company
16 Teegan Street
Winooski, VT 05404
P (802) 655-8805
F (802) 655-8809

Interstate Electrical Services
15 Cote Lane
Bedford, NH 03110
P (603) 627-3230

P (603) 224-5438
F (603) 224-6481

Seal:

Revised		
No.	Date	Description

No.	Date	Description
-----	------	-------------

NEWPORT, NH

Life Safety Plan

References

LS-1.0


— Summary —

Civil/Structural Engineer
Engineering Ventures, PC
85 Mechanic Street, Suite E2-3
Lebanon, NH 03766
P (603) 442-9333
F (603) 442-9331

Electrical Engineer
Interstate Electrical Services
15 Cote Lane
Bedford, NH 03110
P (603) 627-3230

© 2018, Bread Loaf Corporation
Seal:

BUILDING ENVELOPE ENERGY CODE REQUIREMENTS

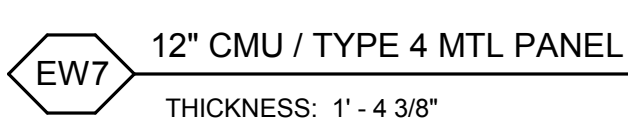

EXTERIOR WALL TYPES - A1.1 LEGEND

DESIGN DEVELOPMENT

Graphic Legend - Exterior Wall Types

A-1.1


Revised		
No.	Date	Description

NEWPORT
COMMUNITY CENTER

NEWPORT, NH

Proj. No: 18412 Drawn: SR
Date: 12/20/2018 Chk'd: JD
**Architectural Site
Plan**

A-1.2

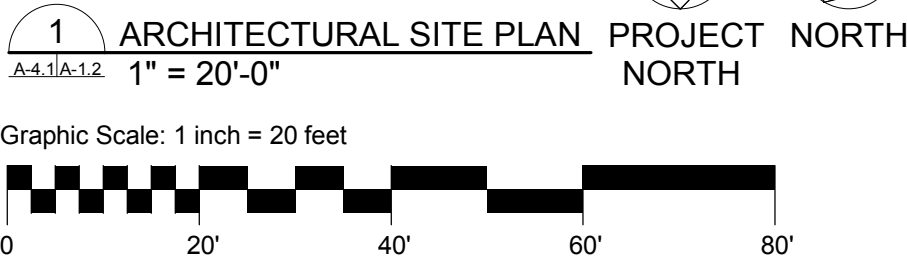

DESIGN DEVELOPMENT

Revised		
No.	Date	Description


NEWPORT
COMMUNITY CENTER

NEWPORT, NH

Proj. No: 18412 Drawn: SR
Date: 12/20/2018 Chk'd: JD

First Floor Plan

A-2.1

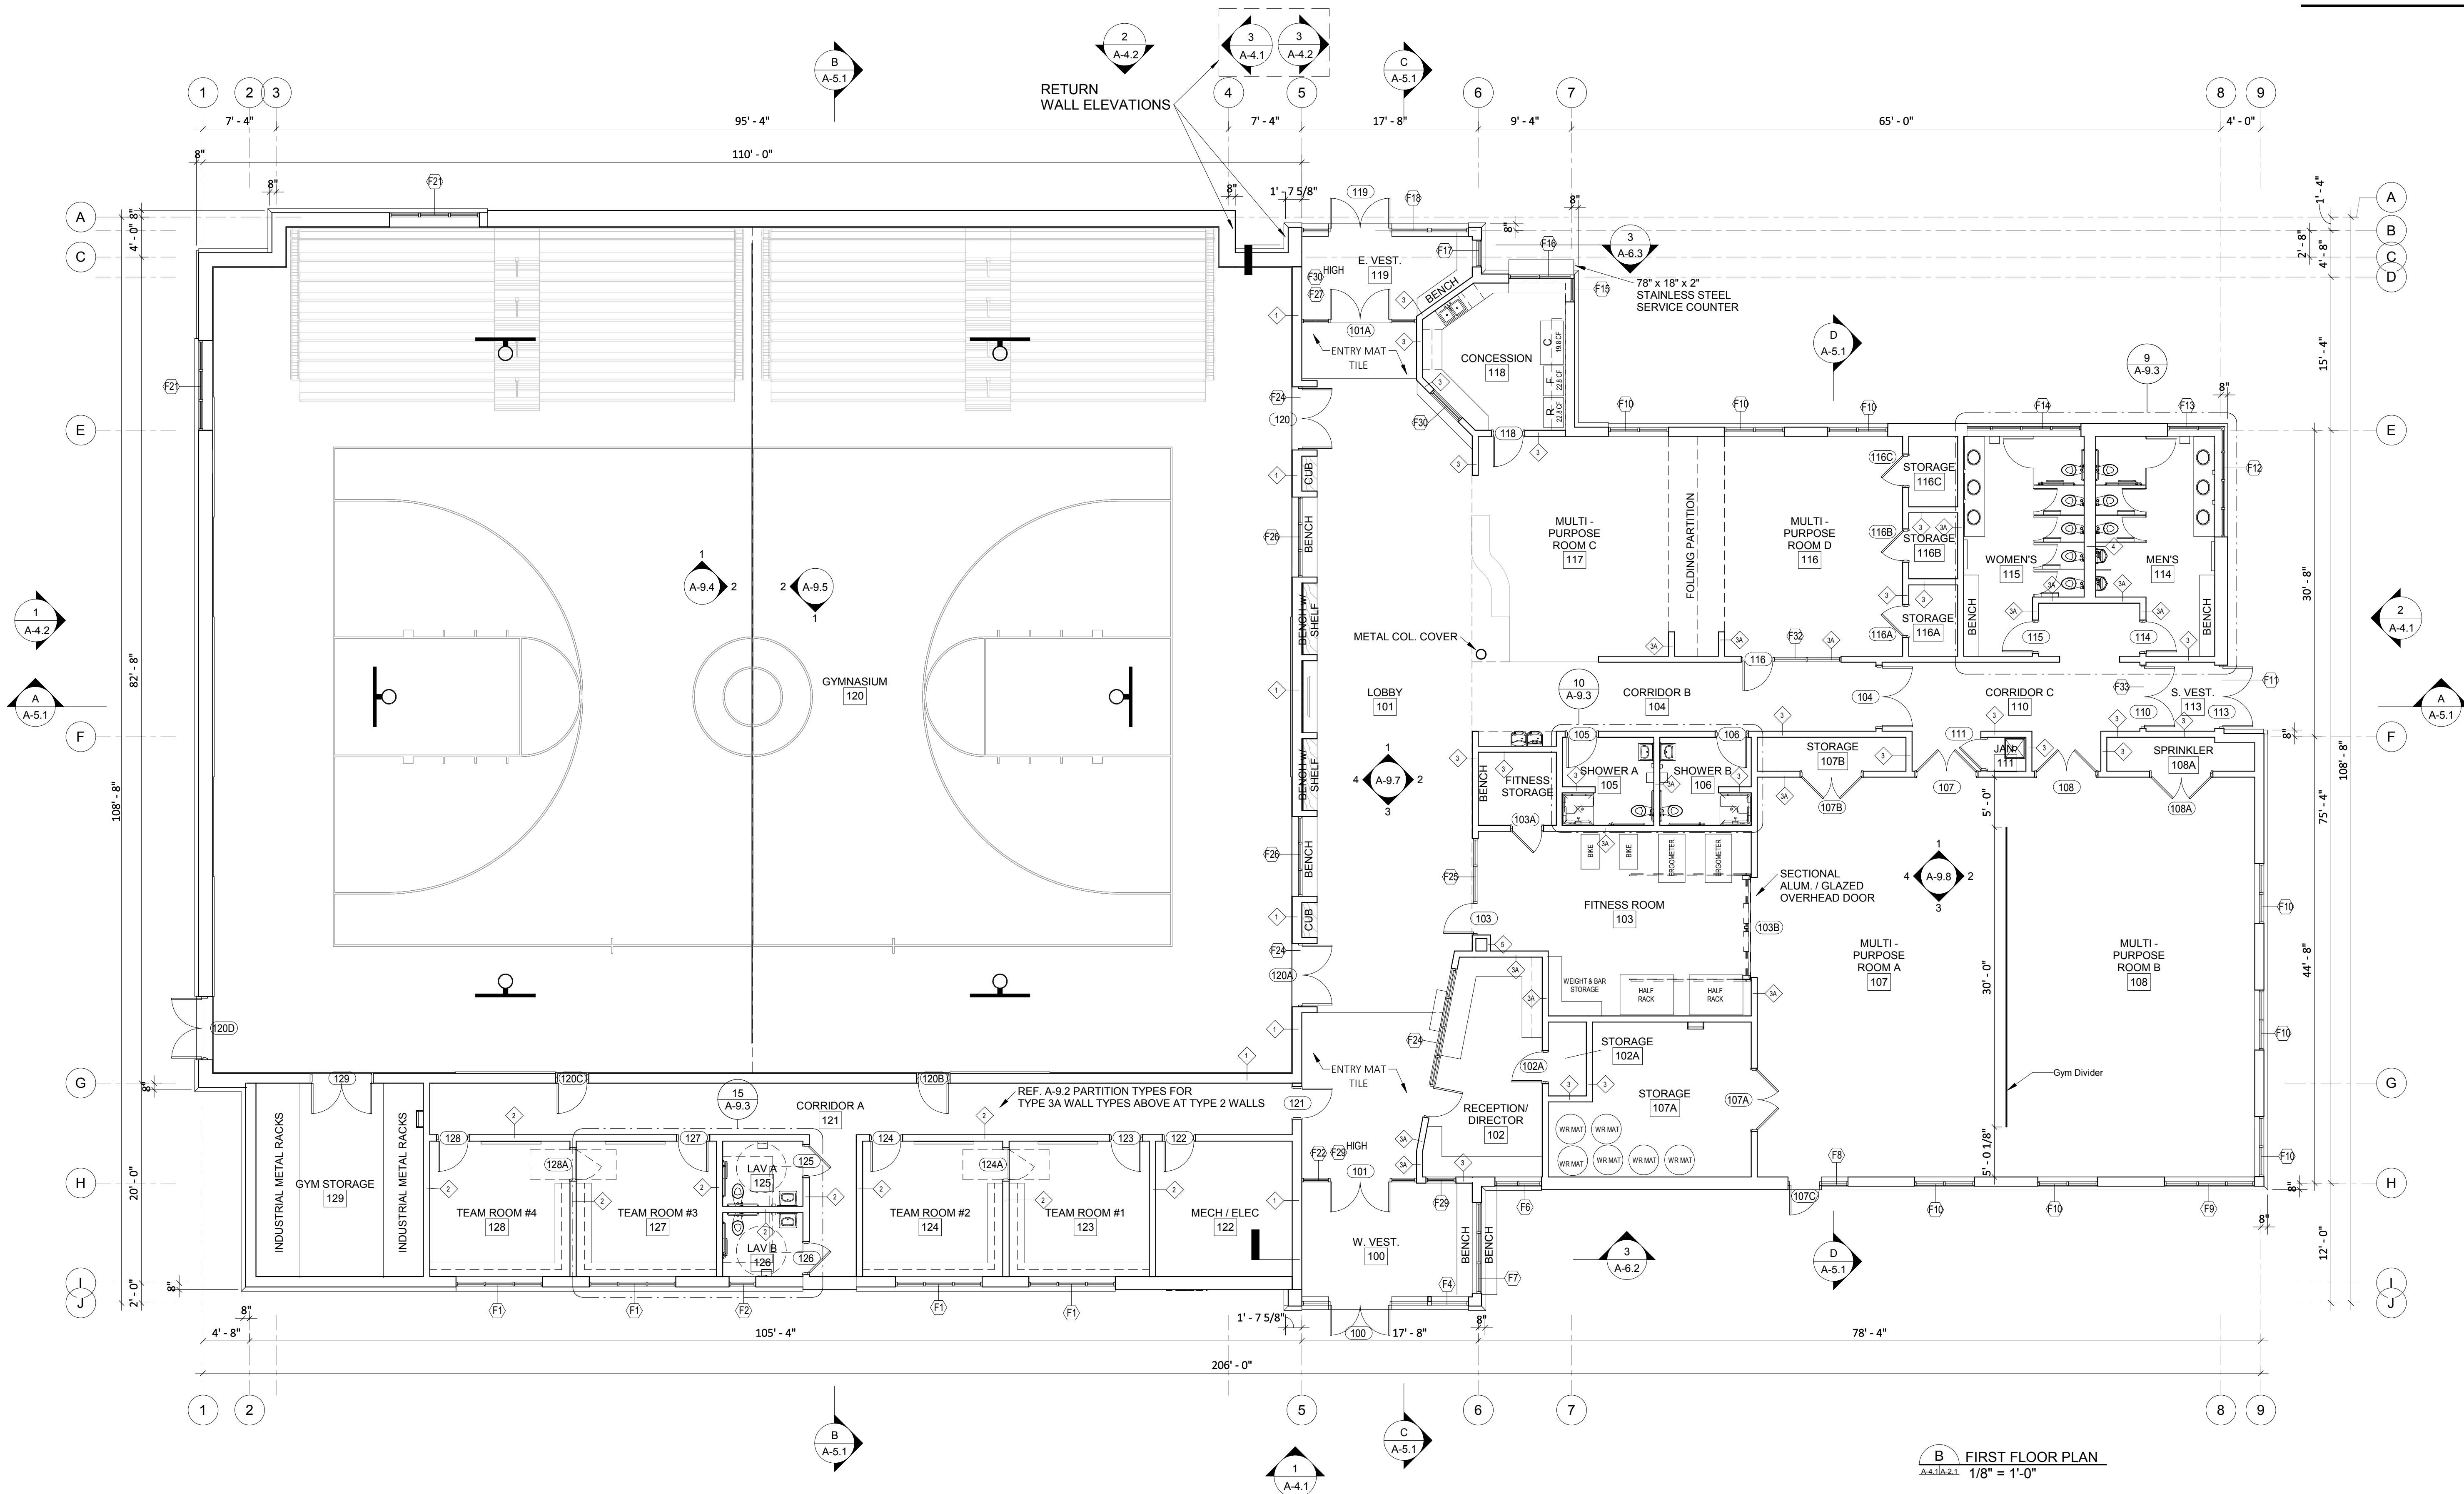

NOTE: SEE A2.2 FOR
HIGH LOBBY FLOOR PLAN
AND REFLECTED CEILING PLAN


GRID NOTE:
ALL GRIDS ARE TO EXTERIOR FACE OF CMU BEARING WALLS
OR FACE OF GYPSUM SHEATHING AT LGS WALLS, AND ALIGNS
WITH THE TOP OF FOUNDATION MASONRY VENEER SHELF STEP,
SEE WALL SECTIONS.

BUILDING FOOTPRINT: 19,829 SF



Graphic Scale: 1 inch = 8 feet



DESIGN DEVELOPMENT

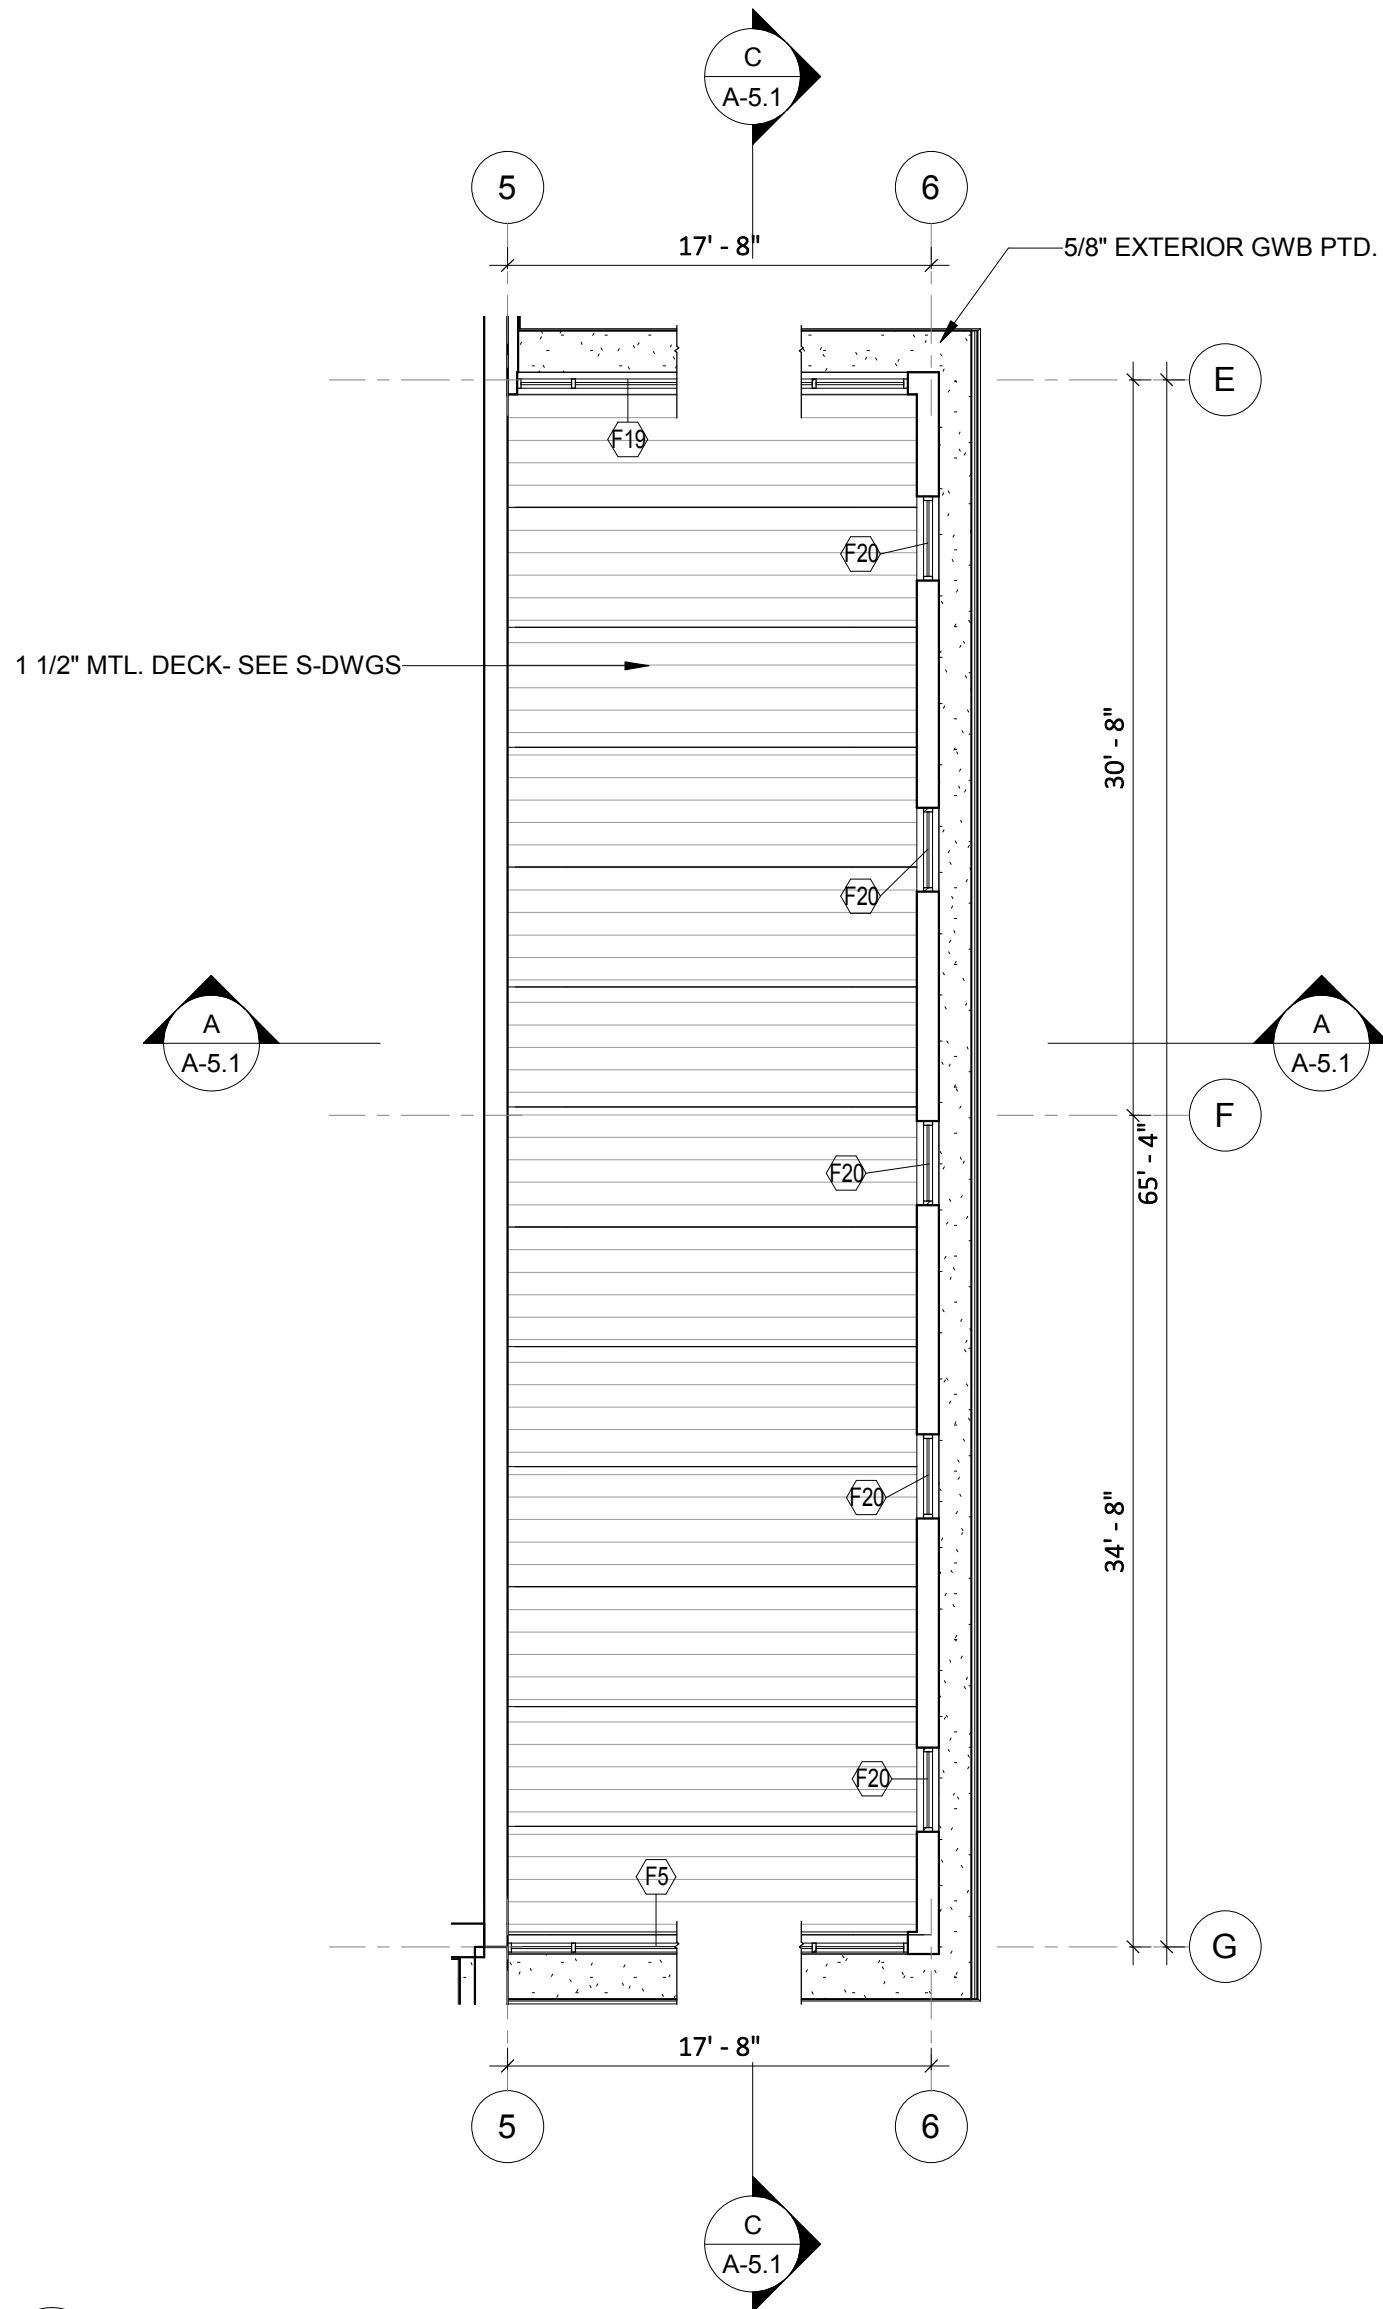

1 HIGH LOBBY PLAN AND RCP
A-4.1/a.2.2 1/8" = 1'-0"

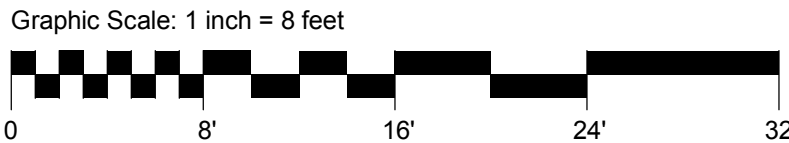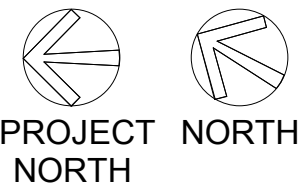

DESIGN DEVELOPMENT

NEWPORT
COMMUNITY CENTER

NEWPORT, NH

Proj. No: 18412 Drawn: SR
Date: 12/20/2018 Chk'd: JD

High Lobby Plan
and Plan Dtls.

A-2.2

DESIGN DEVELOPMENT

Revised		
No.	Date	Description


NEWPORT
COMMUNITY CENTER

NEWPORT, NH

Proj. No: 18412 Drawn: SR
Date: 12/20/2018 Chk'd: JD

Reflected Ceiling
Plan

A-3.1

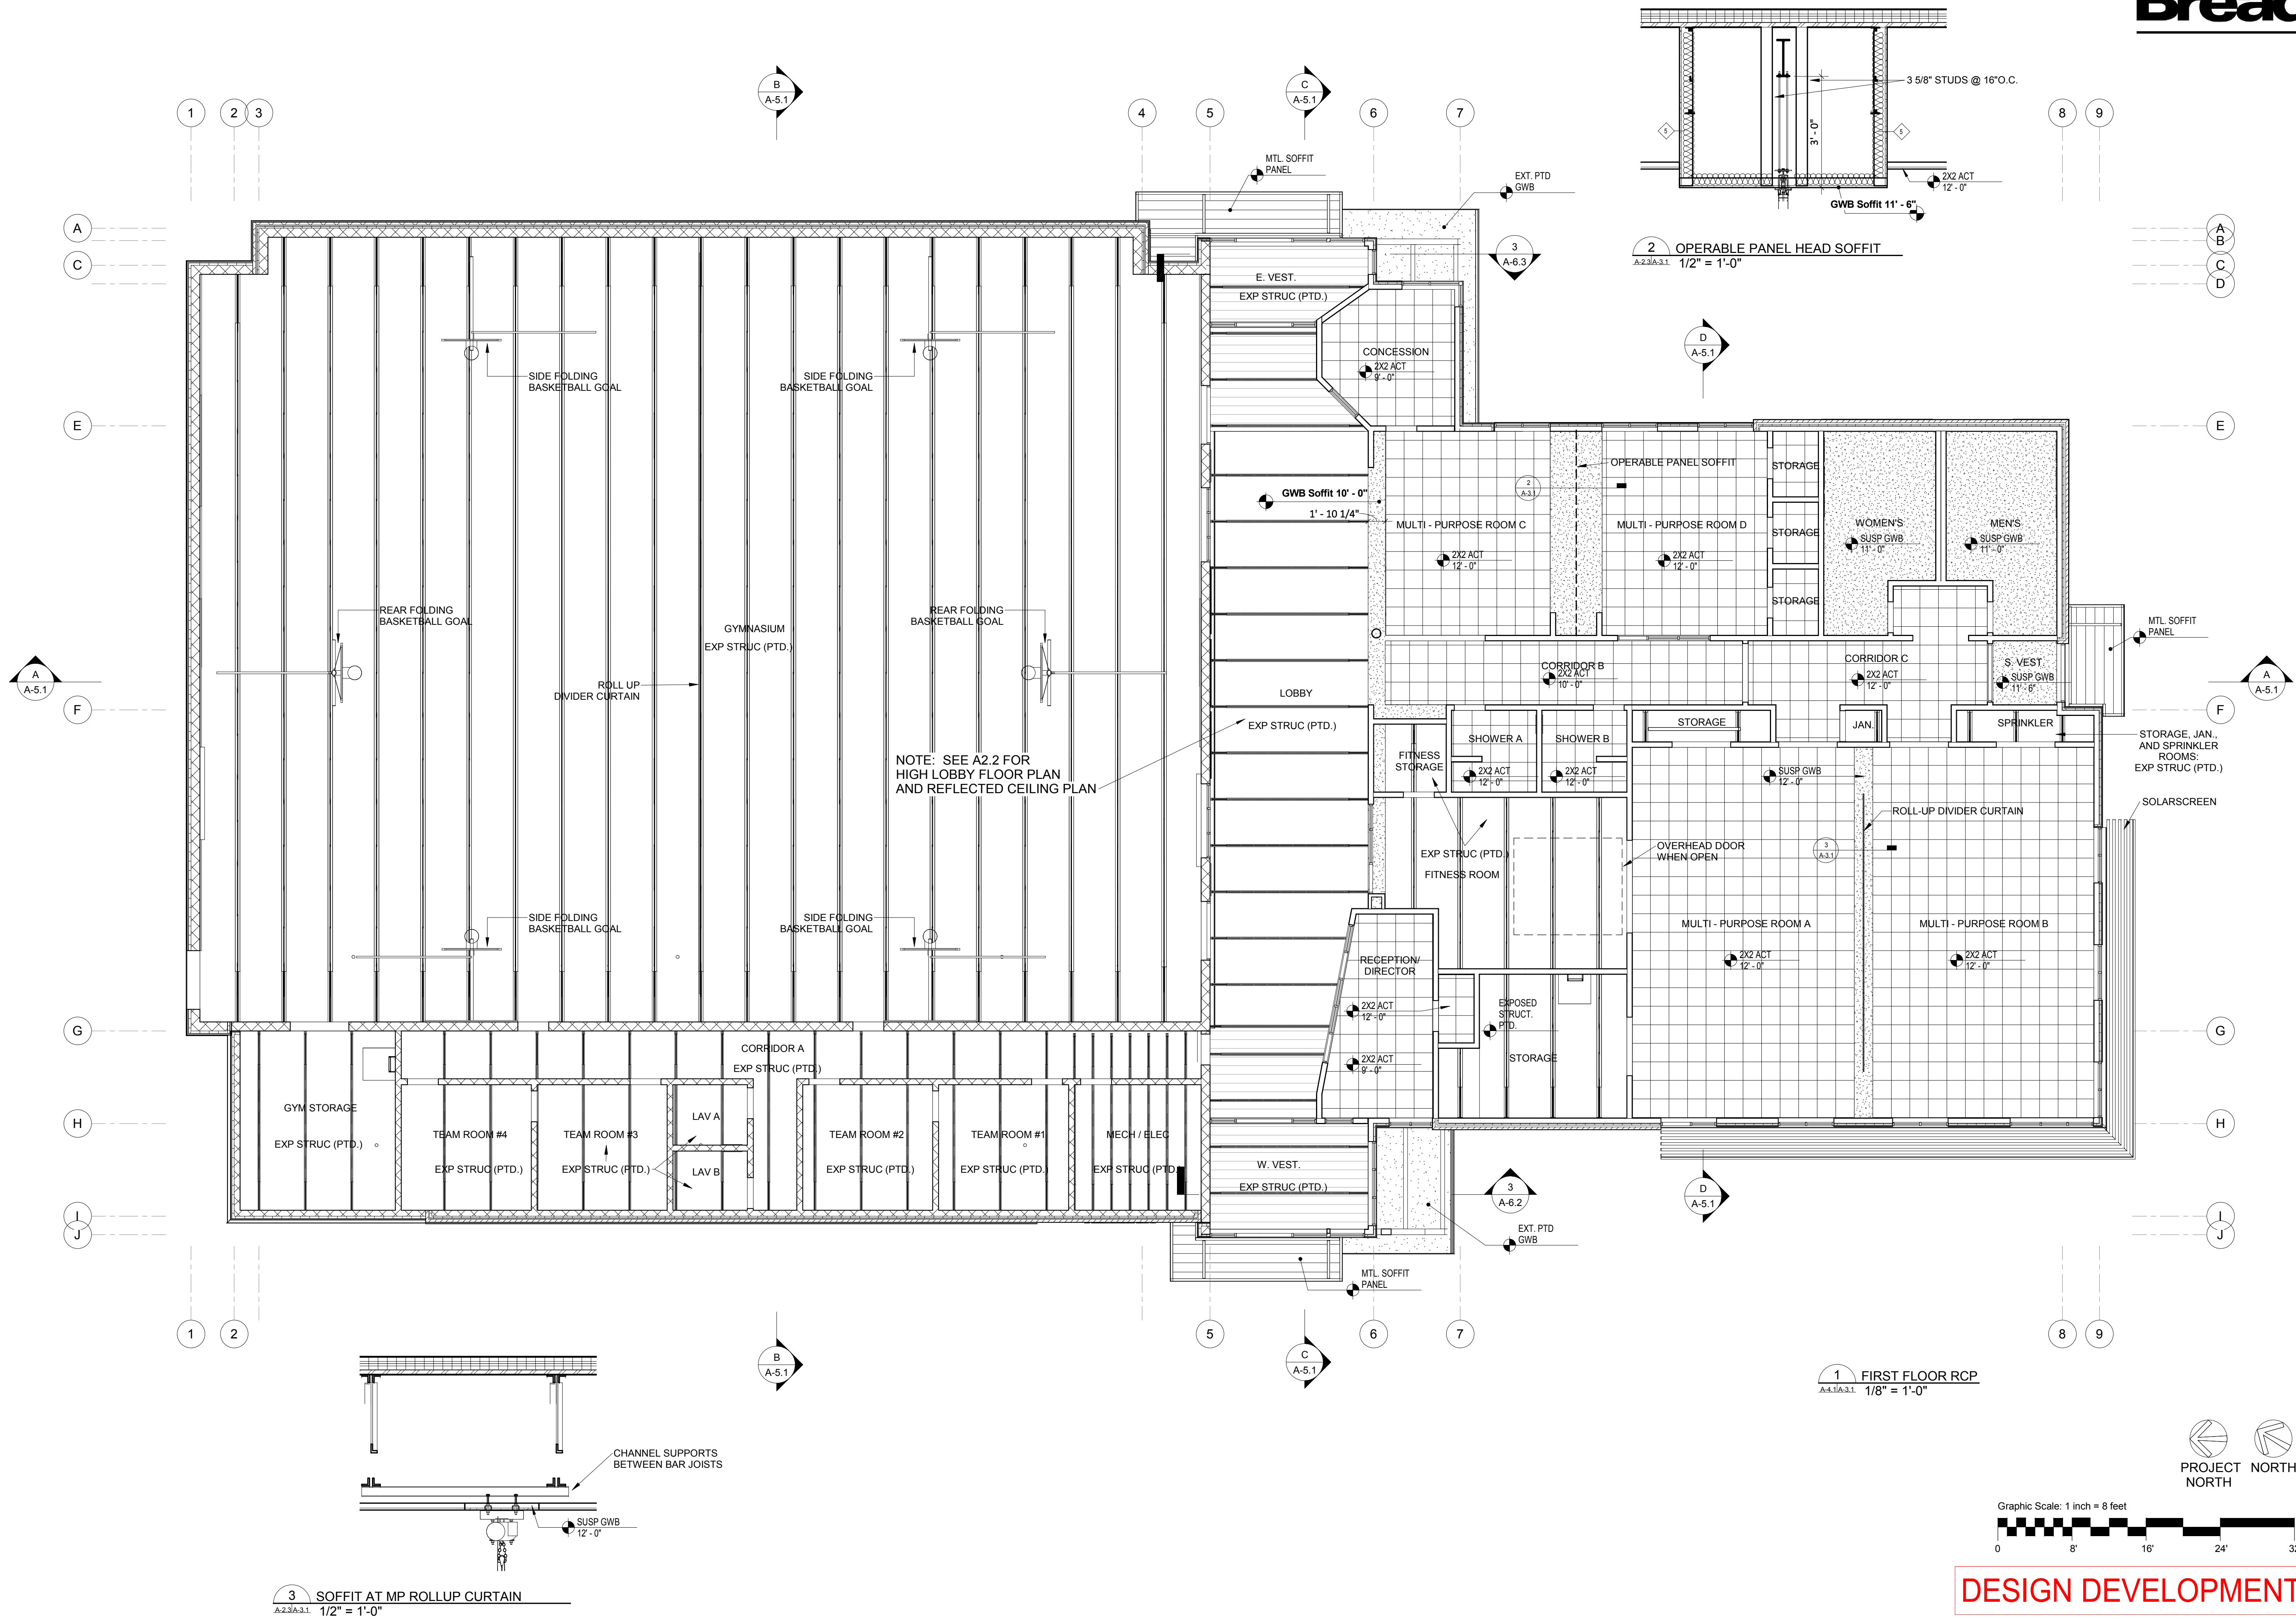

EXTERIOR WALL TYPE LEGEND (SEE SHEET A1.1 FOR DETAILED WALL TYPE INFORMATION)

EW1	12" CMU / GROUND FACE CMU VENEER	EW5	6" LGS STUD / BRICK VENEER
EW2	12" CMU / TYPE 3 HORZ. MTL SIDING	EW5A	6" LGS STUD / GROUND FACE CMU VENEER
EW3	8" CMU / BRICK VENEER	EW6	6" LGS STUD / TYPE 1 HORZ. MTL SIDING
EW3A	8" CMU / GROUND FACE CMU VENEER	EW6A	6" LGS STUD / TYPE 2 VERT. MTL SIDING
EW4	8" CMU / TYPE 1 HORZ. MTL SIDING	EW8	6" LGS STUD / TYPE 4 MTL PANEL
EW4A	8" CMU / TYPE 3 VERT. MTL SIDING	EW7	12" CMU / TYPE 4 MTL PANEL

EXTERIOR WALL AREAS

Type Mark	Area
EW1	1,491 SF
EW2	6,711 SF
EW3	1,031 SF
EW3A	196 SF
EW4	411 SF
EW4A	791 SF
EW5	1,241 SF
EW5A	437 SF
EW6	1,090 SF
EW6A	1,166 SF
EW7	244 SF
EW8	347 SF
	15,158 SF

EXTERIOR METAL SIDING SCHEDULE





Material: Description	Material: Area
TYPE 1 PTD HORZ. MTL. SIDING	1,435 SF
TYPE 2 PTD VERT. MTL. SIDING	1,962 SF
TYPE 3 PTD HORZ. MTL. SIDING	6,710 SF
TYPE 4 FLUSH MTL. PANEL	593 SF
TYPE 1 PTD HORZ. MTL. SIDING	8 SF
Total Metal Siding	10,707 SF

EXTERIOR MASONRY VENEER SCHEDULE

Material: Description	Material: Area
3 5/8" BRICK VENEER	2,283 SF
4 x 8 x 16 GROUND FACE CMU	2,125 SF
Total Masonry Veneer	4,407 SF




METAL SOFFIT PANEL SCHEDULE

Material: Description	Material: Area
TYPE 5 PTD MTL SOFFIT PANEL	240 SF
Total Metal Soffit	240 SF

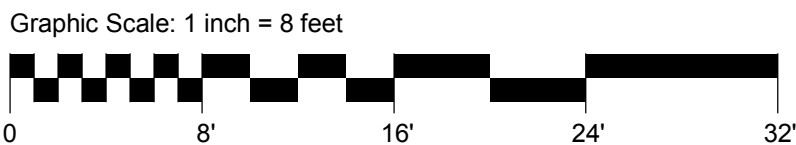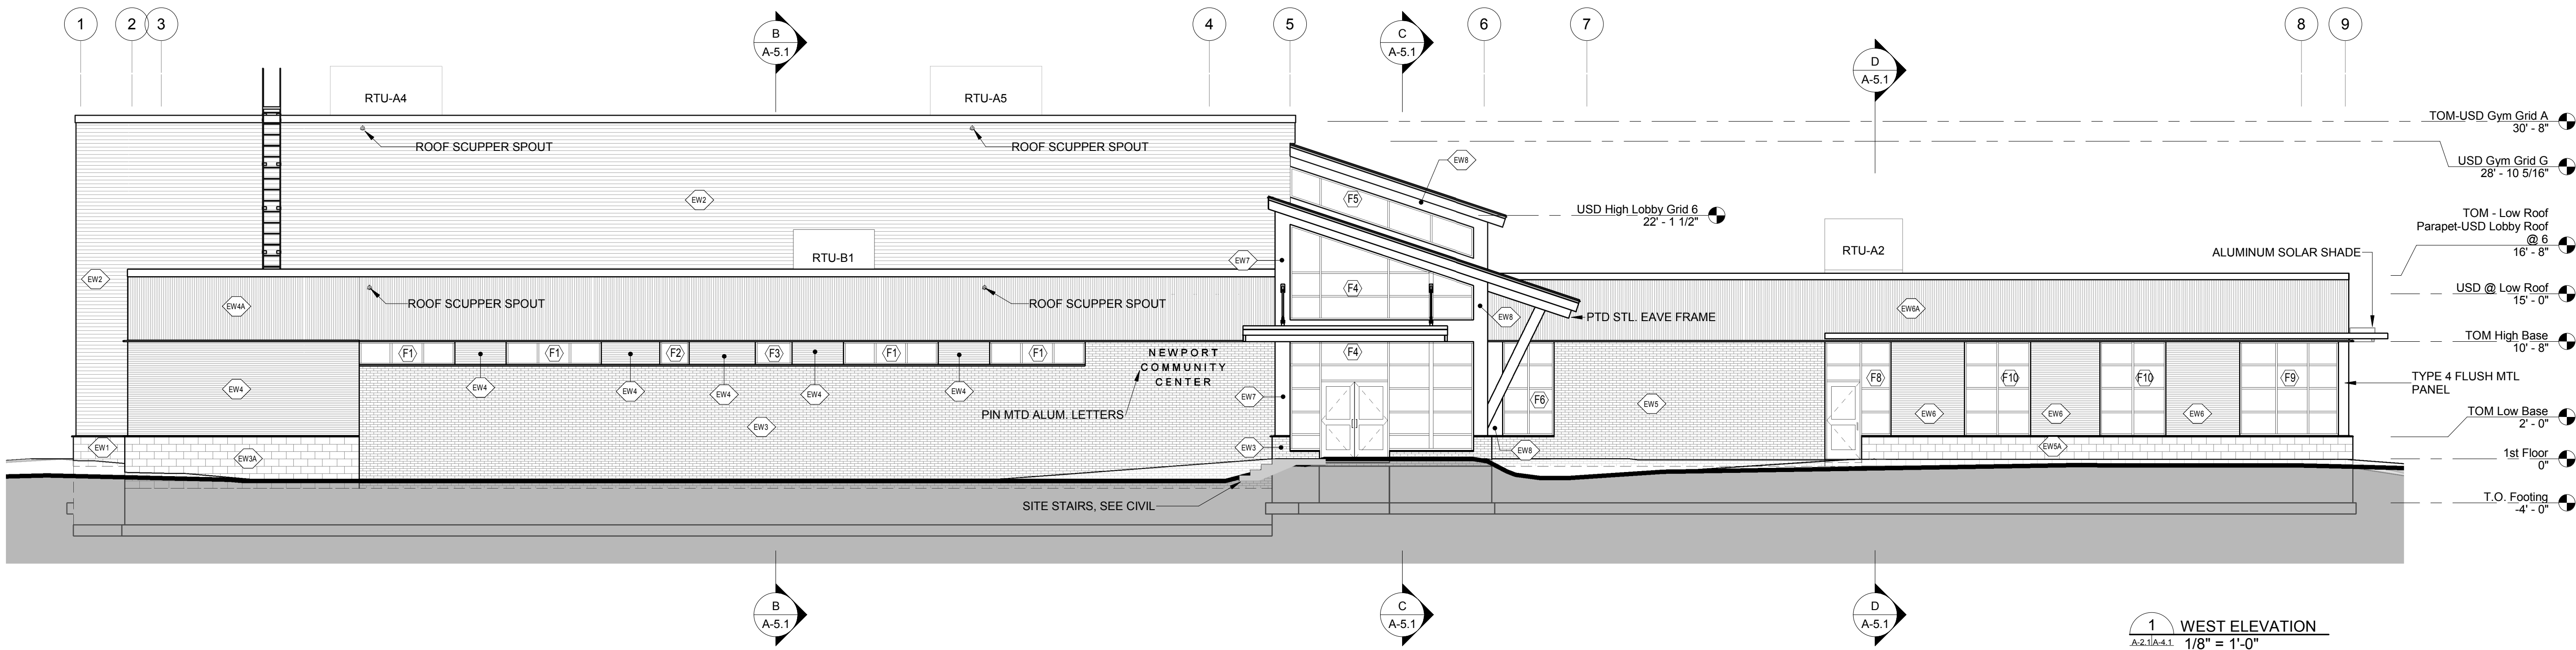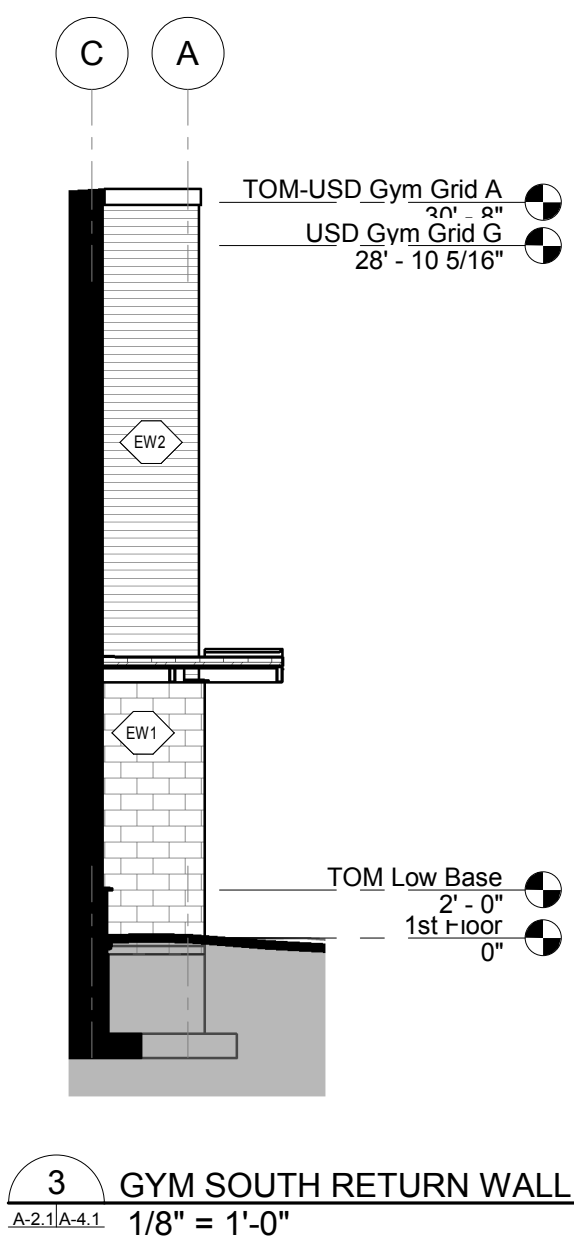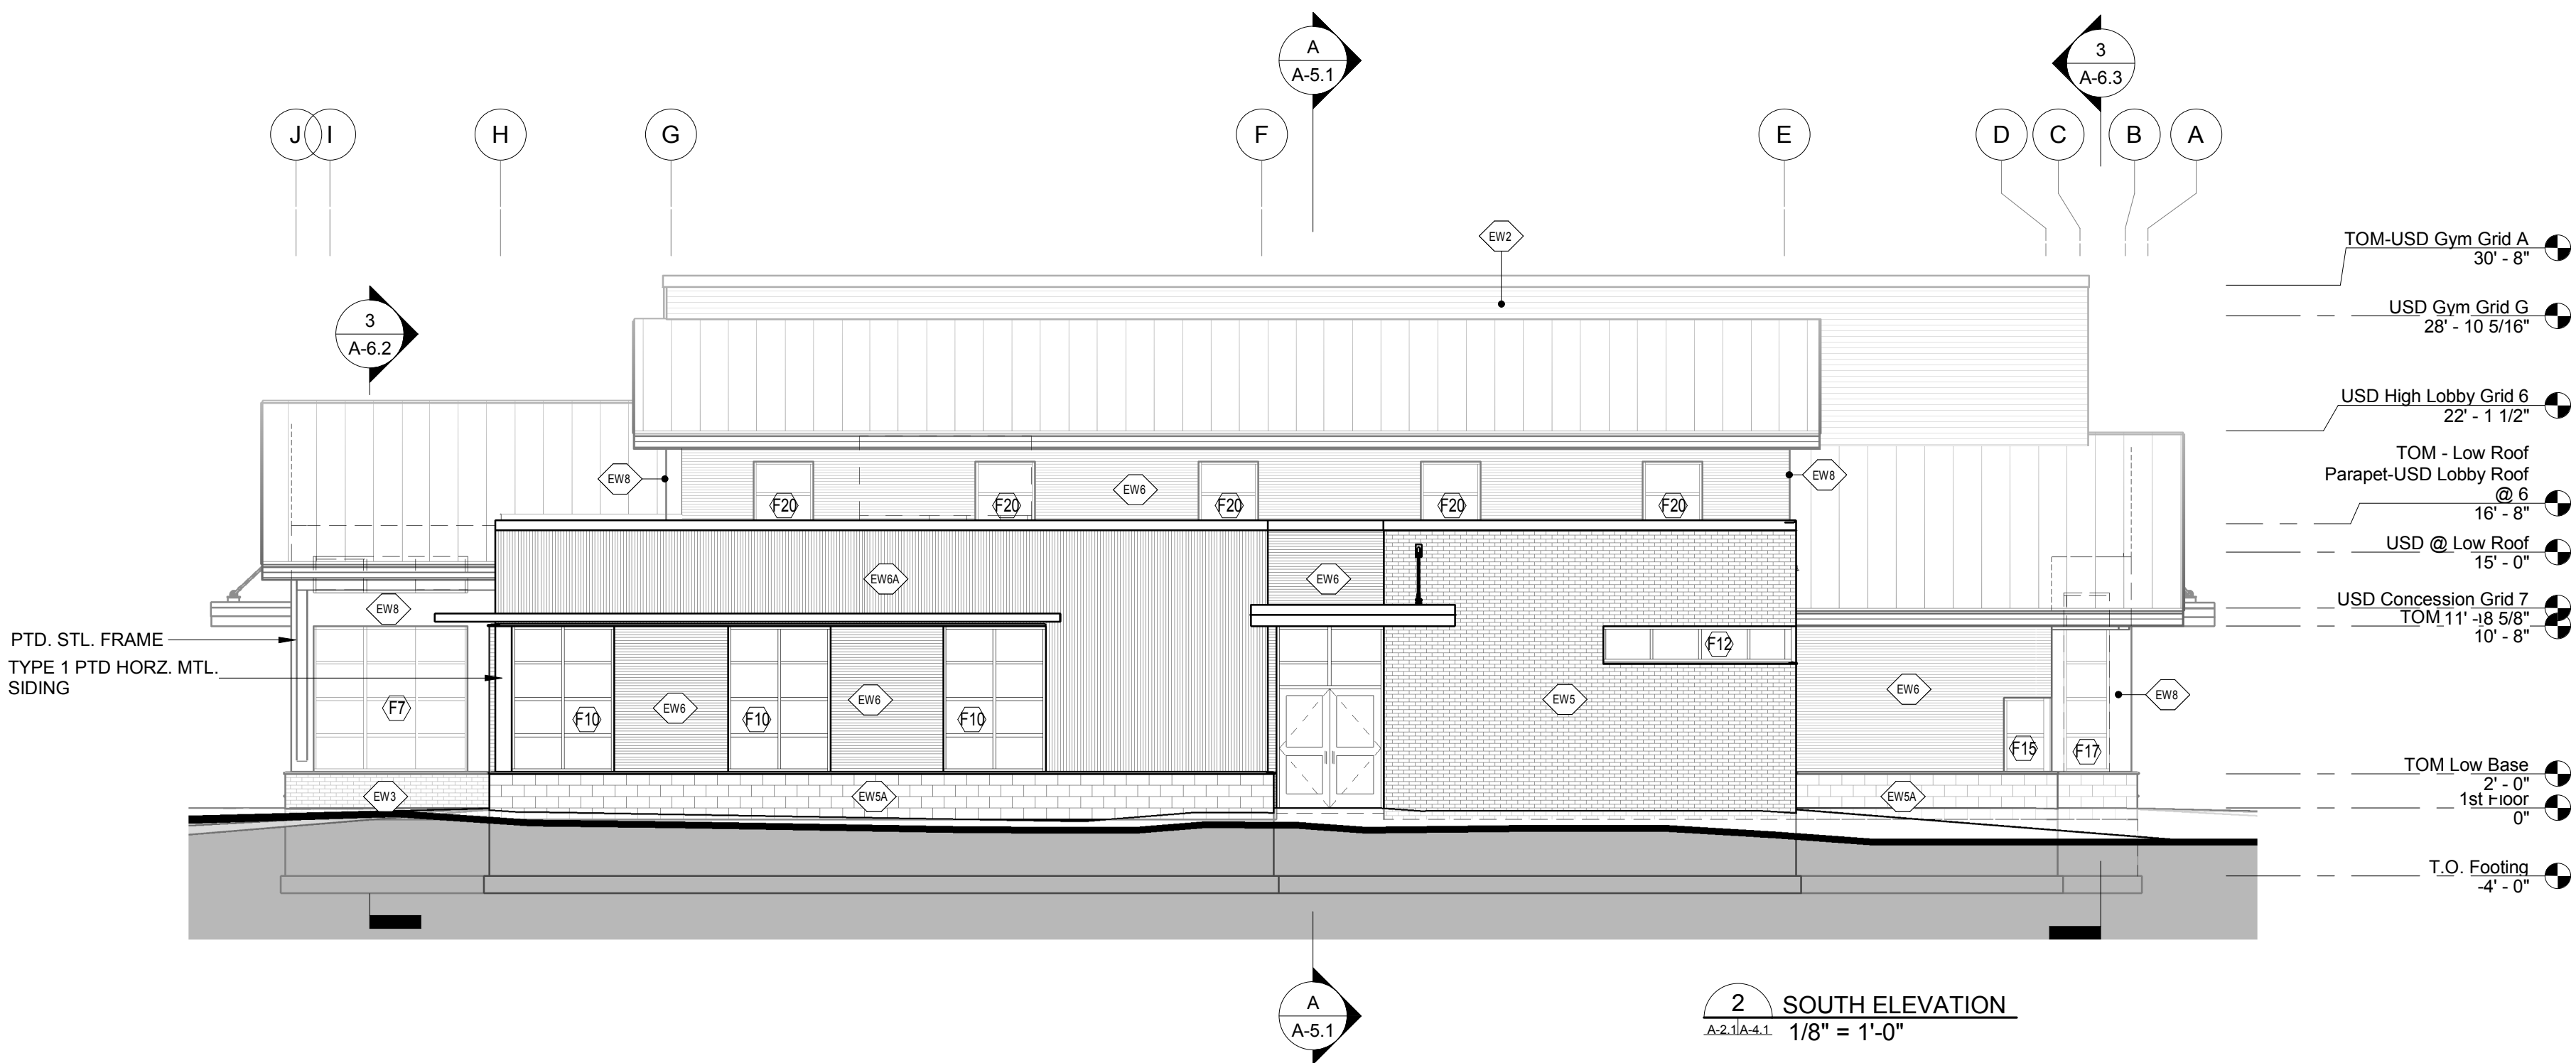

DESIGN DEVELOPMENT

EXTERIOR WALL TYPE LEGEND (SEE SHEET A1.1 FOR DETAILED WALL TYPE INFORMATION)			
EW1	12" CMU / GROUND FACE CMU VENEER	EW5	6" LGS STUD / BRICK VENEER
EW2	12" CMU / TYPE 3 HORZ. MTL SIDING	EW5A	6" LGS STUD / GROUND FACE CMU VENEER
EW3	8" CMU / BRICK VENEER	EW6	6" LGS STUD / TYPE 1 HORZ. MTL SIDING
EW3A	8" CMU / GROUND FACE CMU VENEER	EW6A	6" LGS STUD / TYPE 2 VERT. MTL SIDING
EW4	8" CMU / TYPE 1 HORZ. MTL SIDING	EW8	6" LGS STUD / TYPE 4 MTL PANEL
EW4A	8" CMU / TYPE 3 VERT. MTL SIDING	EW7	12" CMU / TYPE 4 MTL PANEL

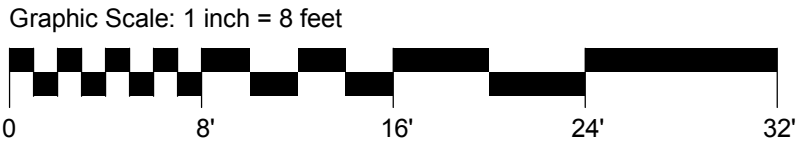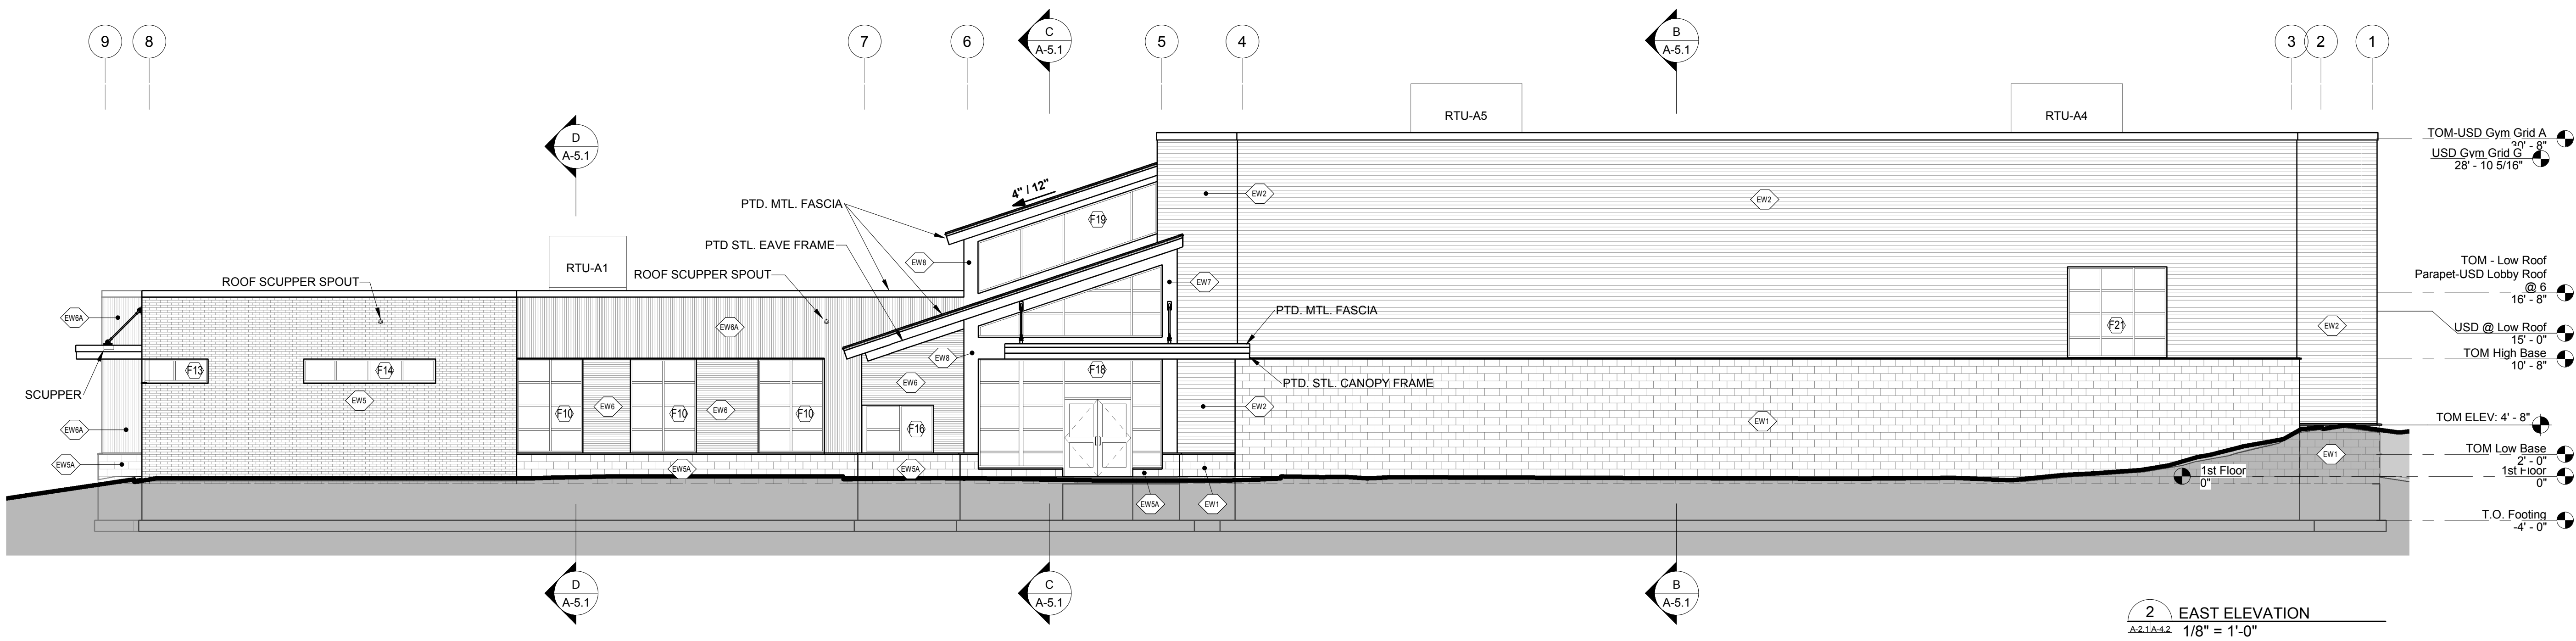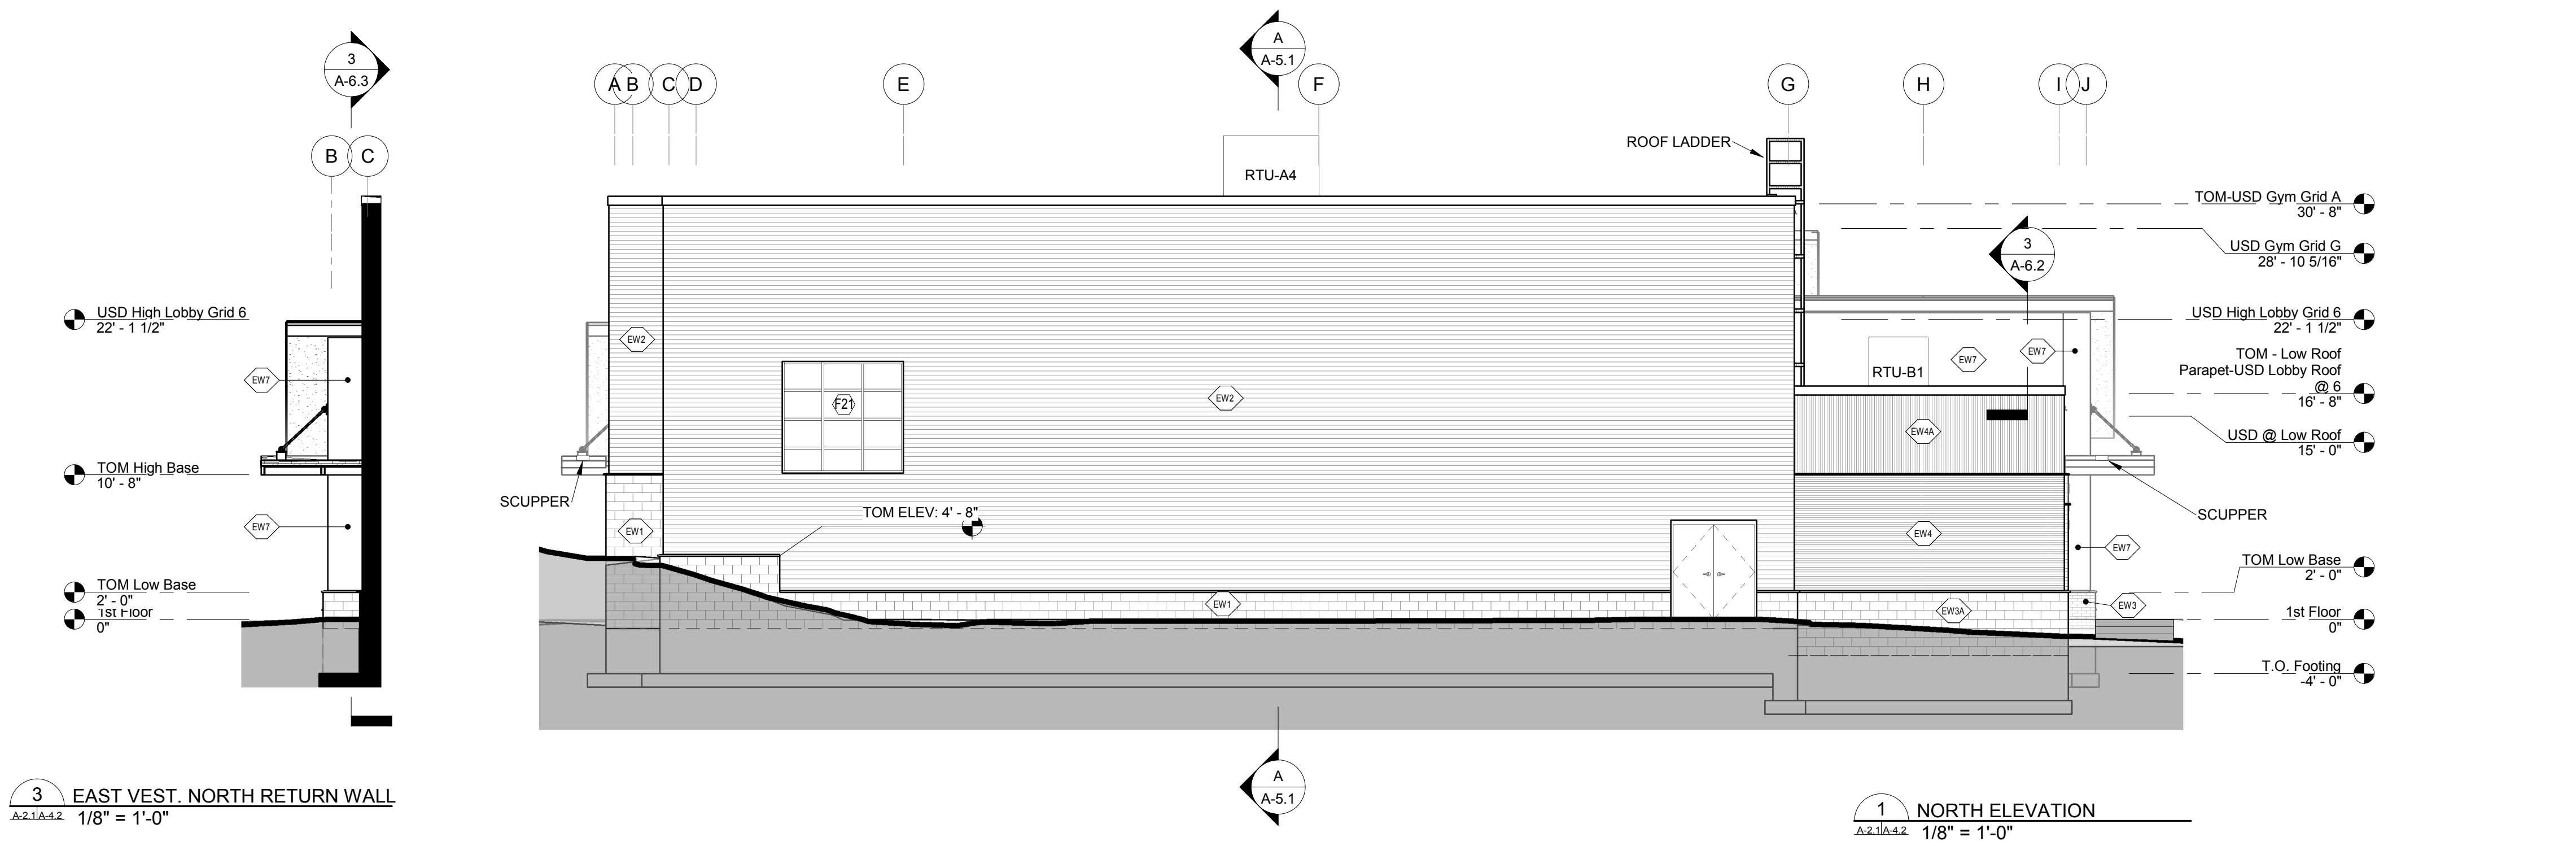

DESIGN DEVELOPMENT

NEWPORT
COMMUNITY CENTER

NEWPORT, NH

Proj. No: 18412 Drawn: SR
Date: 12/20/2018 Chk'd: JD
North and East
Bldg. Elevations

A-4.2






Revised		
No.	Date	Description

NEWPORT
COMMUNITY CENTER

NEWPORT, NH

Proj. No: 18412 Drawn: SR
Date: 12/20/2018 Chk'd: JD
Building Sections

A-5.1

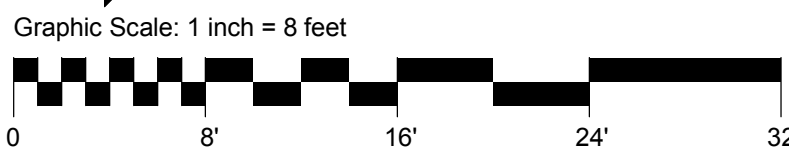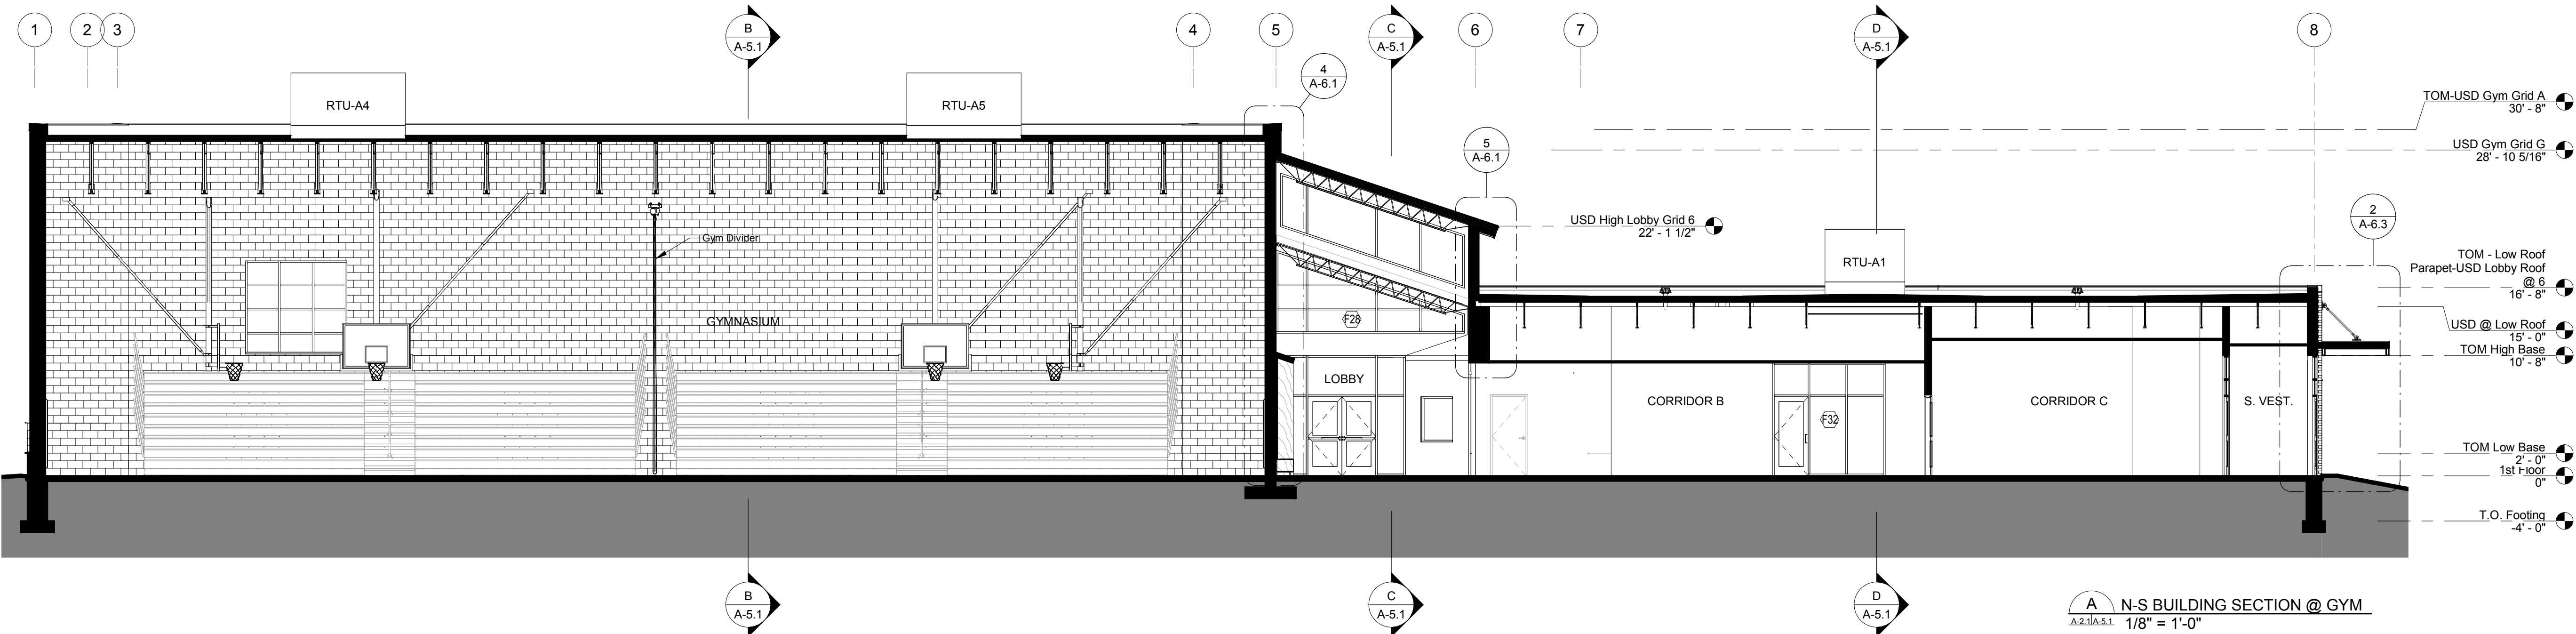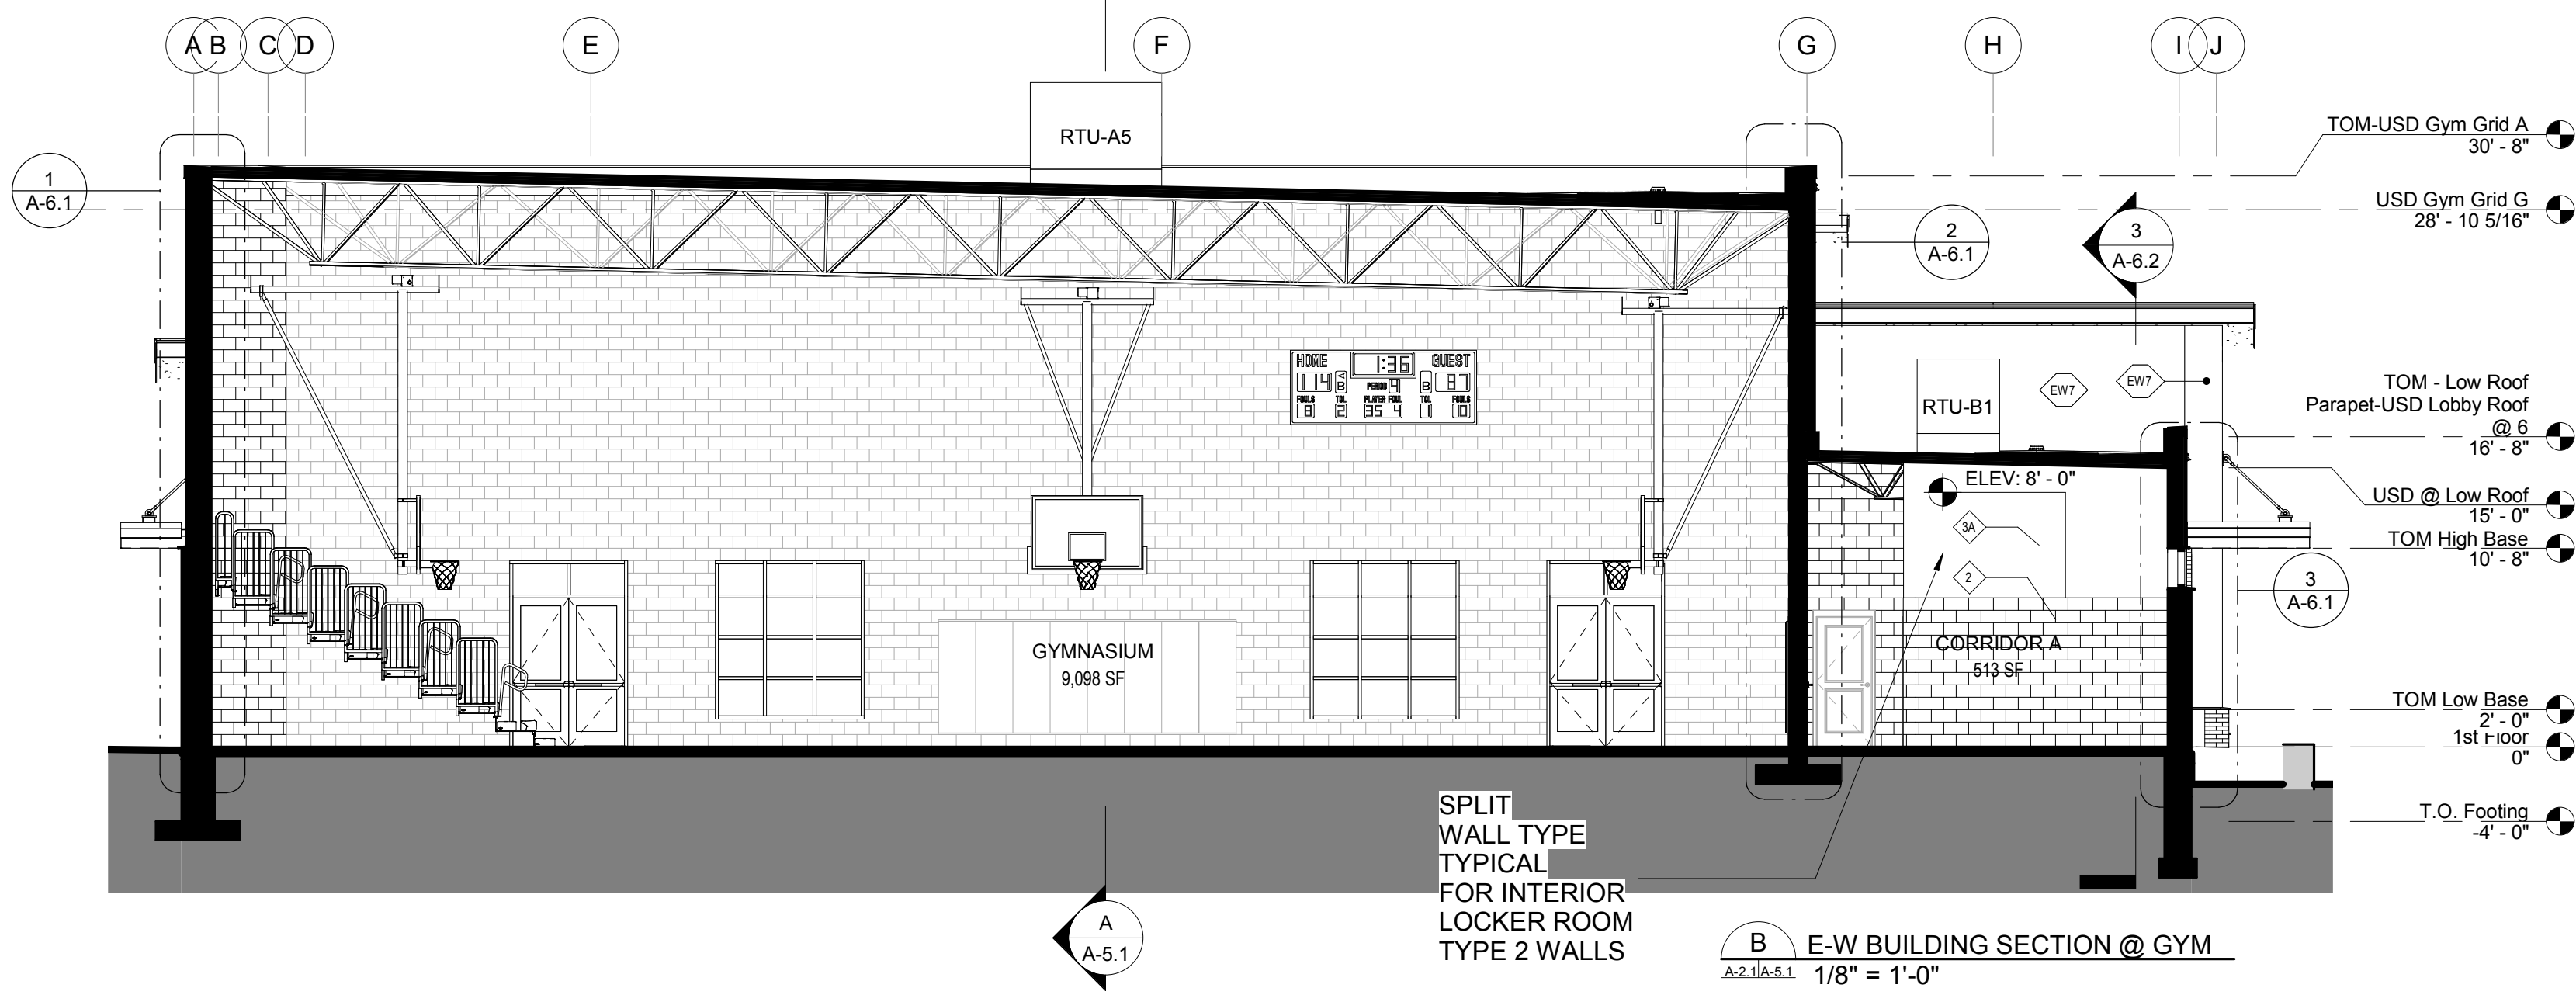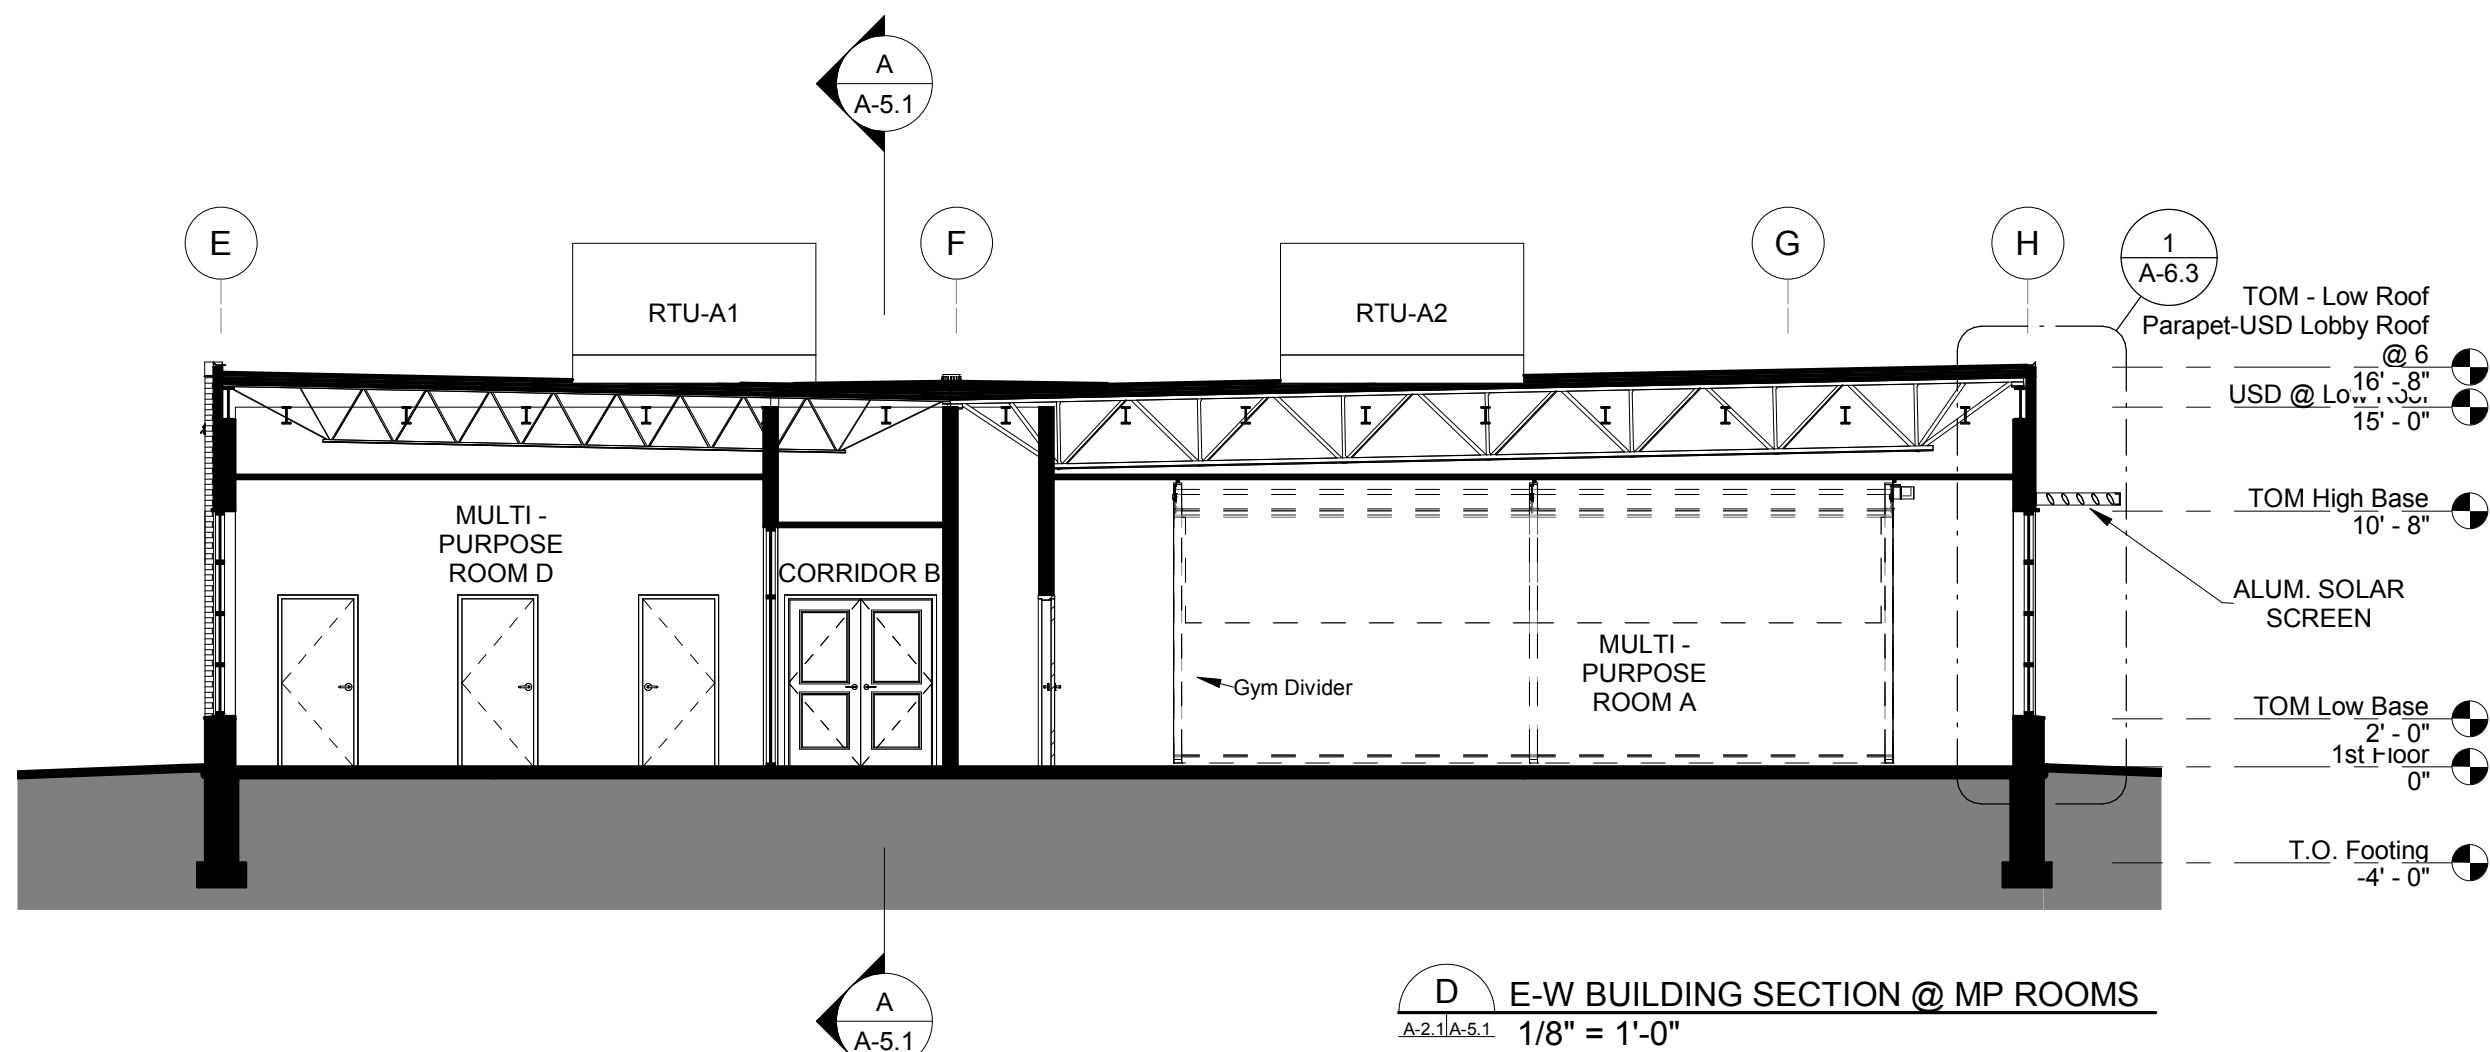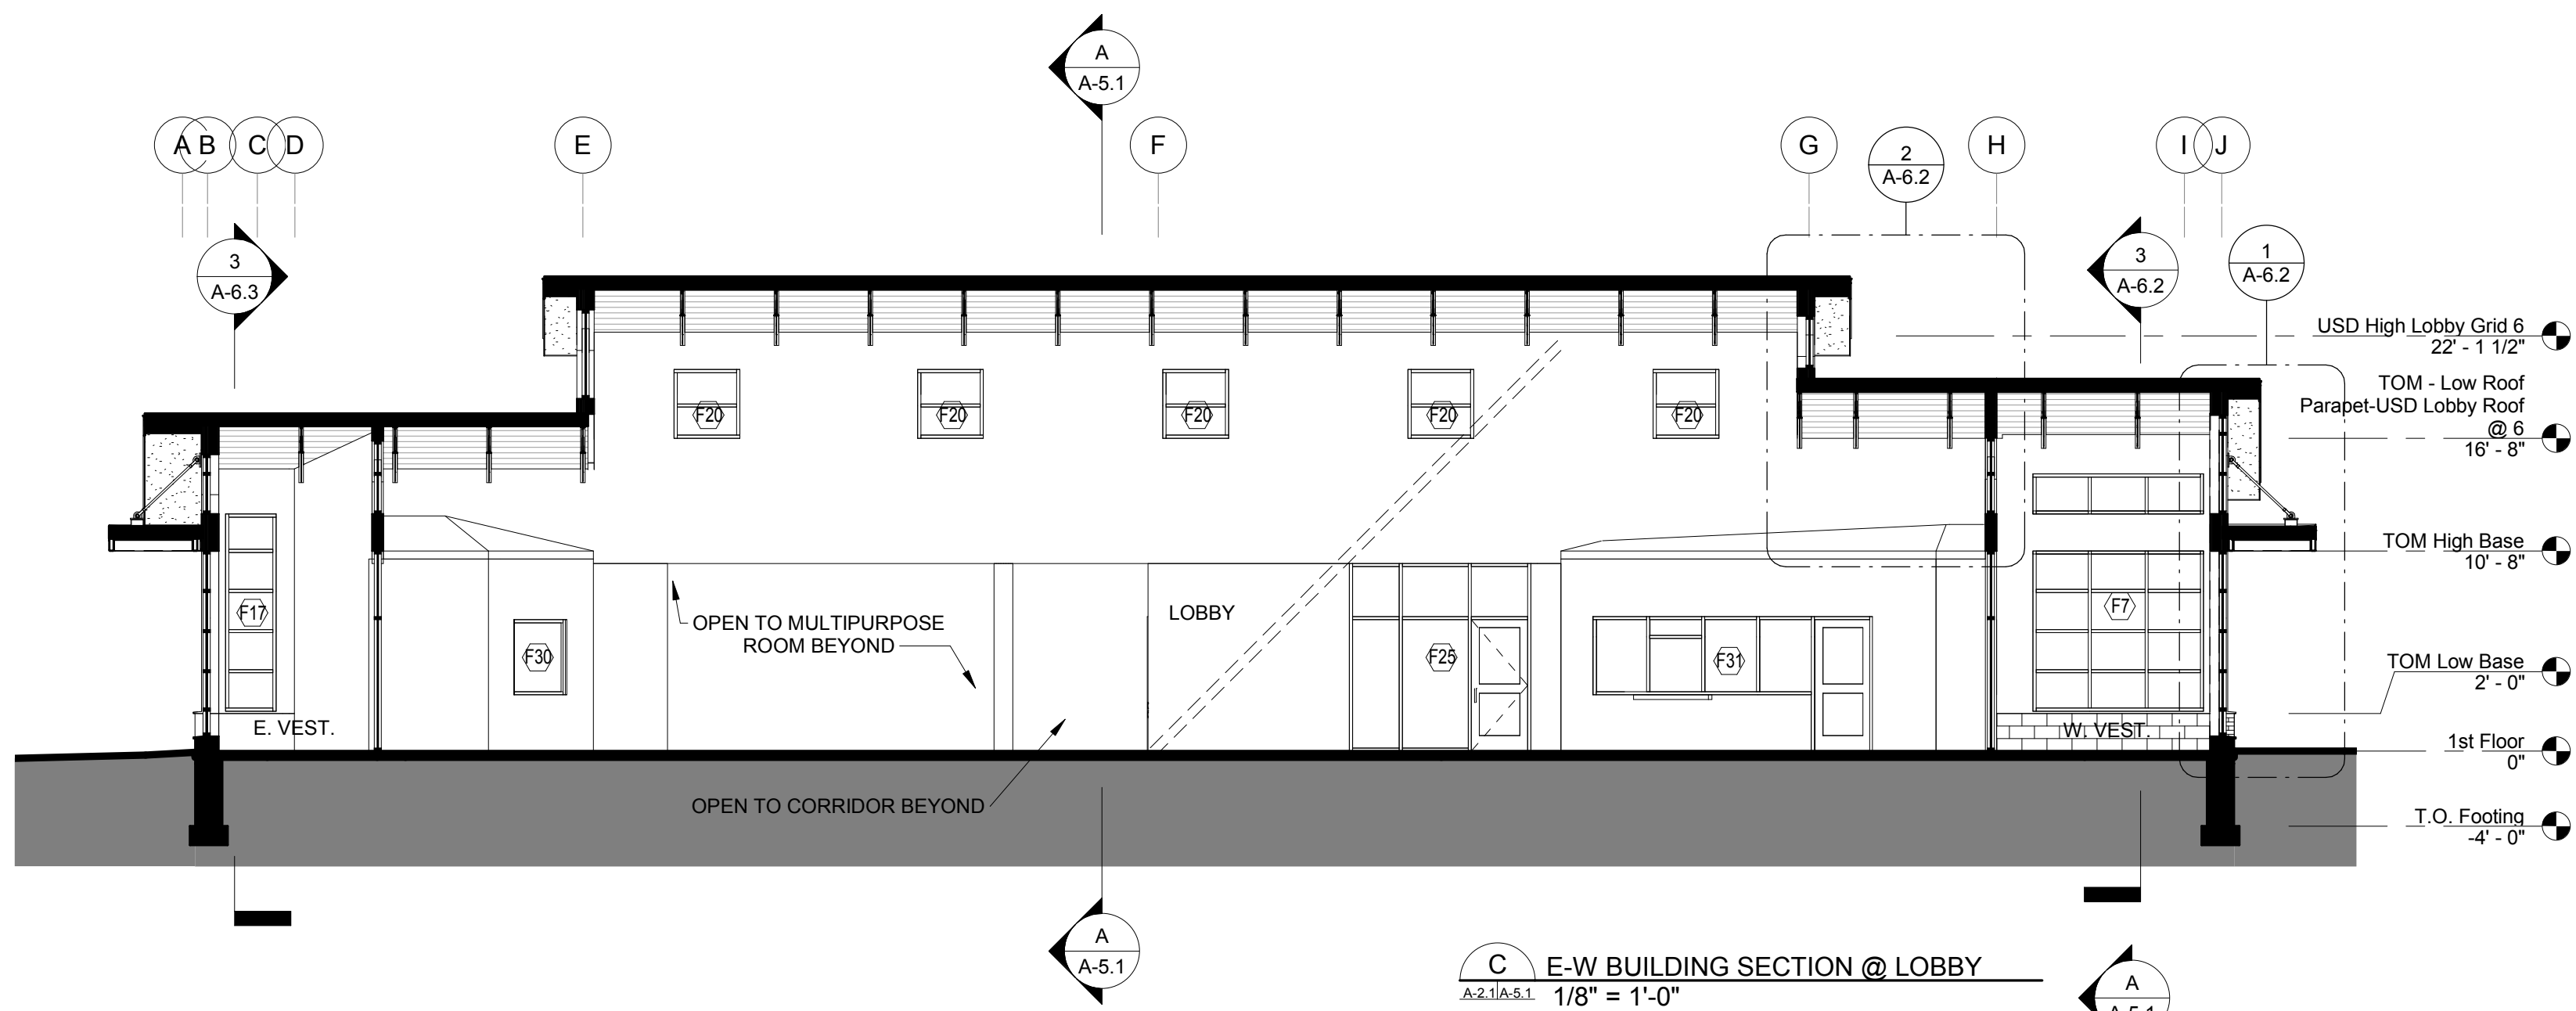

DESIGN DEVELOPMENT

Revised		
No.	Date	Description


NEWPORT
COMMUNITY CENTER

NEWPORT, NH


Proj. No: 18412 Drawn: SR
Date: 12/20/2018 Chk'd: JD

Exterior Wall
Sections


A-6.2

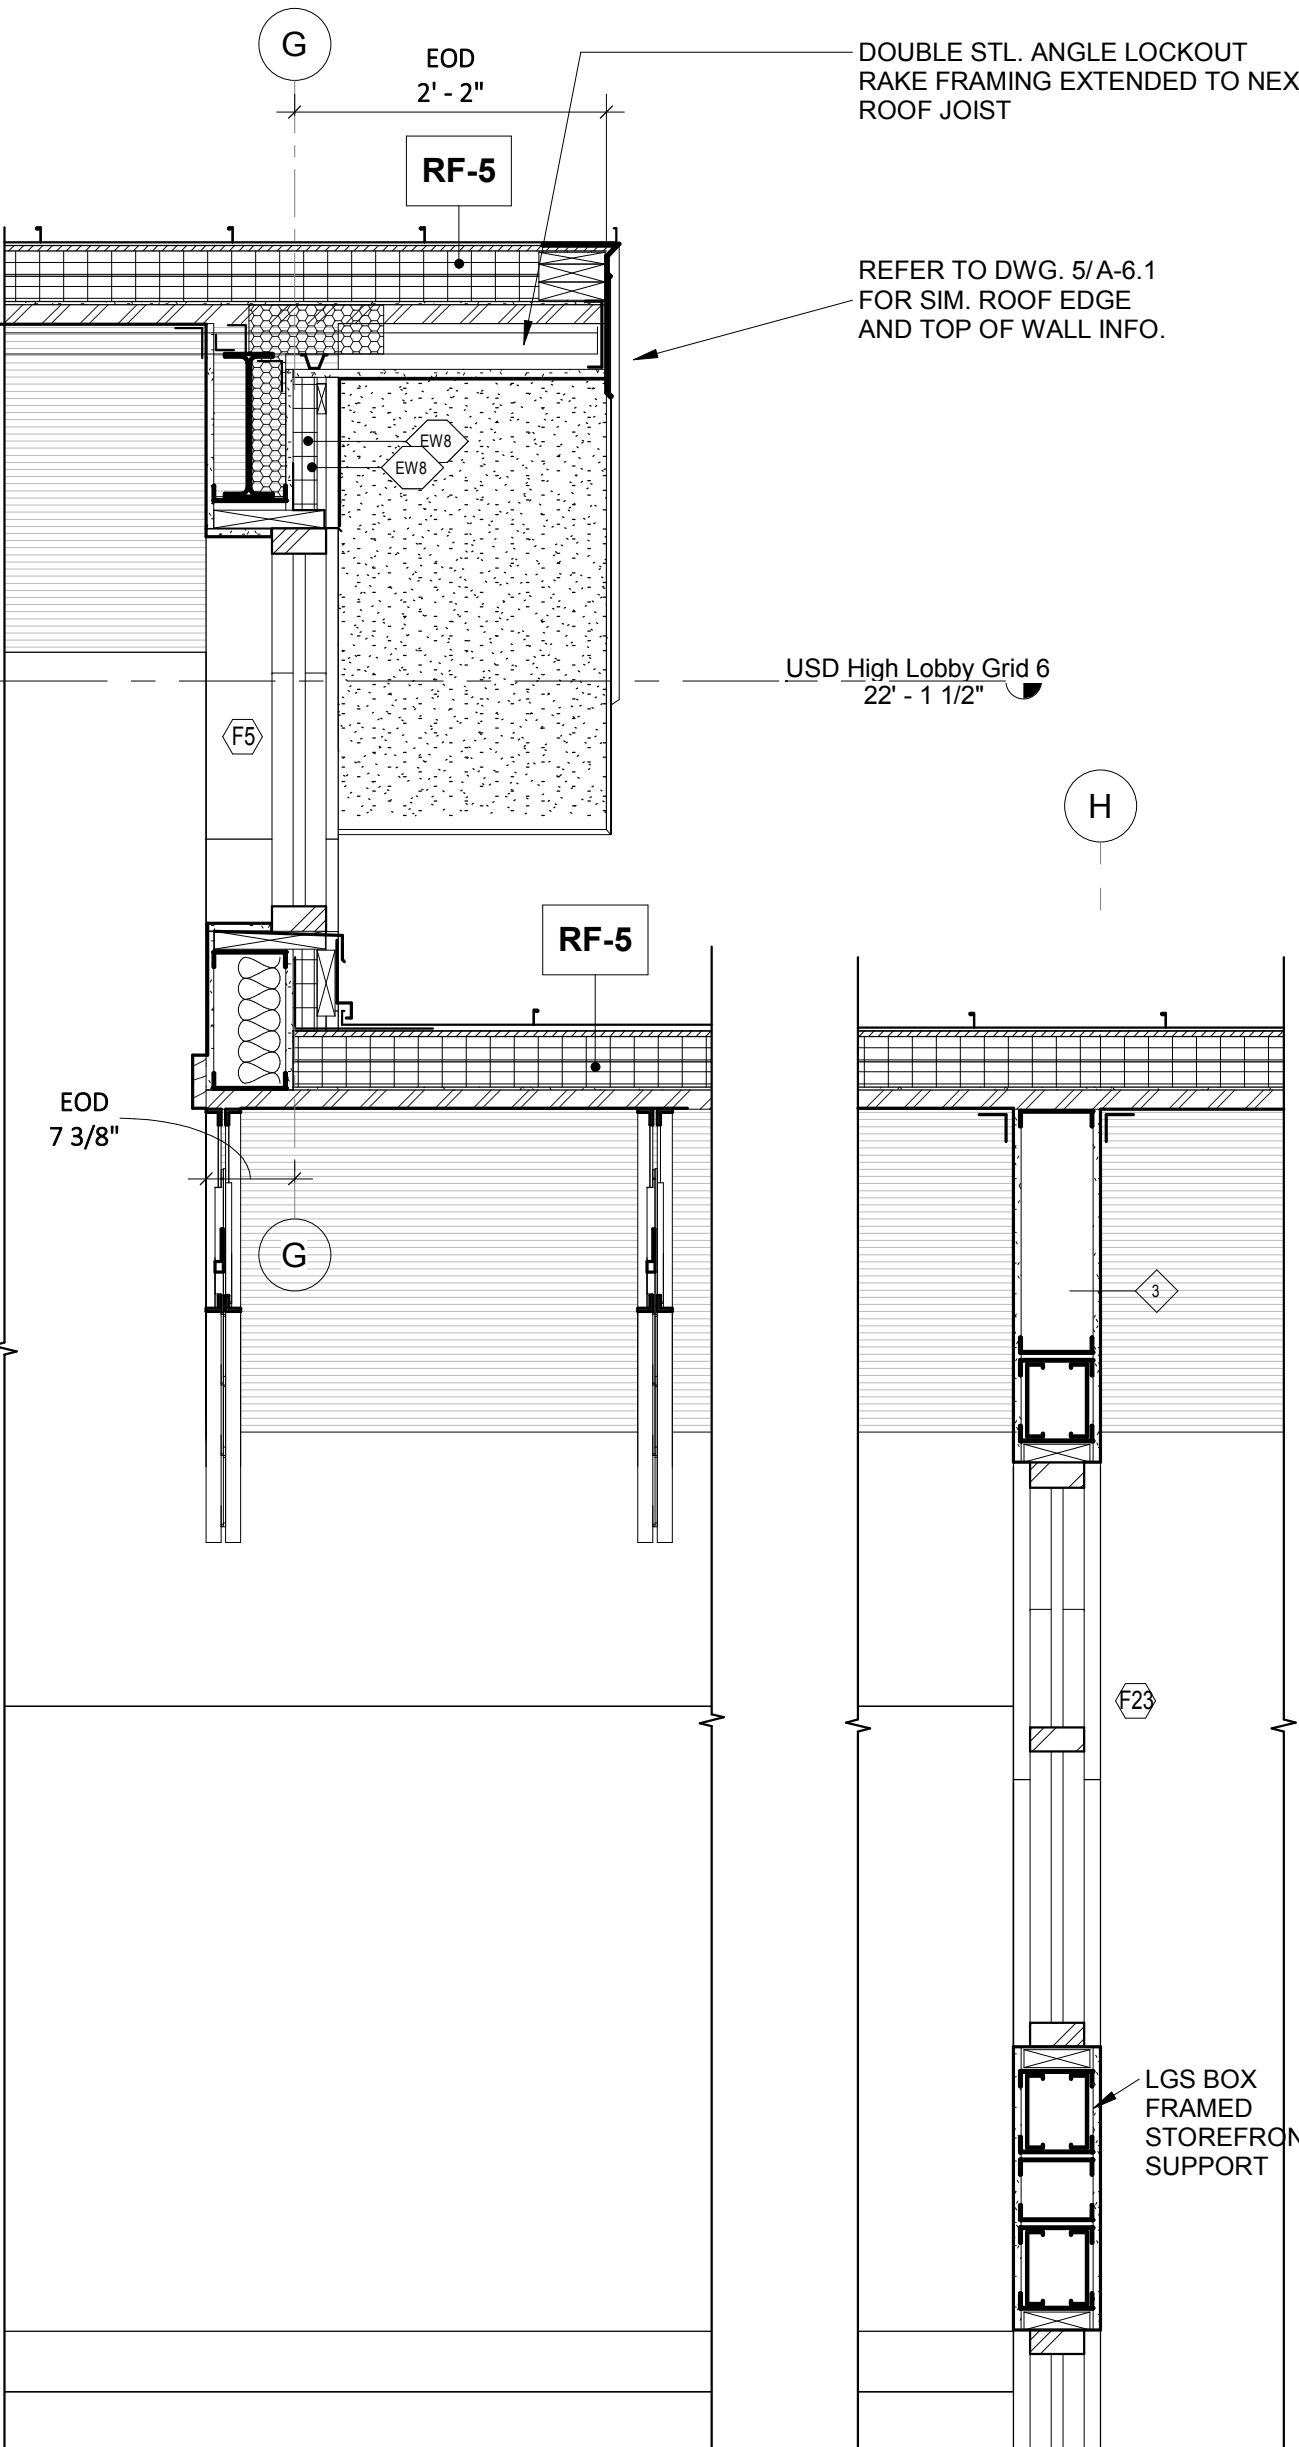

2 WALL SECTION @ WEST END OF HIGH LOBBY ROOF
A-5.1/A-6.2 3/4" = 1'-0"

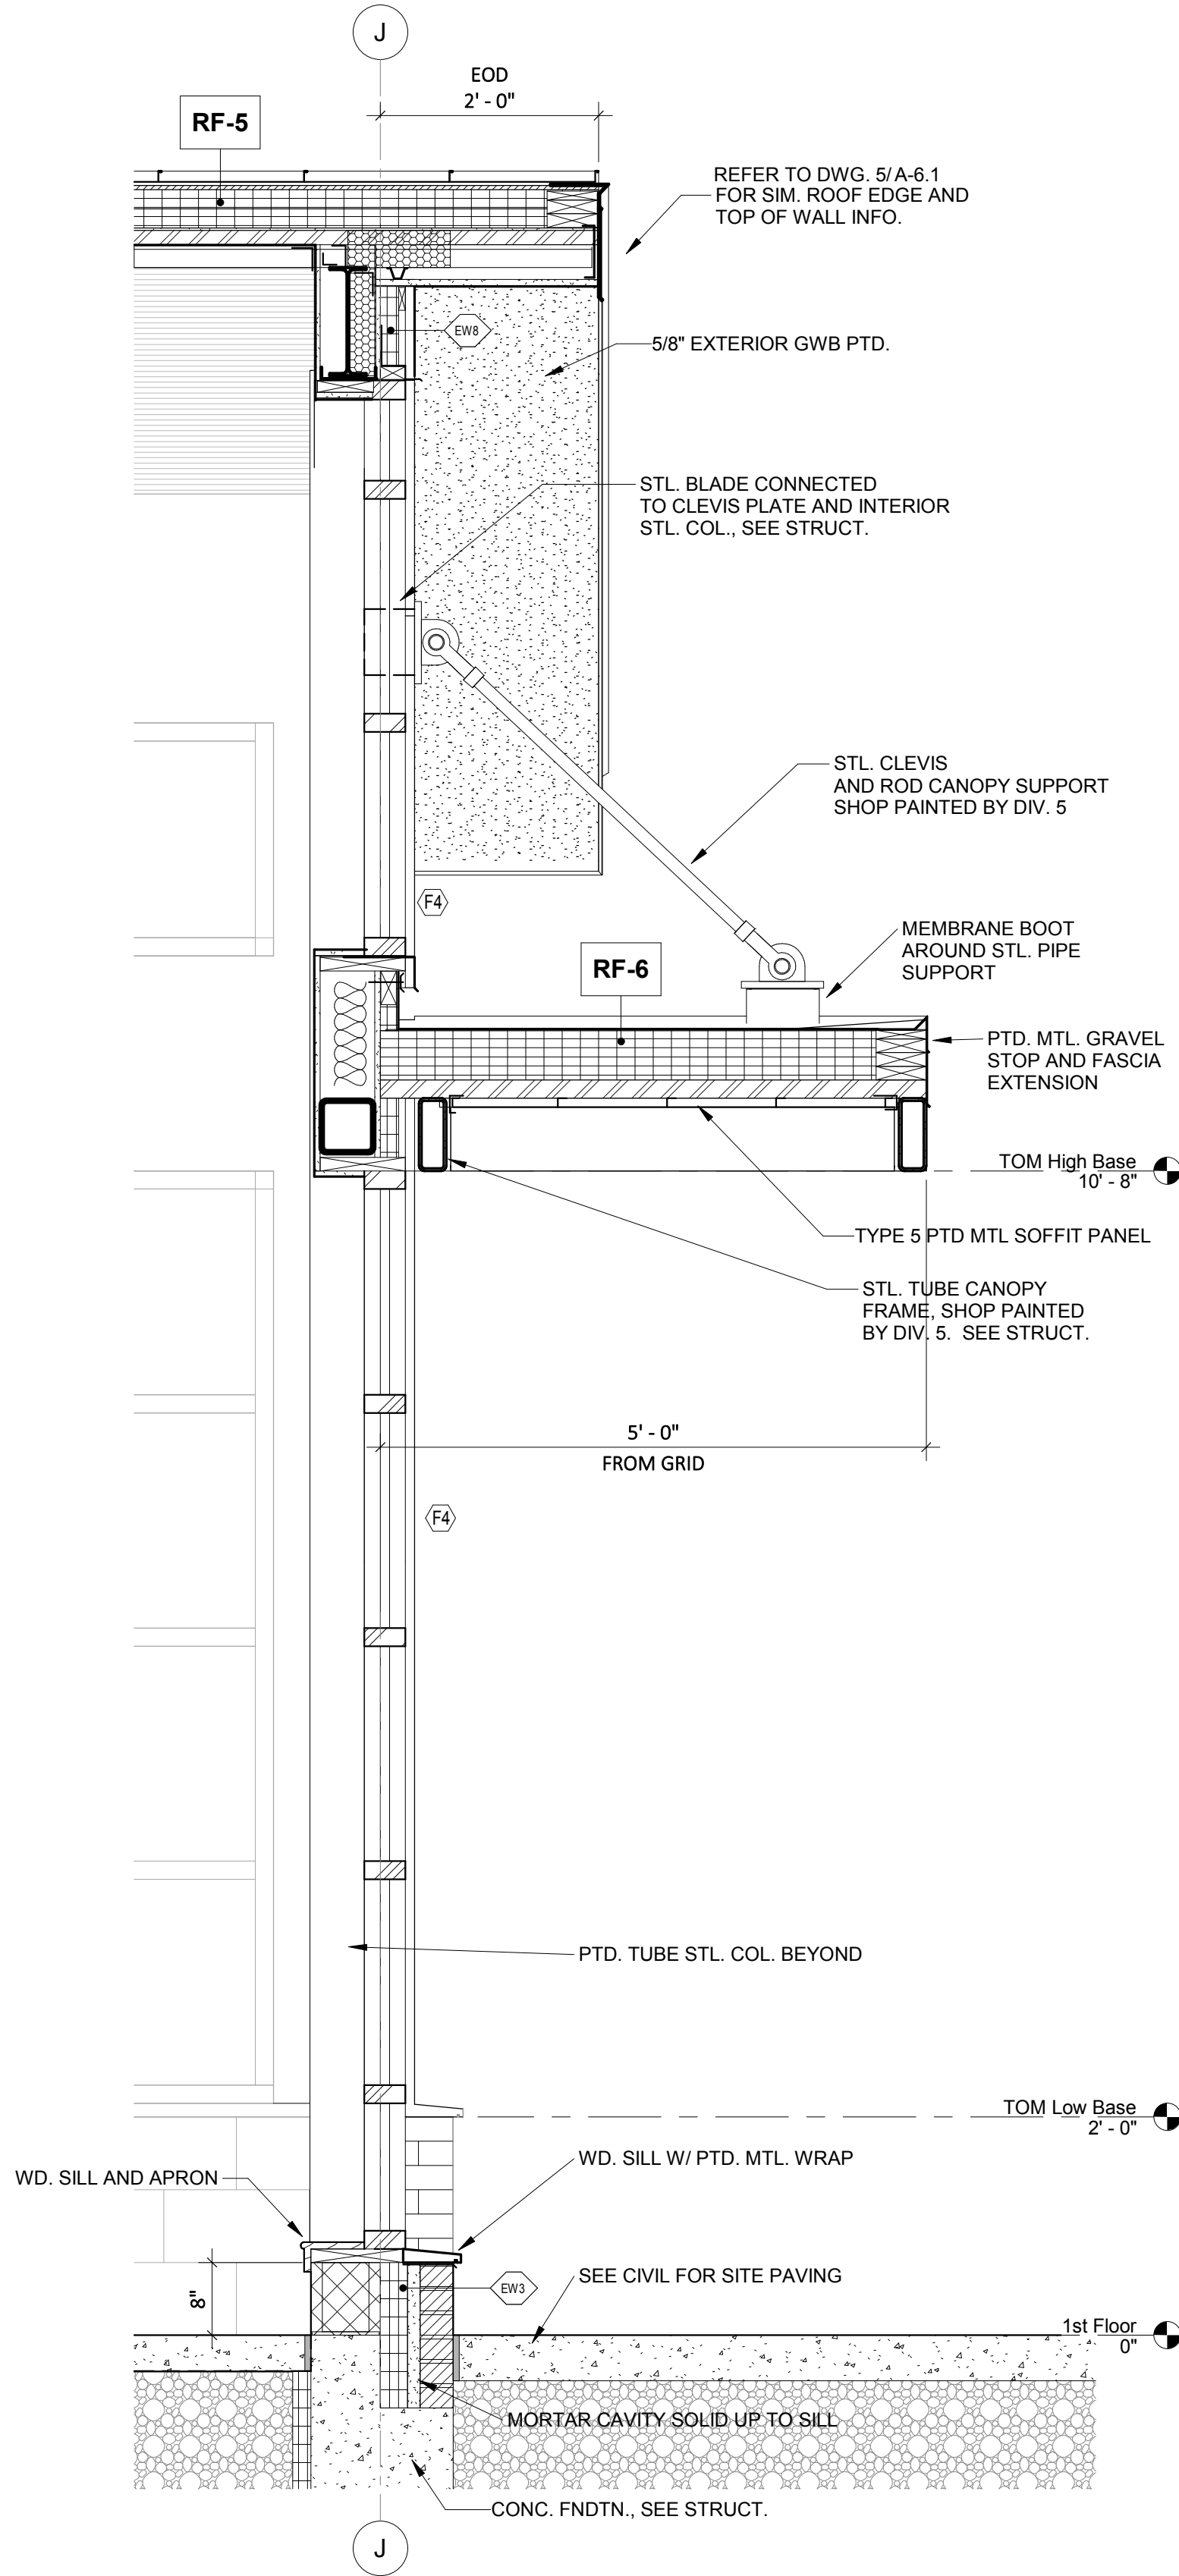

1 WALL SECTION @ WEST VESTIBULE CANOPY
A-5.1/A-6.2 3/4" = 1'-0"

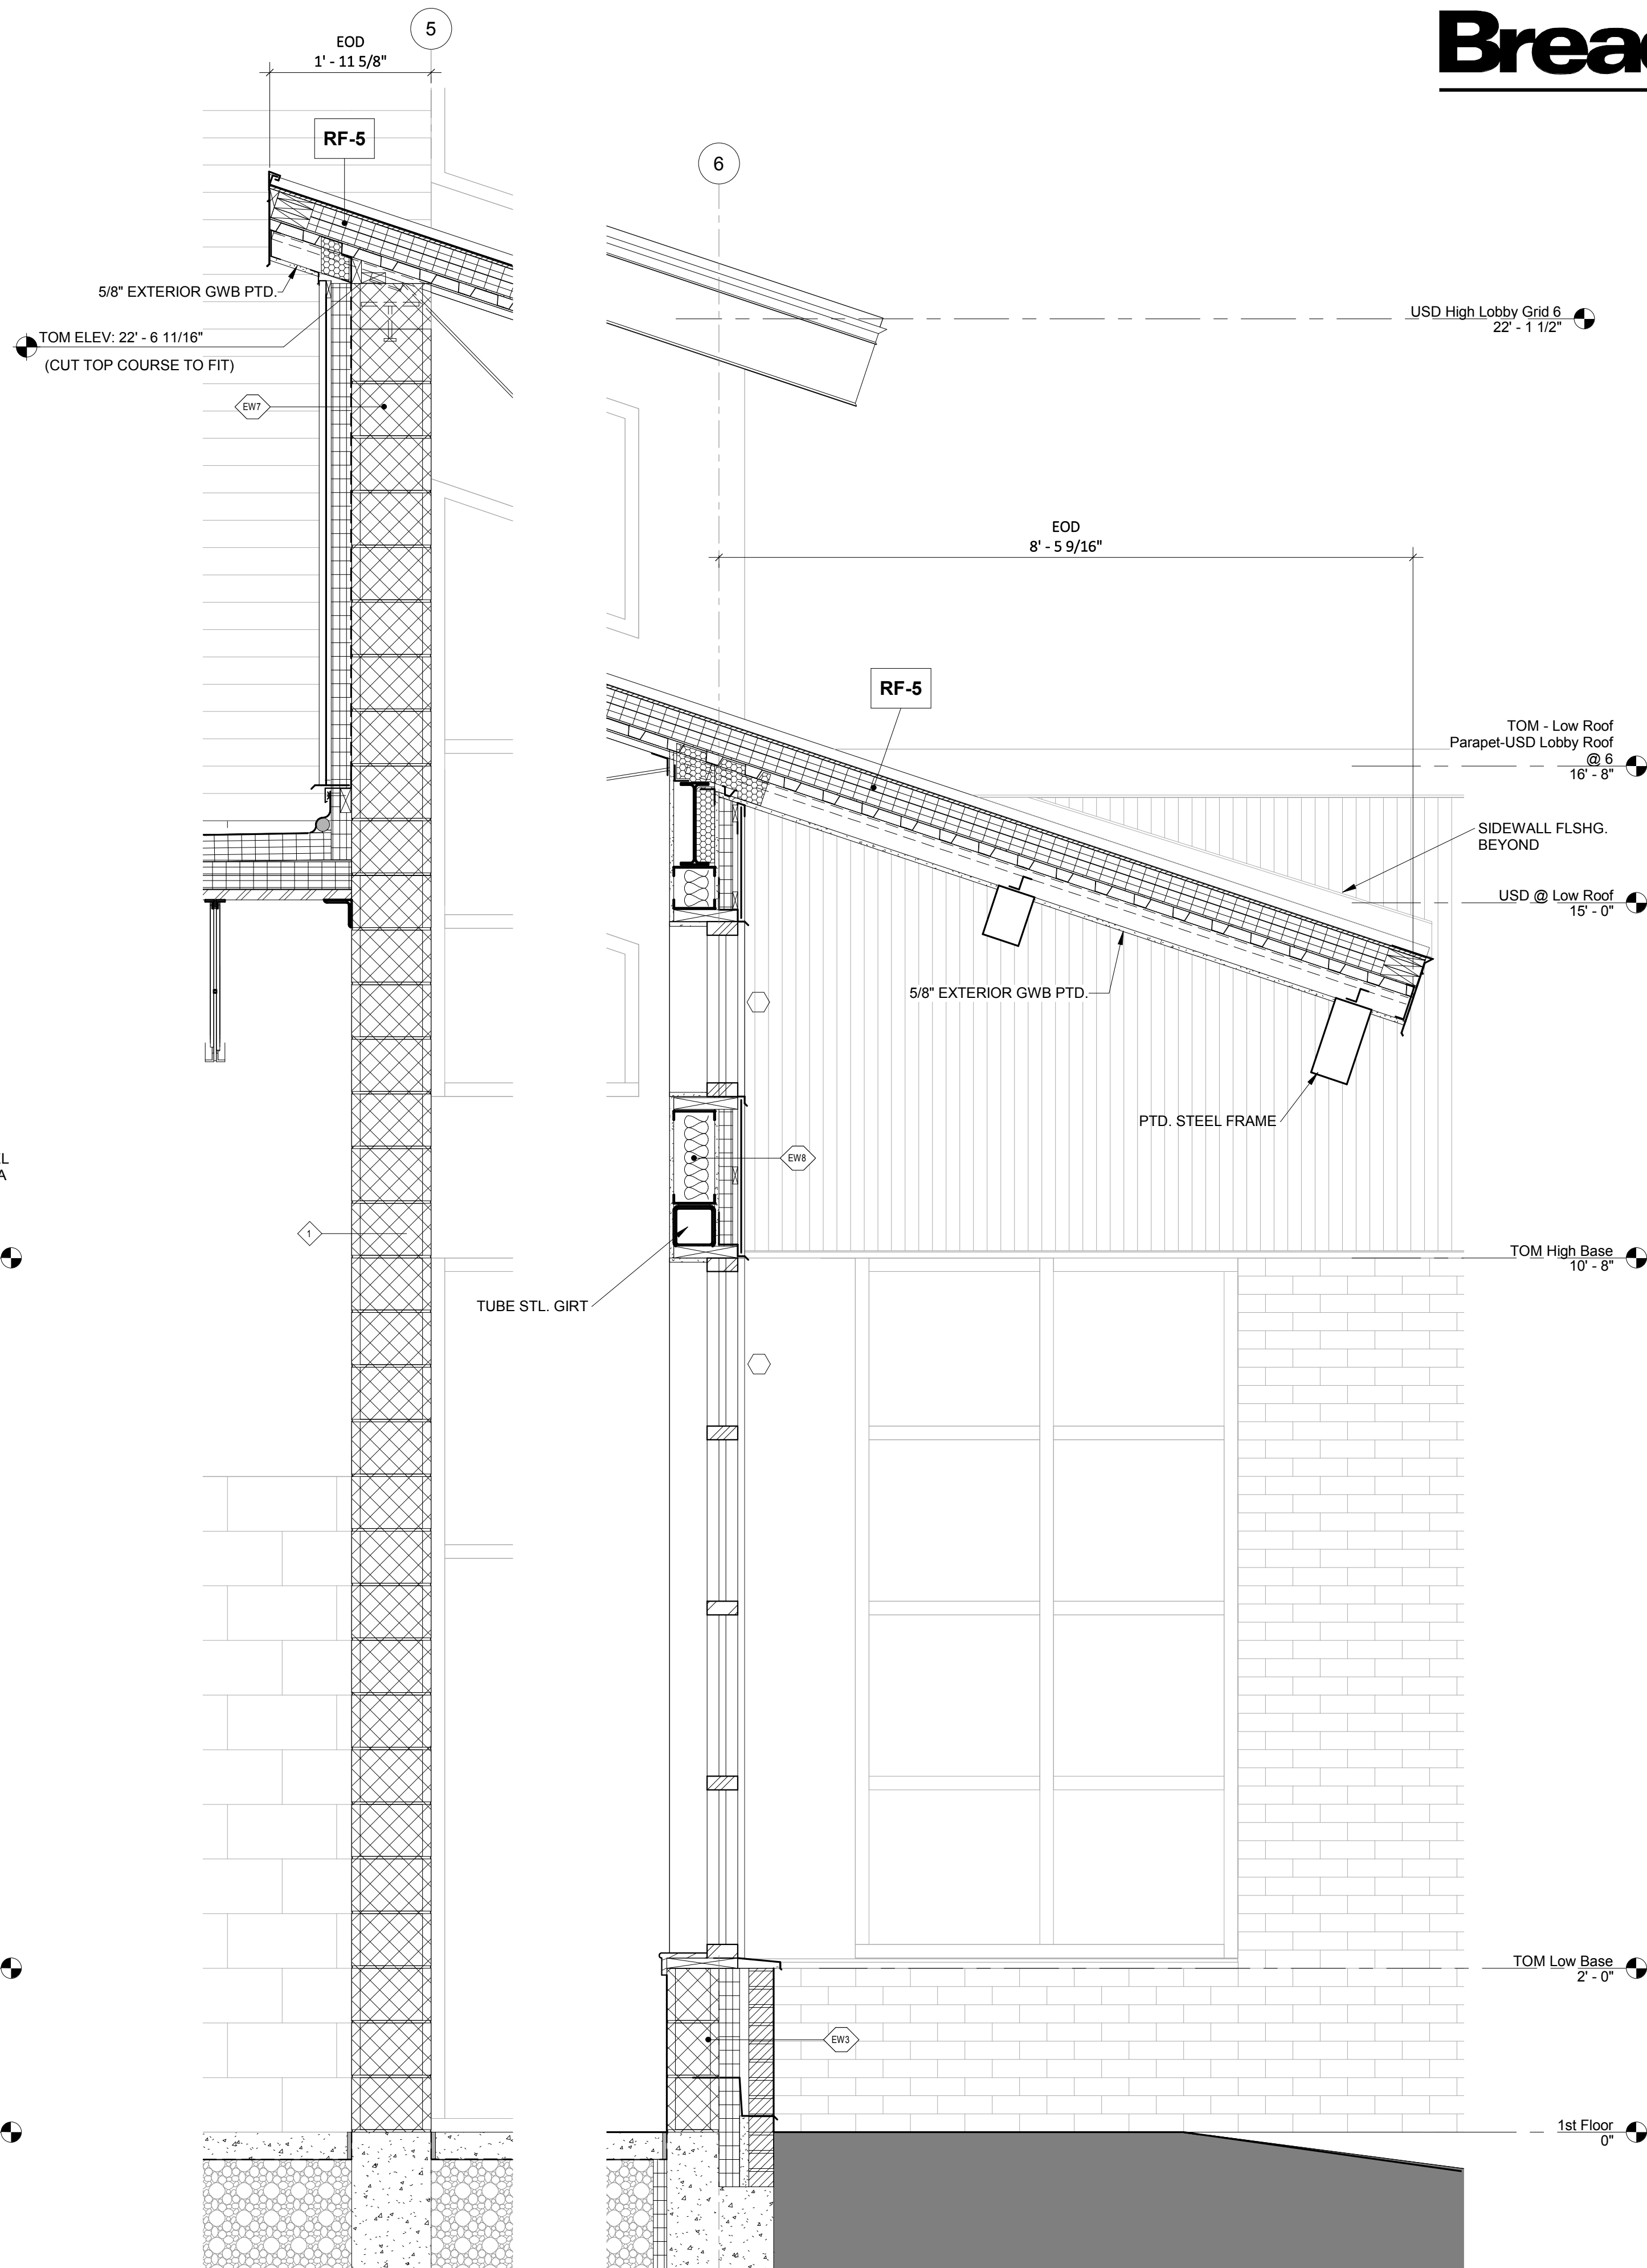

3 N-S WALL SECT. @ WEST VESTIBULE
A-2.1/A-6.2 3/4" = 1'-0"

DESIGN DEVELOPMENT

Revised		
No.	Date	Description


NEWPORT
COMMUNITY CENTER

NEWPORT, NH


Proj. No: 18412 Drawn: SR
Date: 12/20/2018 Chk'd: JD

Exterior Wall
Sections


A-6.3

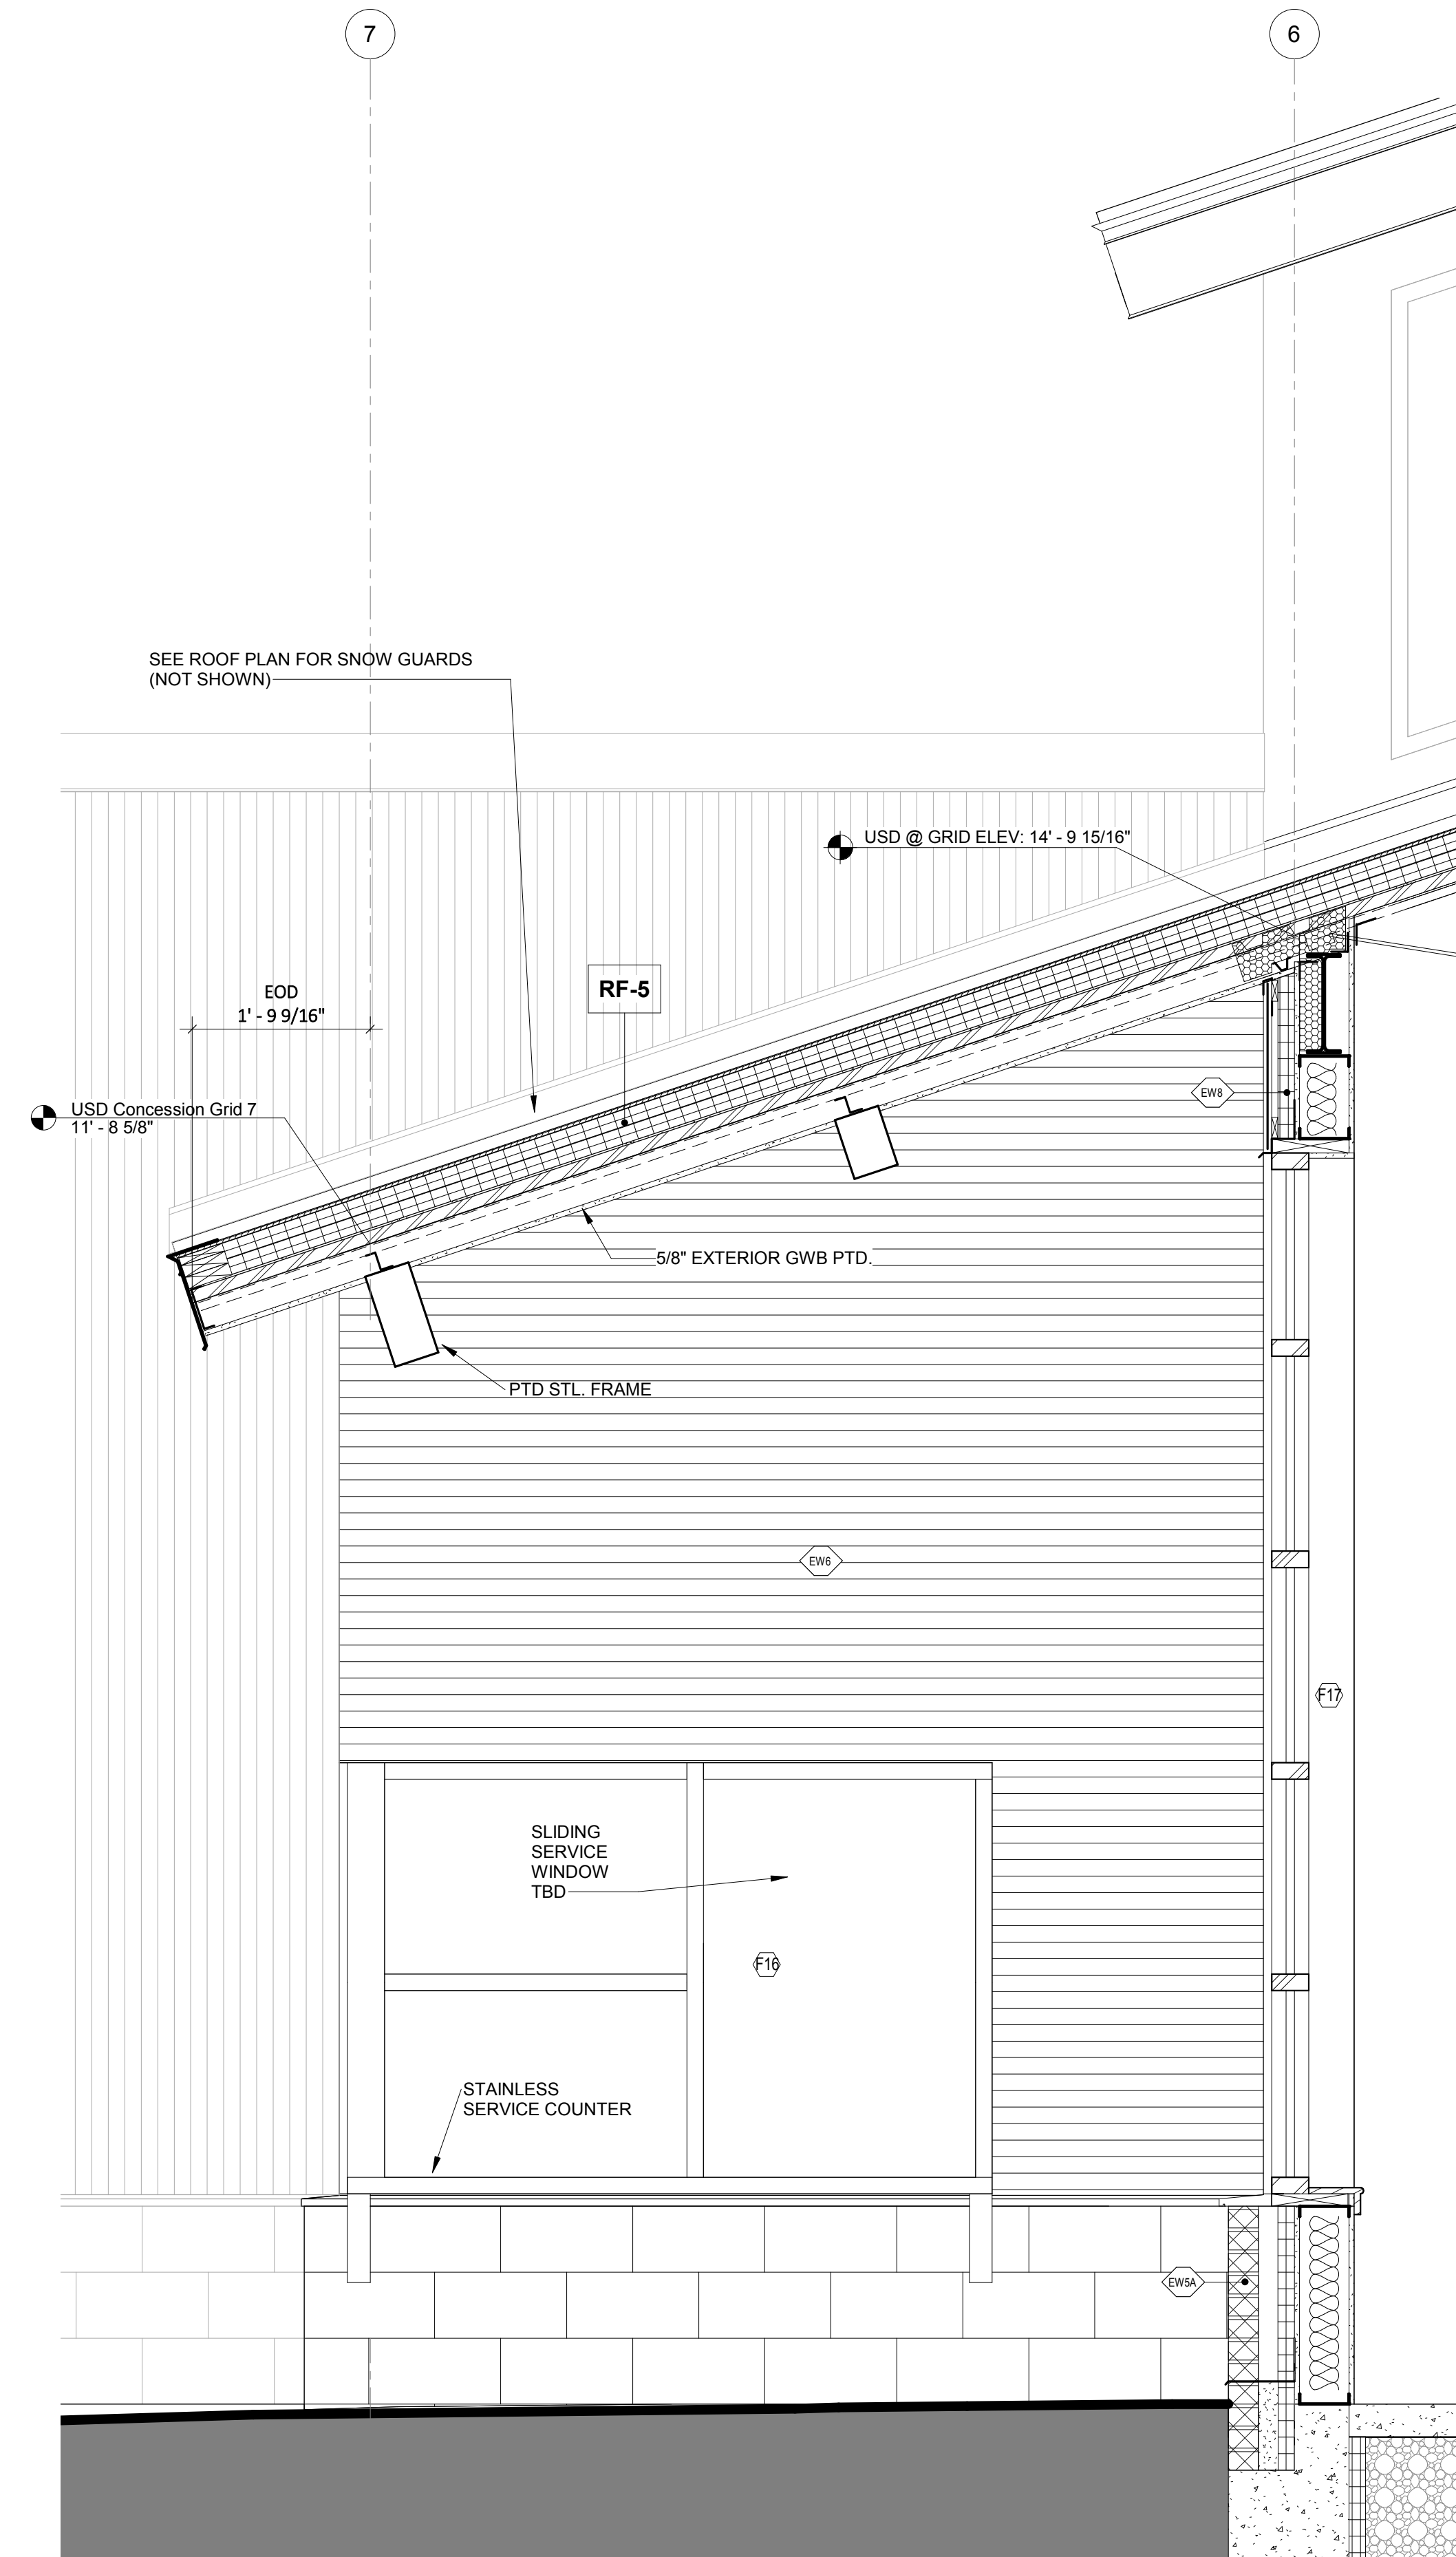

3 N-S WALL SECT. @ EAST VESTIBULE
A.2.1/A.6.3 3/4\"/>

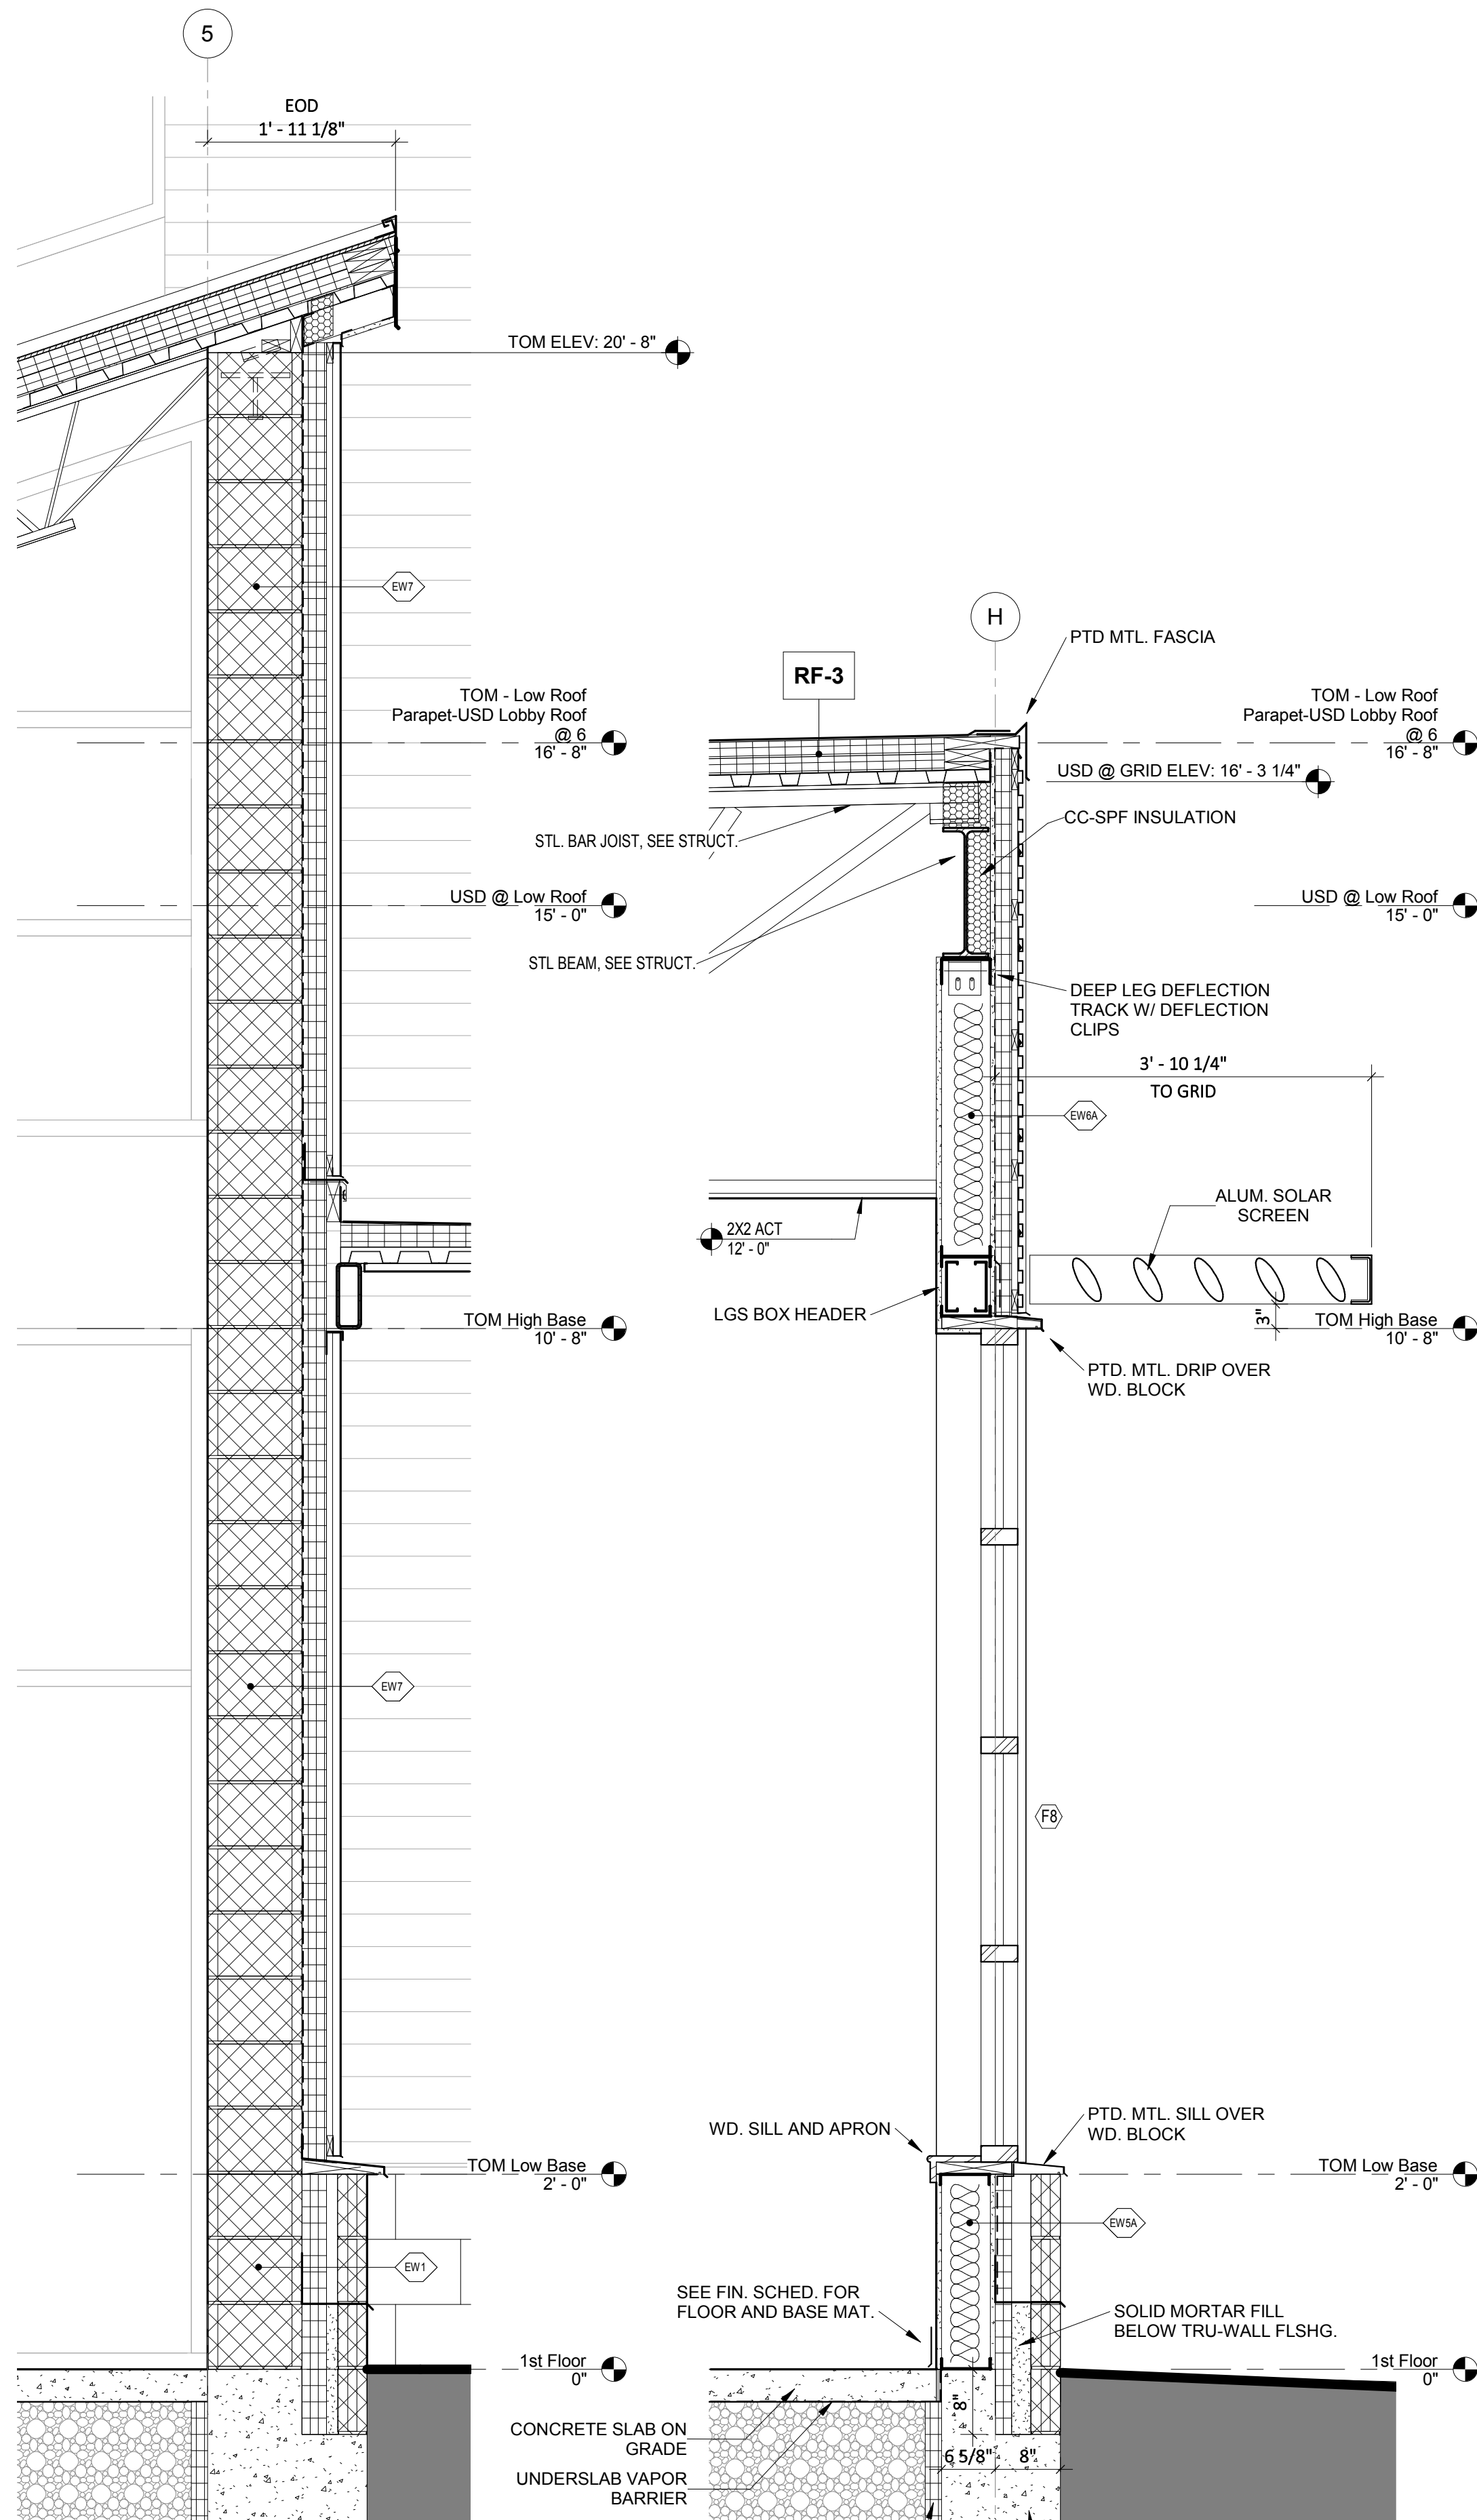

1 WALL SECTION @ MP ROOMS
A.5.1/A.6.3 3/4\"/>

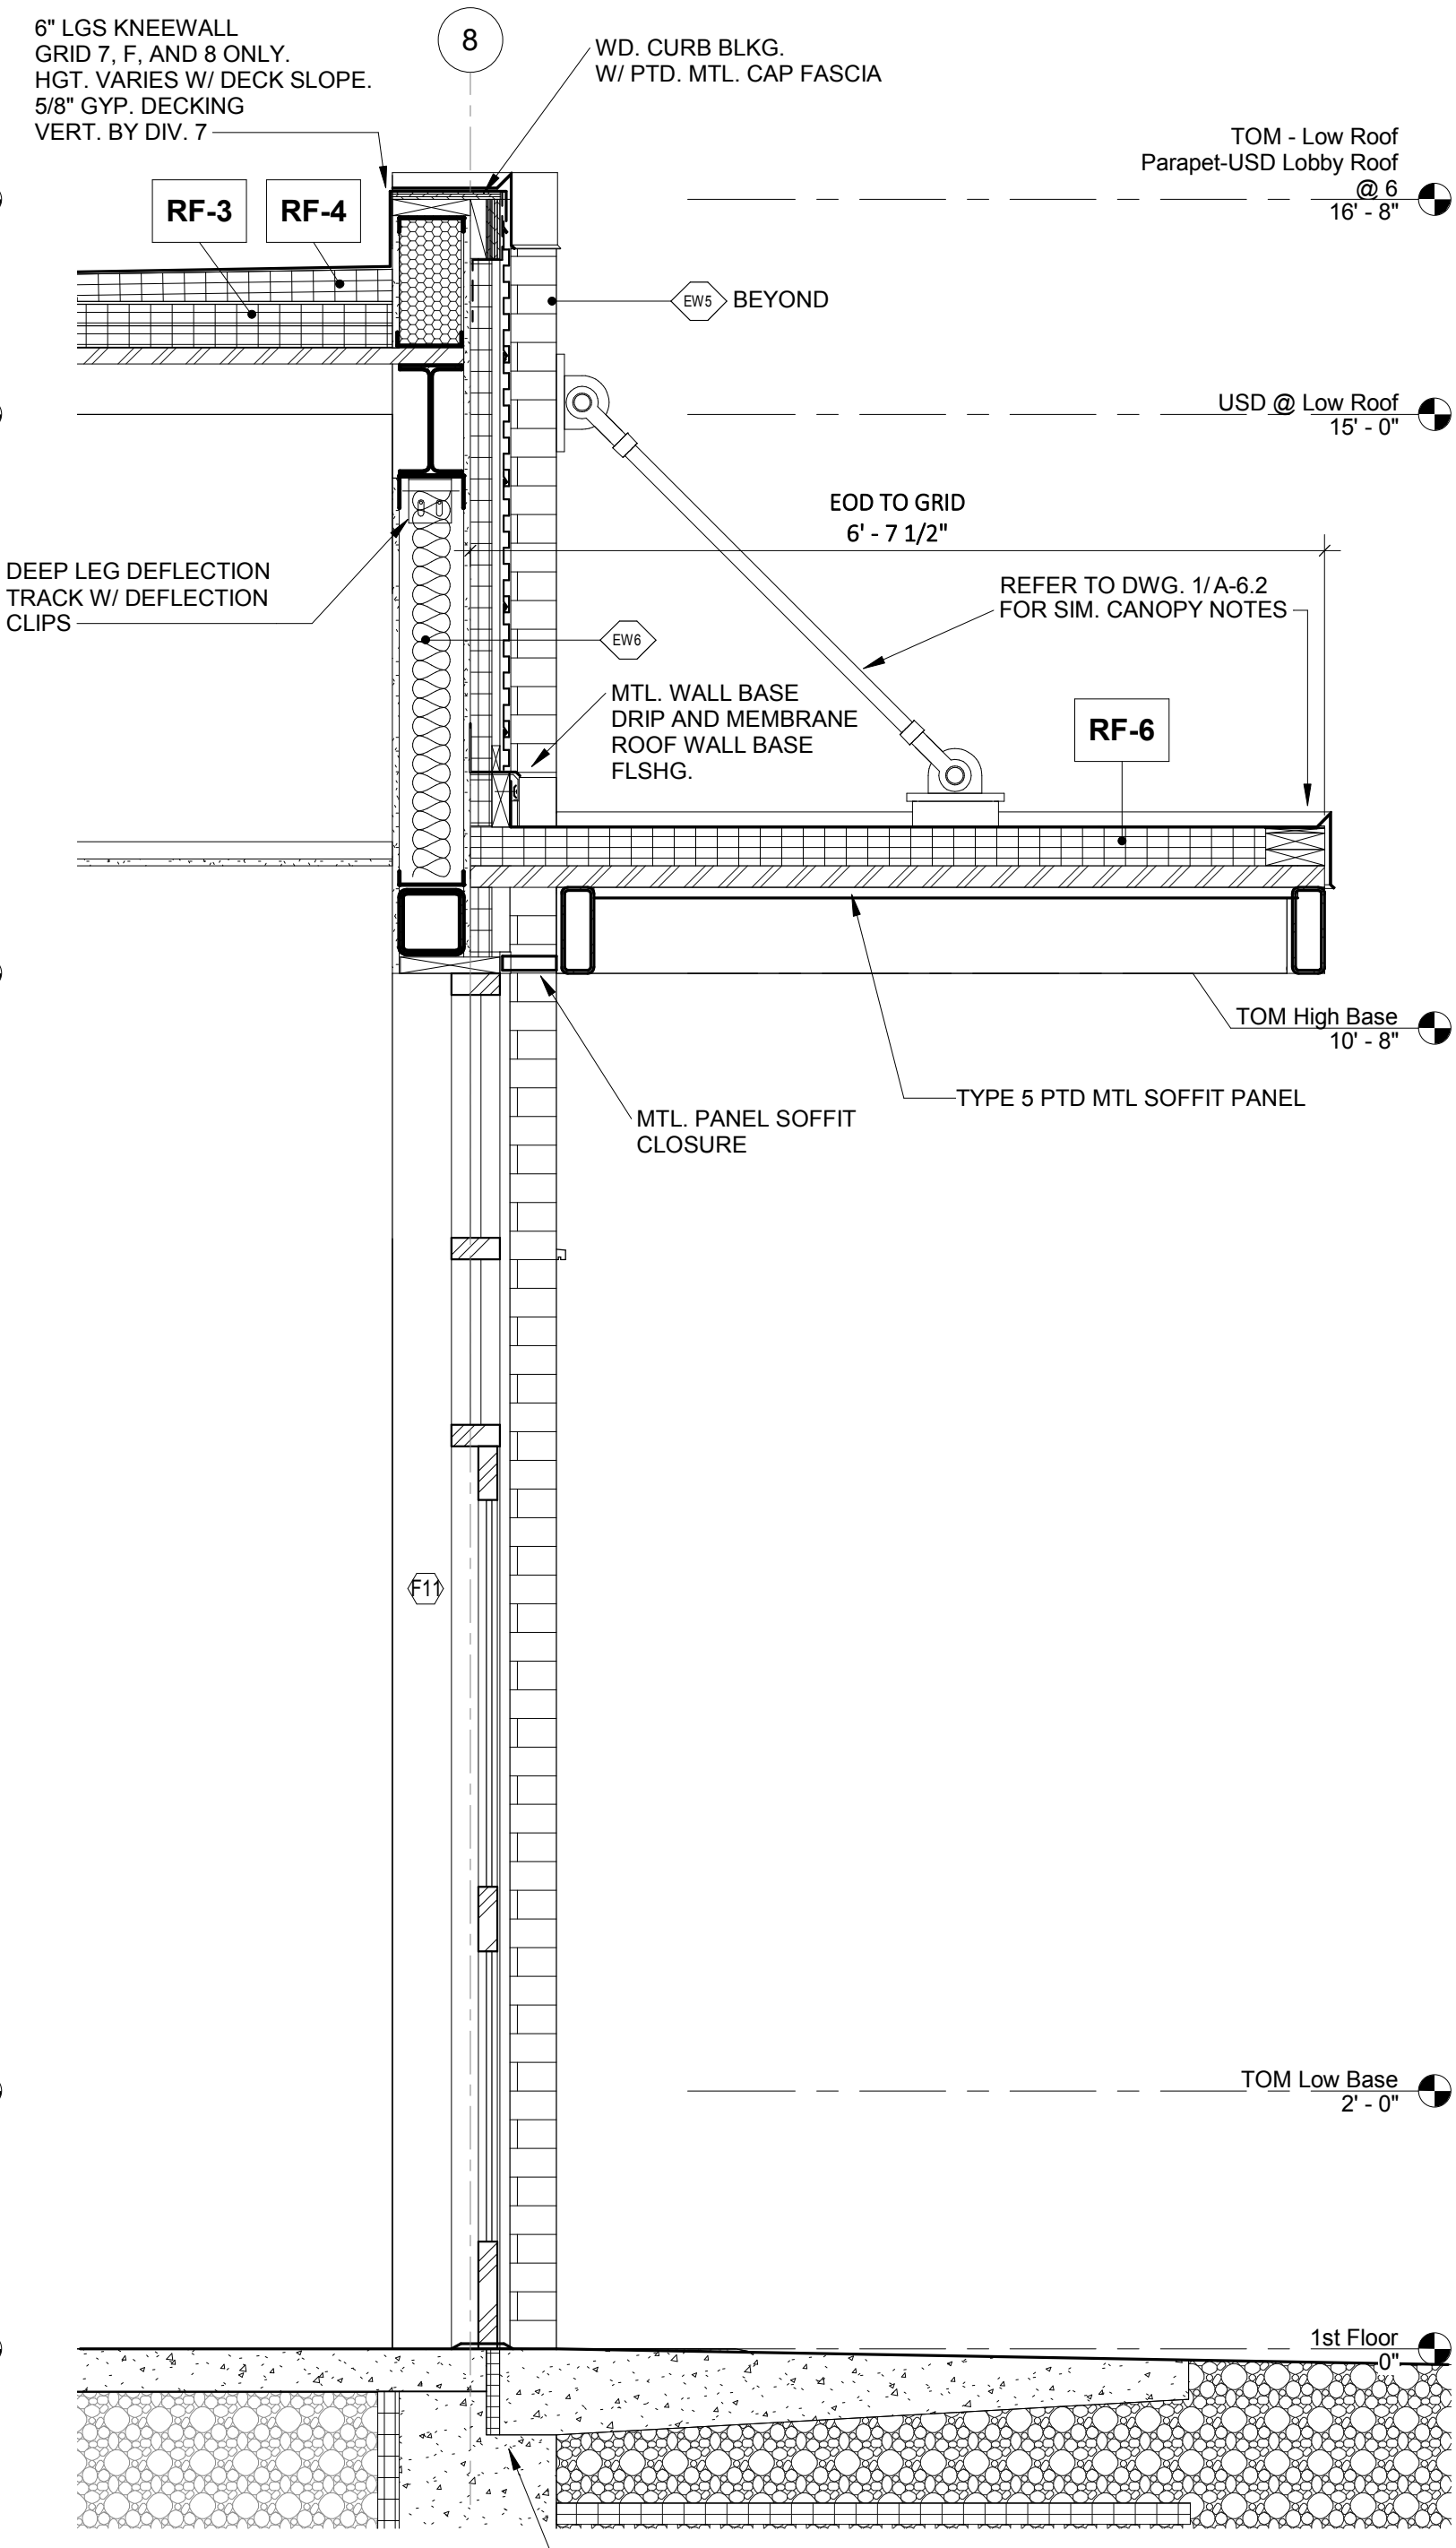


2 WALL SECT. @ SOUTH VESTIBULE
A.5.1/A.6.3 3/4\"/>

DESIGN DEVELOPMENT


DOOR SCHEDULE											
NO.	FROM	TO	DOOR				FRAME				Comments
			WIDTH	HEIGHT	THICKNESS	TYPE	MAT	GLAZING	MAT	DEPTH	
100	W. VEST.		6'-0"	7'-0"	1 3/4"	DG	AL	SG-S	AL	SEE ELEV	
101	LOBBY	W. VEST.	6'-0"	7'-0"	1 3/4"	DG	AL	SG-S	AL	SEE ELEV	
101A	E. VEST.	LOBBY	6'-0"	7'-0"	1 3/4"	DG	AL	SG-S	AL	SEE ELEV	
102	LOBBY	RECEPTION/ DIRECTOR	3'-0"	7'-0"	1 3/4"	DG	AL	SG-S	AL	SEE ELEV	
102A	RECEPTION/ DIRECTOR	STORAGE	3'-0"	7'-0"	1 3/4"	F	SC. WD		HM	A 8 1/4"	-
103	LOBBY	FITNESS ROOM	3'-0"	7'-0"	1 3/4"	DG	AL	SG-S	AL	SEE ELEV	
103A	FITNESS ROOM	FITNESS STORAGE	3'-0"	7'-0"	1 3/4"	F	SC. WD		HM	A 8 1/4"	-
103B	FITNESS ROOM	MULTI - PURPOSE ROOM A	10'-0"	10'-0"	2 1/8"	OHD	AL	SG-L	STL	SEE ELEV	MOTORIZED. STL. CHANNEL OPNG FRAME BY DIV. 5
104	CORRIDOR B	CORRIDOR C	3'-0"	7'-0"	1 3/4"	DG	SC. WD	SG-S	HM	A 8 1/4"	-
105	SHOWER A	CORRIDOR B	3'-0"	7'-0"	1 3/4"	F	SC. WD		HM	A 8 1/4"	-
106	CORRIDOR B	SHOWER B	3'-0"	7'-0"	1 3/4"	F	SC. WD		HM	A 8 1/4"	-
107	MULTI - PURPOSE ROOM A	CORRIDOR C	3'-0"	7'-0"	1 3/4"	DG	SC. WD	SG-S	HM	A 8 1/4"	-
107A	MULTI - PURPOSE ROOM A	STORAGE	3'-0"	7'-0"	1 3/4"	F	SC. WD		HM	A 8 1/4"	-
107B	STORAGE	MULTI - PURPOSE ROOM A	3'-0"	7'-0"	1 3/4"	F	SC. WD		HM	A 8 1/4"	-
107C		MULTI - PURPOSE ROOM A	3'-0"	7'-0"	1 3/4"	DG	AL	SG-S	AL	SEE ELEV	
108	MULTI - PURPOSE ROOM B	CORRIDOR C	3'-0"	7'-0"	1 3/4"	DG	SC. WD	SG-S	HM	A 8 1/4"	-
108A	MULTI - PURPOSE ROOM B	SPRINKLER	3'-0"	7'-0"	1 3/4"	F	SC. WD		HM	A 8 1/4"	-
110	CORRIDOR C	S. VEST.	3'-0"	7'-0"	1 3/4"	DG	AL	SG-S	AL	SEE ELEV	
111	JAN.	CORRIDOR C	3'-0"	7'-0"	1 3/4"	F	SC. WD		HM	A 8 1/4"	-
113	S. VEST.		3'-0"	7'-0"	1 3/4"	DG	AL	SG-S	AL	SEE ELEV	
114	MEN'S	CORRIDOR C	3'-0"	7'-0"	1 3/4"	F	SC. WD		HM	A 8 1/4"	-
115	CORRIDOR C	WOMEN'S	3'-0"	7'-0"	1 3/4"	F	SC. WD		HM	A 8 1/4"	-
116	MULTI - PURPOSE ROOM D	CORRIDOR B	3'-0"	7'-0"	1 3/4"	DG	AL	SG-S	AL	SEE ELEV	
116A	MULTI - PURPOSE ROOM D	STORAGE	3'-0"	7'-0"	1 3/4"	F	SC. WD		HM	A 8 1/4"	-
116B	STORAGE	MULTI - PURPOSE ROOM D	3'-0"	7'-0"	1 3/4"	F	SC. WD		HM	A 8 1/4"	-
116C	STORAGE	MULTI - PURPOSE ROOM D	3'-0"	7'-0"	1 3/4"	F	SC. WD		HM	A 8 1/4"	-
118	MULTI - PURPOSE ROOM C	CONCESSION	3'-0"	7'-0"	1 3/4"	F	SC. WD		HM	A 8 1/4"	-
119		E. VEST.	6'-0"	7'-0"	1 3/4"	DG	AL	SG-S	AL	SEE ELEV	
120	GYMNASIUM	LOBBY	6'-0"	8'-0"	1 3/4"	DG	AL	SG-S	AL	SEE ELEV	
120A	LOBBY	GYMNASIUM	6'-0"	8'-0"	1 3/4"	DG	AL	SG-S	AL	SEE ELEV	
120B	GYMNASIUM	CORRIDOR A	3'-0"	7'-0"	1 3/4"	F	SC. WD		HM	B 12 5/8"	-
120C	CORRIDOR A	GYMNASIUM	3'-0"	7'-0"	1 3/4"	F	SC. WD		HM	B 12 5/8"	-
120D	GYMNASIUM		3'-0"	7'-0"	1 3/4"	F	MTL-INSUL		HM	B 7"	-
121	CORRIDOR A	LOBBY	3'-0"	7'-0"	1 3/4"	FG	WD		HM	B 12 5/8"	-
122	MECH / ELEC	CORRIDOR A	3'-0"	7'-0"	1 3/4"	F	SC. WD		HM	B 8 5/8"	-
123	CORRIDOR A	TEAM ROOM #1	3'-0"	7'-0"	1 3/4"	F	SC. WD		HM	B 8 5/8"	-
124	TEAM ROOM #2	CORRIDOR A	3'-0"	7'-0"	1 3/4"	F	SC. WD		HM	B 8 5/8"	-
124A	TEAM ROOM #2	TEAM ROOM #1	3'-0"	7'-0"	1 3/4"	F	SC. WD		HM	B 8 5/8"	-
125	LAV A	CORRIDOR A	3'-0"	7'-0"	1 3/4"	F	SC. WD		HM	B 8 5/8"	-
126	CORRIDOR A	LAV B	3'-0"	7'-0"	1 3/4"	F	SC. WD		HM	B 8 5/8"	-
127	CORRIDOR A	TEAM ROOM #3	3'-0"	7'-0"	1 3/4"	F	SC. WD		HM	B 8 5/8"	-
128	TEAM ROOM #4	CORRIDOR A	3'-0"	7'-0"	1 3/4"	F	SC. WD		HM	B 8 5/8"	-
128A	TEAM ROOM #4	TEAM ROOM #3	3'-0"	7'-0"	1 3/4"	F	SC. WD		HM	B 8 5/8"	-
129	GYMNASIUM	GYM STORAGE	3'-0"	7'-0"	1 3/4"	F	SC. WD		HM	B 12 5/8"	-

DOOR SCHEDULE - HARDWARE											
NO.	Function										Comments
100		•	•	•	•	•	•	•	•	•	
101		•	•	•	•	•	•	•	•	•	
101A		•	•	•	•	•	•	•	•	•	
102		•	•	•	•	•	•	•	•	•	
102A		•	•	•	•	•	•	•	•	•	
103		•	•	•	•	•	•	•	•	•	
103A		•	•	•	•	•	•	•	•	•	
103B		•	•	•	•	•	•	•	•	•	MOTORIZED. STL. CHANNEL OPNG FRAME BY DIV. 5
104		•	•	•	•	•	•	•	•	•	
105		•	•	•	•	•	•	•	•	•	
106		•	•	•	•	•	•	•	•	•	
107		•	•	•	•	•	•	•	•	•	
107A		•	•	•	•	•	•	•	•	•	
107B		•	•	•	•	•	•	•	•	•	
107C		•	•	•	•	•	•	•	•	•	
108		•	•	•	•	•	•	•	•	•	
108A		•	•	•	•	•	•	•	•	•	
110		•	•	•	•	•	•	•	•	•	
111		•	•	•	•	•	•	•	•	•	
113		•	•	•	•	•	•	•	•	•	
114		•	•	•	•	•	•	•	•	•	
115		•	•	•	•	•	•	•	•	•	
116		•	•	•	•	•	•	•	•	•	
116A		•	•	•	•	•	•	•	•	•	
116B		•	•	•	•	•	•	•	•	•	
116C		•	•	•	•	•	•	•	•	•	
118		•	•	•	•	•	•	•	•	•	
119		•	•	•	•	•	•	•	•	•	
120		•	•	•	•	•	•	•	•	•	
120A		•	•	•	•	•	•	•	•	•	
120B		•	•	•	•	•	•	•	•	•	
120C		•	•	•	•	•	•	•	•	•	
120D		•	•	•	•	•	•	•	•	•	
121		•	•	•	•	•	•	•	•	•	
122		•	•	•	•	•	•	•	•	•	
123		•	•	•	•	•	•	•	•	•	
124		•	•	•	•	•	•	•	•	•	
124A		•	•	•	•	•	•	•	•	•	
125		•	•	•	•	•	•	•	•	•	
126		•	•	•	•	•	•	•	•	•	
127		•	•	•	•	•	•	•	•	•	
128		•	•	•	•	•	•	•	•	•	
128A		•	•	•	•	•	•	•	•	•	
129		•	•	•	•	•	•	•	•	•	

GLAZING LEGEND	
TYPE	LABEL - SEE SPECS FOR DETAILS
SG	SINGLE GLAZED
SG-S	SINGLE GLAZED-SAFETY (TEMPERED)
SG-L	SINGLE GLAZED - LAMINATED (CPSC CATEGORY II)
IG	INSULATED GLASS
IG-S	INSULATED GLASS - SAFETY (TEMPERED)
IG-L	INSULATED GLASS - LAMINATED (CPSC CATEGORY II)

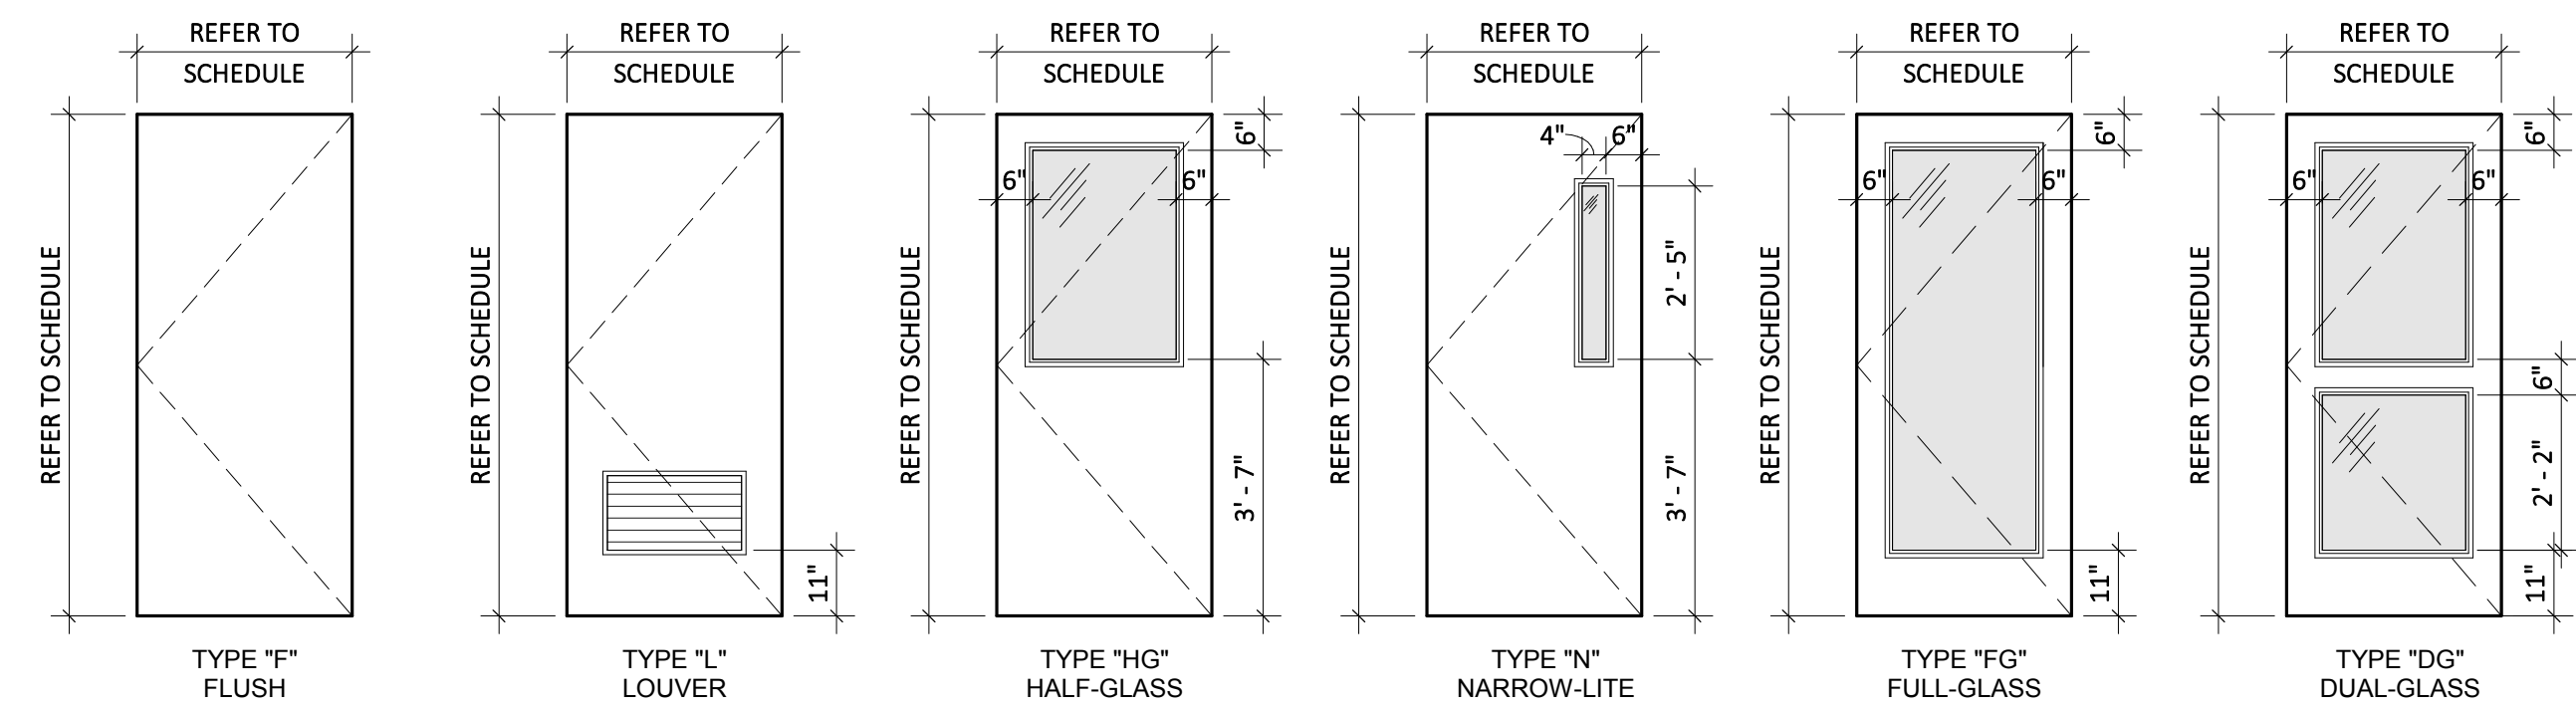


DOOR TYPES

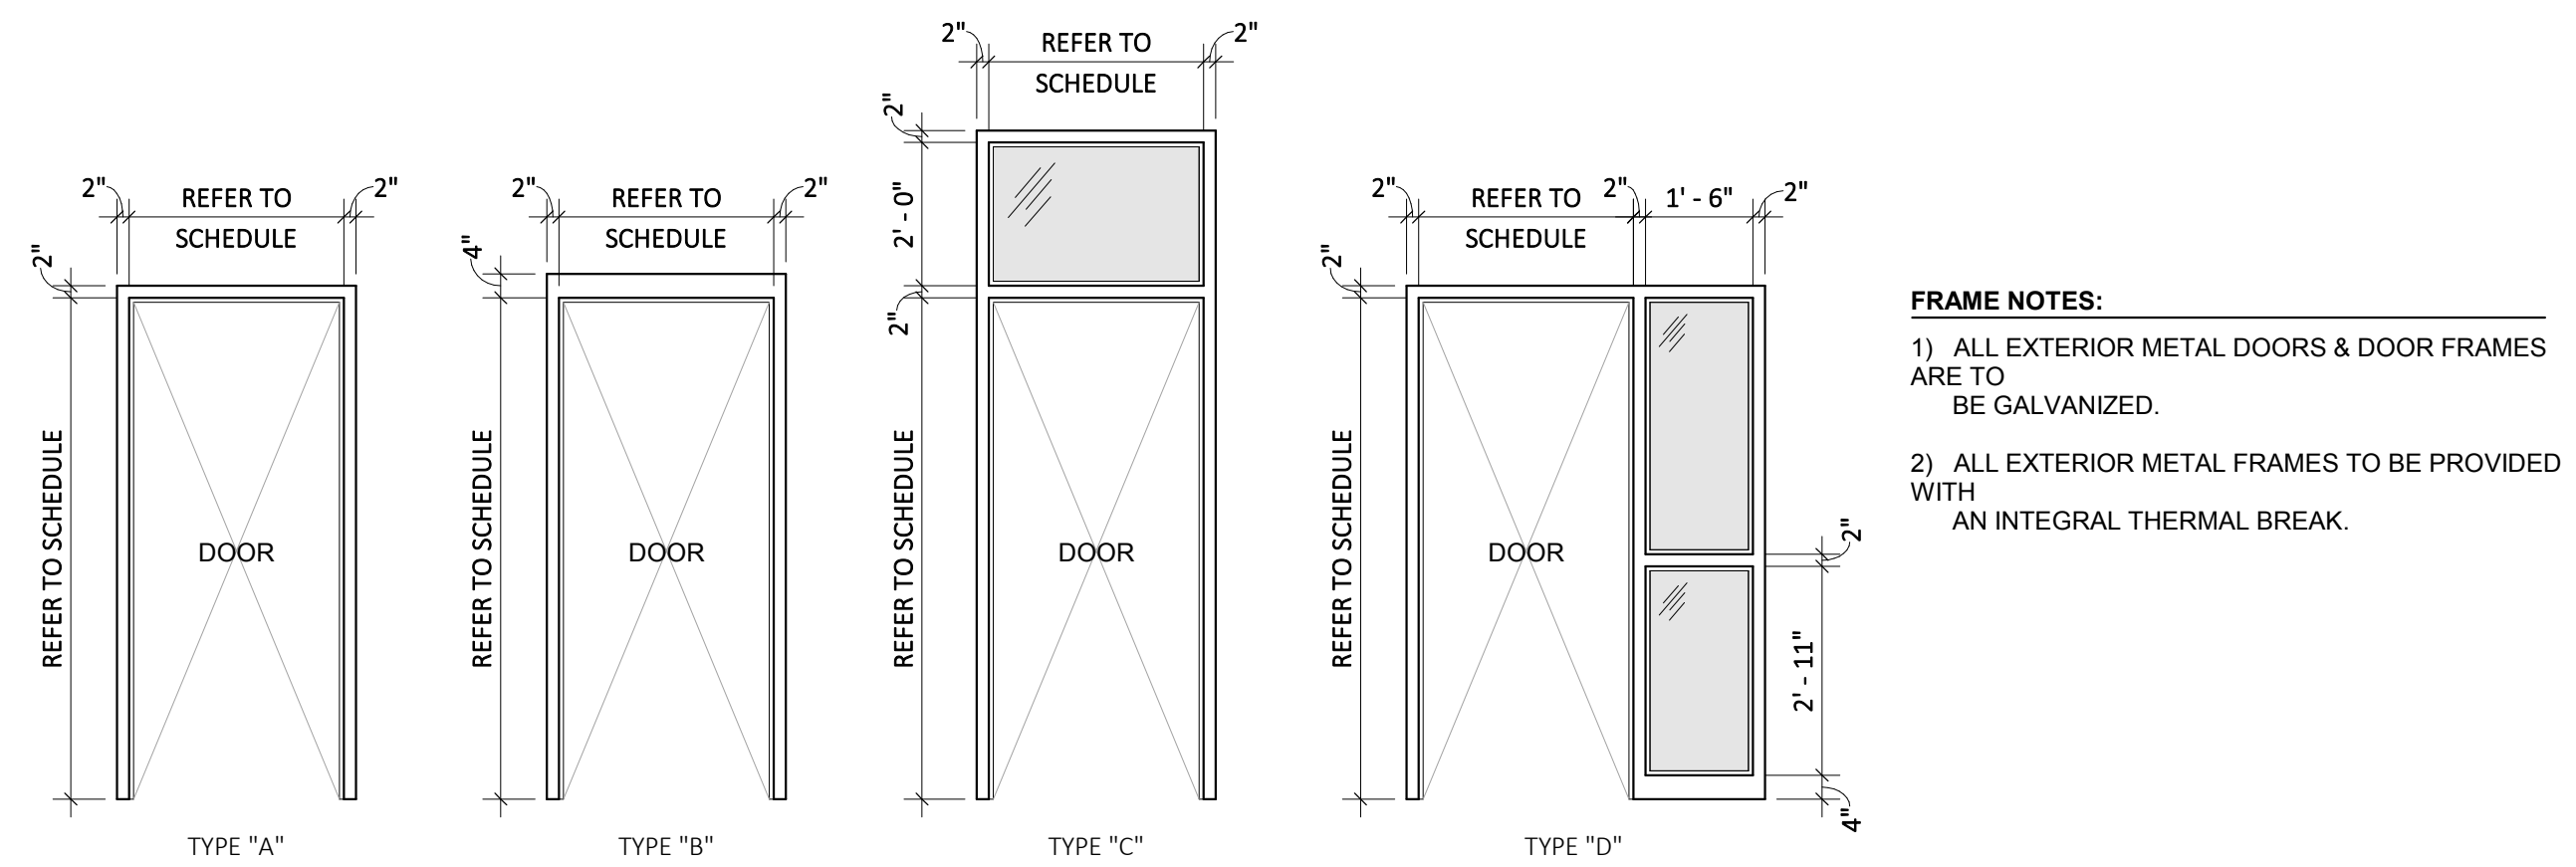

DOOR FRAME TYPES

- DOOR NOTES:**
- 1) ALL GLAZING SHALL BE TEMPERED SAFETY GLASS UNLESS OTHERWISE NOTED. PROVIDE INSULATED GLASS ON ALL EXTERIOR DOORS AND SIDELIGHTS.
 - 2) CENTER LEVERS & PANIC DEVICES ON CENTER MULLION WHERE APPLICABLE. MATCH LOCATION OF PANIC DEVICES AND LEVER ON ALL OTHER DOORS.

- FRAME NOTES:**
- 1) ALL EXTERIOR METAL DOORS & DOOR FRAMES ARE TO BE GALVANIZED.
 - 2) ALL EXTERIOR METAL FRAMES TO BE PROVIDED WITH AN INTEGRAL THERMAL BREAK.

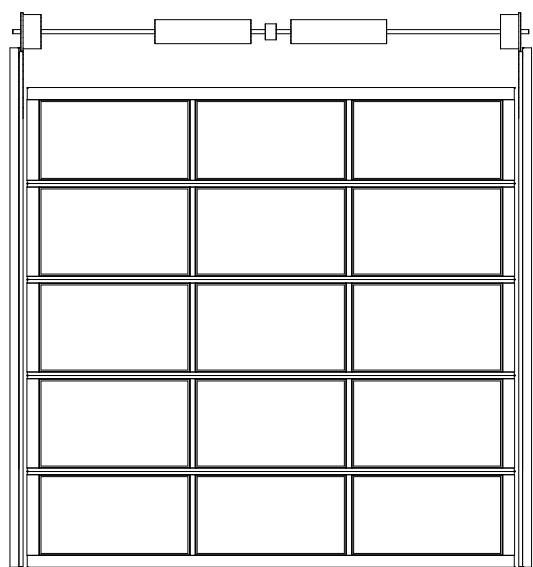

Overhead Door Type OHD

Revised		
No.	Date	Description


NEWPORT
COMMUNITY CENTER

NEWPORT, NH



Proj. No: 18412 Drawn: SR
Date: 12/20/2018 Chk'd: JD

Exterior
Storefront
Elevations


A-8.2

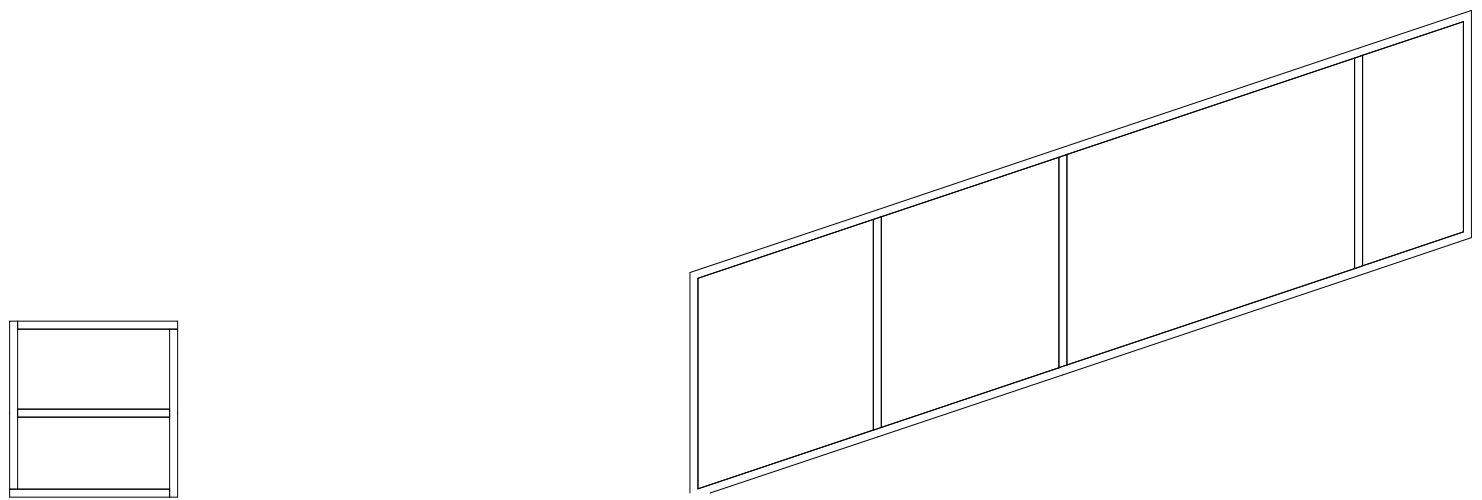


19 FRAME F19 ELEVATION
JA.8.2 1/4" = 1'-0"

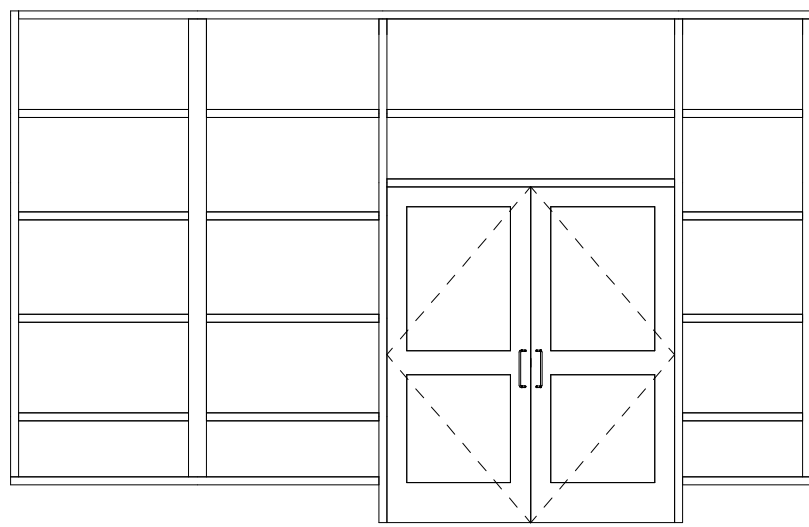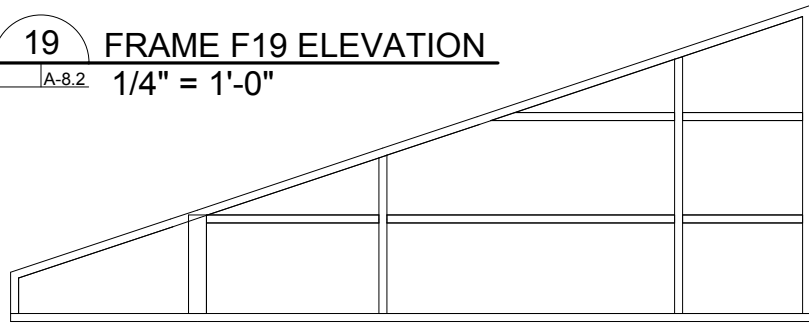


18 FRAME F18 ELEVATION
JA.8.2 1/4" = 1'-0"

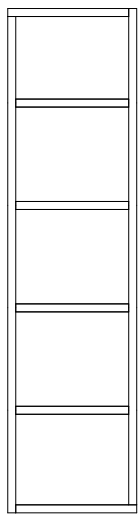


17 FRAME F17 ELEVATION
JA.8.2 1/4" = 1'-0"

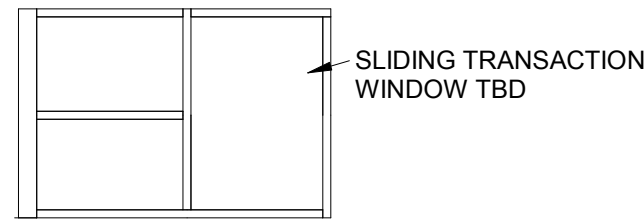

16 FRAME F16 ELEVATION
JA.8.2 1/4" = 1'-0"


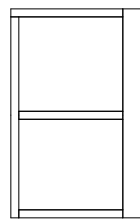


15 FRAME F15 ELEVATION
JA.8.2 1/4" = 1'-0"

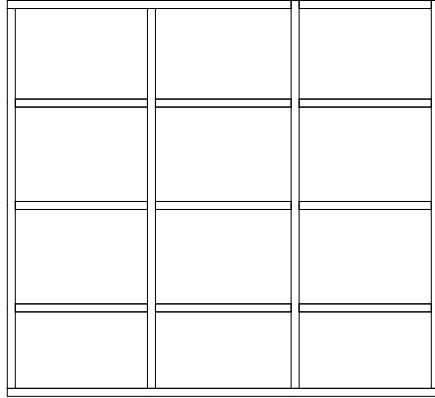


21 FRAME F21 ELEVATION
JA.8.2 1/4" = 1'-0"

 
20 FRAME F20 ELEVATION
JA.8.2 1/4" = 1'-0"

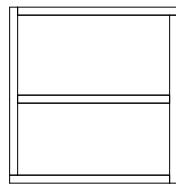

 
14 FRAME F14 ELEVATION
JA.8.2 1/4" = 1'-0"



 
13 FRAME F13 ELEVATION
JA.8.2 1/4" = 1'-0"




12 FRAME F12 ELEVATION
JA.8.2 1/4" = 1'-0"

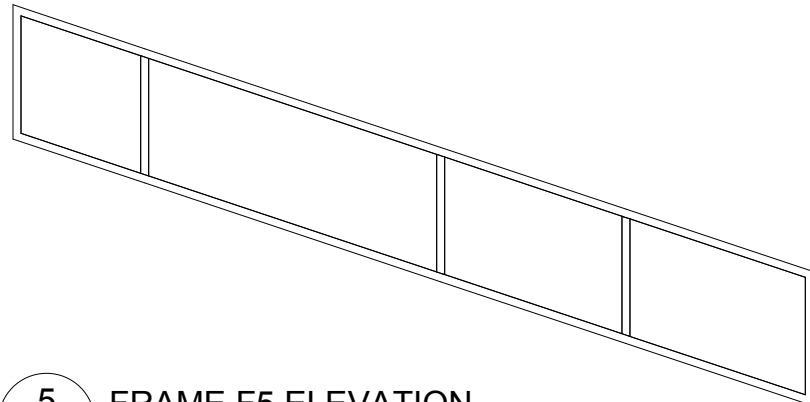


5 FRAME F5 ELEVATION
JA.8.2 1/4" = 1'-0"

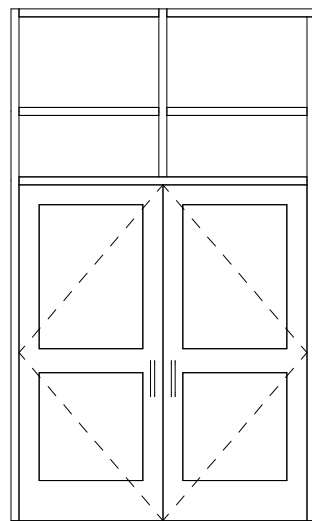


11 FRAME F11 ELEVATION
JA.8.2 1/4" = 1'-0"

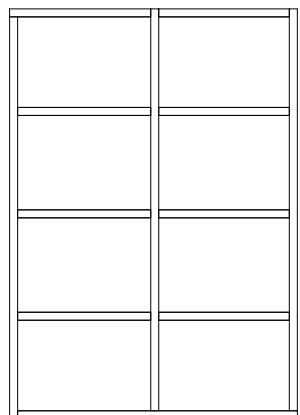


10 FRAME F10 ELEVATION
JA.8.2 1/4" = 1'-0"

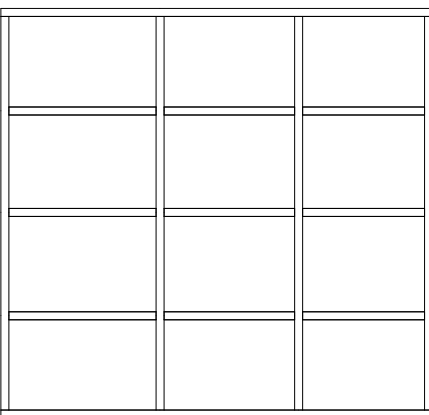



9 FRAME F9 ELEVATION
JA.8.2 1/4" = 1'-0"

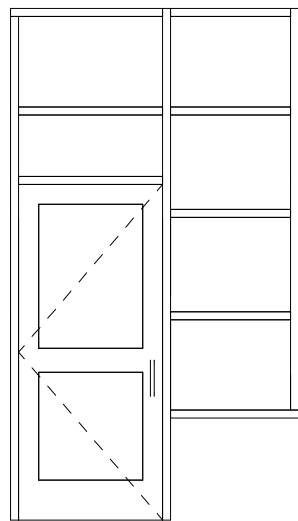

 
8 FRAME F8 ELEVATION
JA.8.2 1/4" = 1'-0"




7 FRAME F7 ELEVATION
JA.8.2 1/4" = 1'-0"

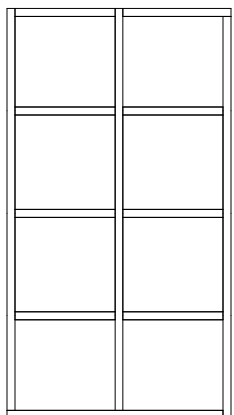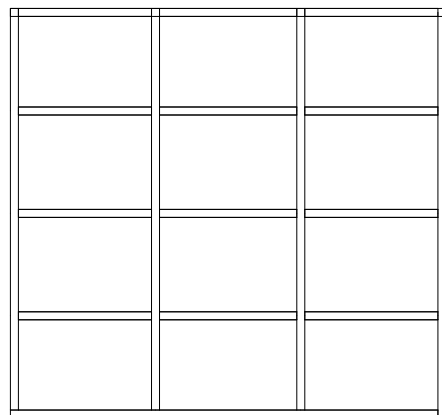


6 FRAME F6 ELEVATION
JA.8.2 1/4" = 1'-0"

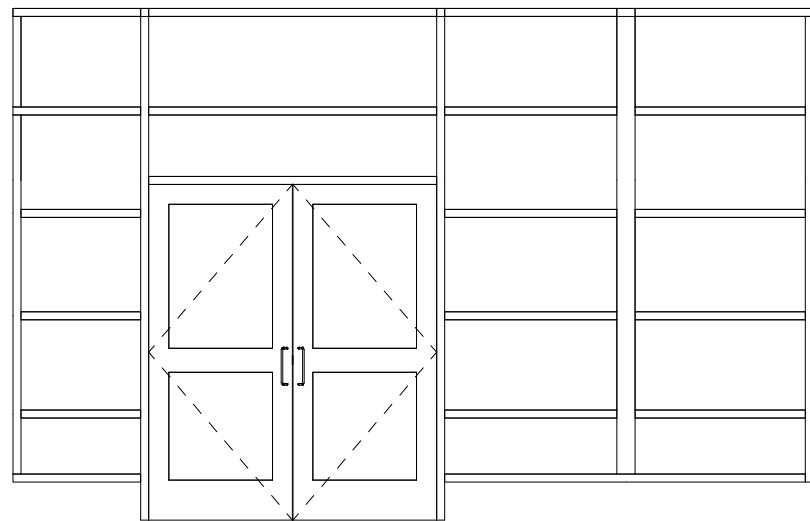


4 FRAME F4 ELEVATION
JA.8.2 1/4" = 1'-0"

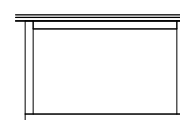

3 FRAME F3 ELEVATION
JA.8.2 1/4" = 1'-0"

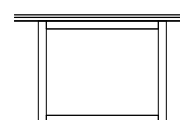


2 FRAME F2 ELEVATION
JA.8.2 1/4" = 1'-0"

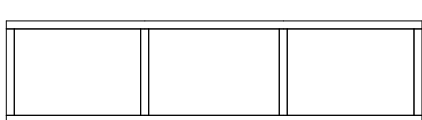


1 FRAME F1 ELEVATION
JA.8.2 1/4" = 1'-0"

DESIGN DEVELOPMENT

GLAZING LEGEND	
TYPE	LABEL - SEE SPECS FOR DETAILS
SG	SINGLE GLAZED
SG-S	SINGLE GLAZED-SAFETY (TEMPERED)
SG-L	SINGLE GLAZED - LAMINATED (CPSC CATEGORY II)
IG	INSULATED GLASS
IG-S	INSULATED GLASS - SAFETY (TEMPERED)
IG-L	INSULATED GLASS - LAMINATED (CPSC CATEGORY II)

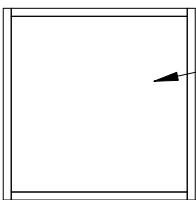


SLIDING
TRANSACTION
WINDOW TBD

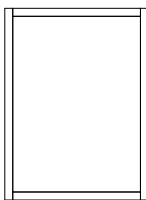


30 FRAME F30 ELEVATION
1/4" = 1'-0"


29 FRAME F29 ELEVATION
1/4" = 1'-0"

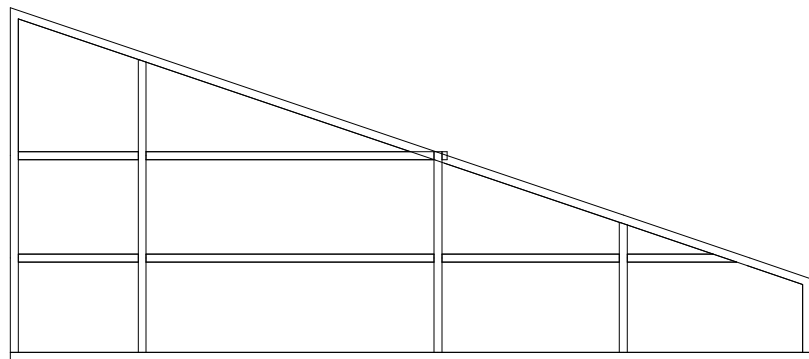


28 FRAME F28 ELEVATION
1/4" = 1'-0"

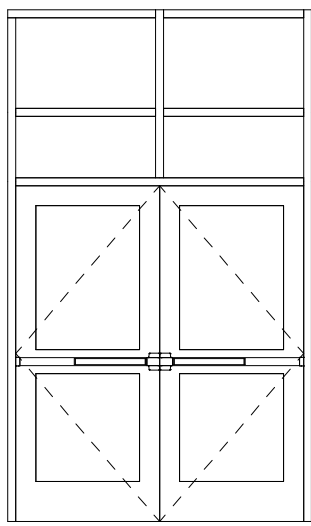

33 FRAME F33 ELEVATION
1/4" = 1'-0"

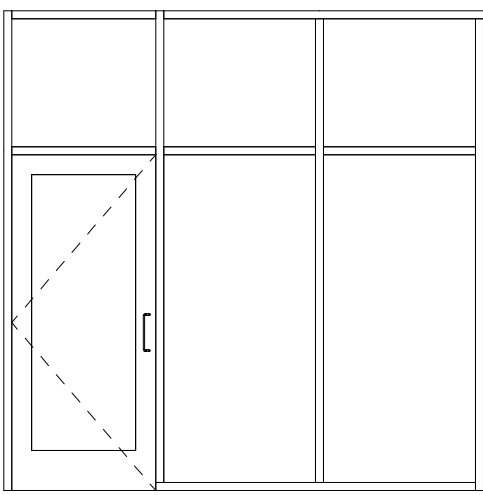


32 FRAME F32 ELEVATION
1/4" = 1'-0"

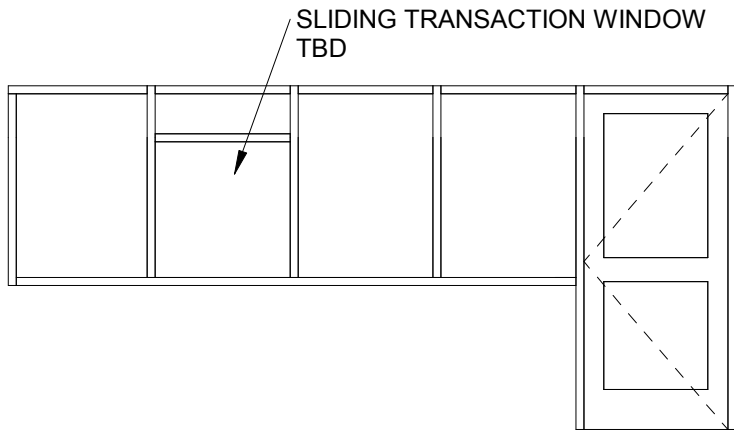


SLIDING TRANSACTION WINDOW
TBD


31 FRAME F31 ELEVATION
1/4" = 1'-0"

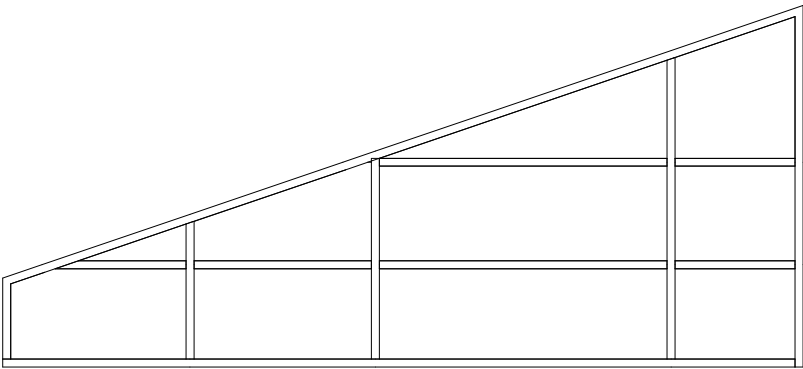


23 FRAME F23 ELEVATION
1/4" = 1'-0"

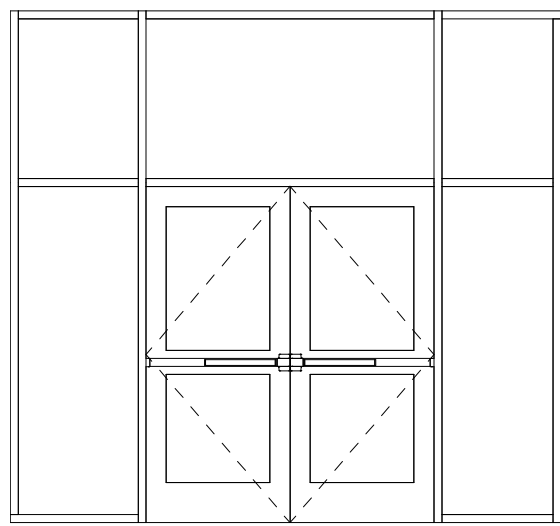


27 FRAME F27 ELEVATION
1/4" = 1'-0"

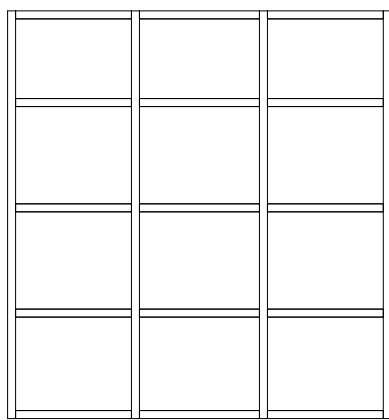


26 FRAME F26 ELEVATION
1/4" = 1'-0"

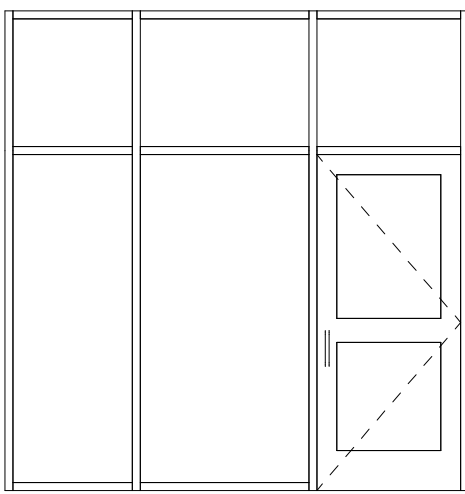

25 FRAME F25 ELEVATION
1/4" = 1'-0"

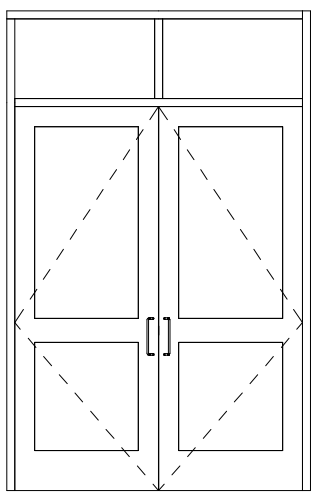

24 FRAME F24 ELEVATION
1/4" = 1'-0"

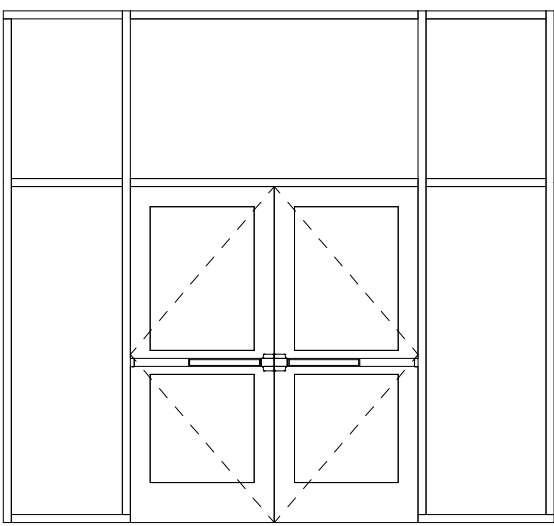

22 FRAME F22 ELEVATION
1/4" = 1'-0"

DESIGN DEVELOPMENT

Revised		
No.	Date	Description

NEWPORT
COMMUNITY CENTER

NEWPORT, NH

Proj. No: 18412 Drawn: SR
Date: 12/20/2018 Chk'd: JD

Interior Storefront
Elevations &
Details

A-8.4

Revised		
No.	Date	Description

NEWPORT
COMMUNITY CENTER

NEWPORT, NH

Proj. No: 18412 Drawn: SR
Date: 12/20/2018 Chk'd: JD
Finish Schedule

FINISH SCHEDULE								
NUM.	ROOM	FLOOR	BASE	WALLS				COMMENTS
				NORTH WALL	SOUTH WALL	EAST WALL	WEST WALL	
100	W. VEST.	ENTRY MAT	VINYL	GWB (PTD.)	STOREFRONT	GWB (PTD.)	STOREFRONT	
101	LOBBY	BURNISHED CONCRETE	VINYL	GWB (PTD.)	GWB (PTD.)	GWB (PTD.)	GWB (PTD.)	SEE FLOOR PLAN FOR ENTENT OF ENTRY MAT TILE
102	RECEPTION/ DIRECTOR	FLOTEX TILE	VINYL	GWB (PTD.)	GWB (PTD.)	GWB (PTD.)	GWB (PTD.)	
102A	STORAGE	FLOTEX TILE	VINYL	GWB (PTD.)	GWB (PTD.)	GWB (PTD.)	GWB (PTD.)	
103	FITNESS ROOM	RT-1; 3/8" RUBBER TILE	VINYL	GWB (PTD.)	GWB (PTD.)	GWB (PTD.)	GWB (PTD.)	
103A	FITNESS STORAGE	SEALED CONCRETE	VINYL	GWB (PTD.)	GWB (PTD.)	GWB (PTD.)	GWB (PTD.)	
104	CORRIDOR B	BURNISHED CONCRETE	VINYL	GWB (PTD.)	GWB (PTD.)	GWB (PTD.)	GWB (PTD.)	
105	SHOWER A	BURNISHED CONCRETE	VINYL	C.T. WAINSCOT / GWB (PTD.)	C.T. WAINSCOT / GWB (PTD.)	C.T. WAINSCOT / GWB (PTD.)	C.T. WAINSCOT / GWB (PTD.)	
106	SHOWER B	BURNISHED CONCRETE	VINYL	C.T. WAINSCOT / GWB (PTD.)	C.T. WAINSCOT / GWB (PTD.)	C.T. WAINSCOT / GWB (PTD.)	C.T. WAINSCOT / GWB (PTD.)	
107	MULTI - PURPOSE ROOM A	SPORTS FLOOR SF-1	VINYL	GWB (PTD.)	N/A	GWB (PTD.)	GWB (PTD.)	
107A	STORAGE	SEALED CONCRETE	VINYL	GWB (PTD.)	GWB (PTD.)	GWB (PTD.)	GWB (PTD.)	
107B	STORAGE	SEALED CONCRETE	VINYL	GWB (PTD.)	GWB (PTD.)	GWB (PTD.)	GWB (PTD.)	
108	MULTI - PURPOSE ROOM B	SPORTS FLOOR SF-2	VINYL	N/A	GWB (PTD.)	GWB (PTD.)	GWB (PTD.)	
108A	SPRINKLER	SEALED CONCRETE	VINYL	GWB (PTD.)	GWB (PTD.)	GWB (PTD.)	GWB (PTD.)	
110	CORRIDOR C	WALK OFF TILE	VINYL	GWB (PTD.)	GWB (PTD.)	GWB (PTD.)	GWB (PTD.)	
111	JAN.	SEALED CONCRETE	VINYL	GWB (PTD.)	GWB (PTD.)	GWB (PTD.)	GWB (PTD.)	
113	S. VEST.	ENTRY MAT	VINYL	GWB (PTD.)	GWB (PTD.)	GWB (PTD.)	GWB (PTD.)	
114	MEN'S	BURNISHED CONCRETE	C.T.	C.T. WAINSCOT / GWB (PTD.)	C.T. WAINSCOT / GWB (PTD.)	C.T. WAINSCOT / GWB (PTD.)	C.T. WAINSCOT / GWB (PTD.)	
115	WOMEN'S	BURNISHED CONCRETE	C.T.	C.T. WAINSCOT / GWB (PTD.)	C.T. WAINSCOT / GWB (PTD.)	C.T. WAINSCOT / GWB (PTD.)	C.T. WAINSCOT / GWB (PTD.)	
116	MULTI - PURPOSE ROOM D	FLOTEX TILE	VINYL	N/A	GWB (PTD.)	GWB (PTD.)	GWB (PTD.)	
116A	STORAGE	FLOTEX TILE	VINYL	GWB (PTD.)	GWB (PTD.)	GWB (PTD.)	GWB (PTD.)	
116B	STORAGE	FLOTEX TILE	VINYL	GWB (PTD.)	GWB (PTD.)	GWB (PTD.)	GWB (PTD.)	
116C	STORAGE	FLOTEX TILE	VINYL	GWB (PTD.)	GWB (PTD.)	GWB (PTD.)	GWB (PTD.)	
117	MULTI - PURPOSE ROOM C	FLOTEX TILE	VINYL	GWB (PTD.)	N/A	GWB (PTD.)	GWB (PTD.)	
118	CONCESSION	VCT-1	VINYL	GWB (PTD.)	GWB (PTD.)	GWB (PTD.)	GWB (PTD.)	
119	E. VEST.	ENTRY MAT	VINYL	CMU (PTD.)	STOREFRONT	STOREFRONT	STOREFRONT	
120	GYMNASIUM	WOOD SPORTS FLOOR	VINYL VENTED	CMU (PTD.)	CMU (PTD.)	CMU (PTD.)	CMU (PTD.)	
121	CORRIDOR A	SEALED CONCRETE	VINYL	GWB (PTD.)	GWB (PTD.)	GWB (PTD.)	GWB (PTD.)	
122	MECH / ELEC	SEALED CONCRETE	VINYL	GWB (PTD.)	GWB (PTD.)	GWB (PTD.)	GWB (PTD.)	
123	TEAM ROOM #1	VCT-2	VINYL	GWB (PTD.)	GWB (PTD.)	GWB (PTD.)	GWB (PTD.)	
124	TEAM ROOM #2	VCT-2	VINYL	GWB (PTD.)	GWB (PTD.)	GWB (PTD.)	GWB (PTD.)	
125	LAV A	VCT-2	VINYL	GWB (PTD.)	GWB (PTD.)	GWB (PTD.)	GWB (PTD.)	
126	LAV B	VCT-2	VINYL	GWB (PTD.)	GWB (PTD.)	GWB (PTD.)	GWB (PTD.)	
127	TEAM ROOM #3	VCT-2	VINYL	GWB (PTD.)	GWB (PTD.)	GWB (PTD.)	GWB (PTD.)	
128	TEAM ROOM #4	VCT-2	VINYL	GWB (PTD.)	GWB (PTD.)	GWB (PTD.)	GWB (PTD.)	
129	GYM STORAGE	SEALED CONCRETE	VINYL	GWB (PTD.)	GWB (PTD.)	CMU (PTD.)	GWB (PTD.)	

FINISH SCHEDULE NOTES:

- 1) SEE CEILING PLANS FOR CEILING FINISHES.
- 2) SEE SPECIFICATIONS FOR ADDITIONAL INFORMATION ON ALL FINISH MATERIALS AND INSTALLATION REQUIREMENTS.
- 3) PROVIDE MOISTURE RESISTANT GWB AT ALL RESTROOMS, JANITOR CLOSETS, AND WATER / SPRINKLER ENTRANCE AREAS.
- 4) FOR ALL FINISH FLOOR TYPE TRANSITIONS BETWEEN ROOMS, PROVIDE TRANSITION STRIP CENTERED UNDER DOOR.
- 5) PAINT THE FOLLOWING WORK WHERE EXPOSED IN PUBLIC AREAS, DO NOT PAINT IN SERVICE AREAS:


A) UNFINISHED OR PRIMED EQUIPMENT, INCLUDING PANELBOARDS AND SWITCH GEAR.

B) INSULATED AND UNINSULATED METAL AND PLASTIC PIPING.


C) PIPE HANGERS AND SUPPORTS.

D) METAL AND PLASTIC CONDUIT.


E) DUCT, EQUIPMENT, SUPPORTS, AND PAINTABLE INSULATION JACKET MATERIAL.

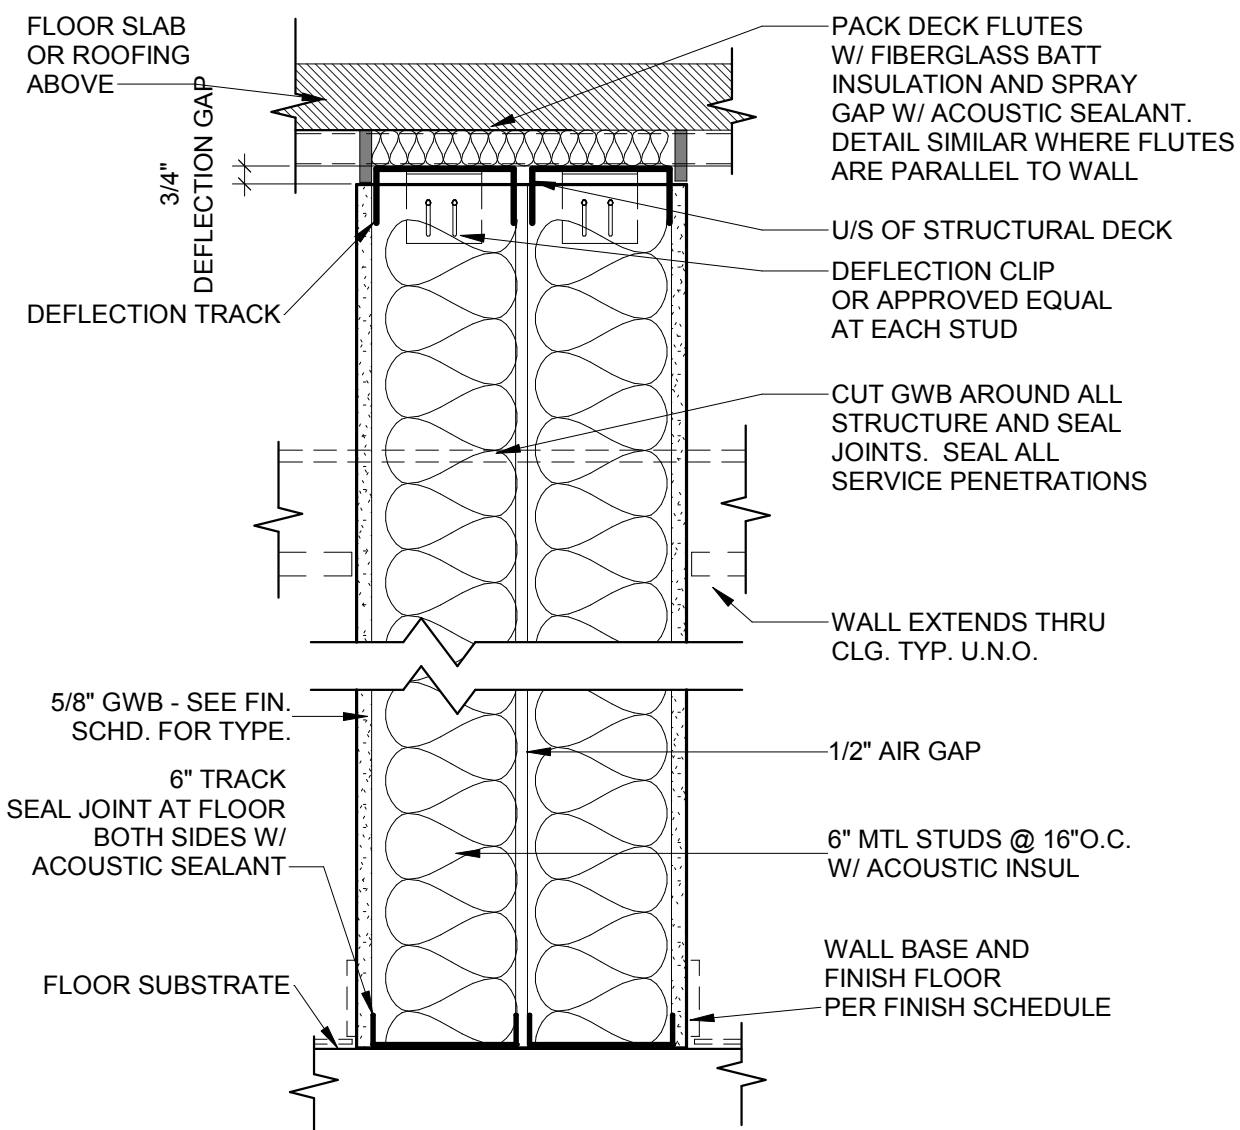


4 6" MTL. STUD / ACOUSTIC
THICKNESS: 7 1/4"
STC: 41

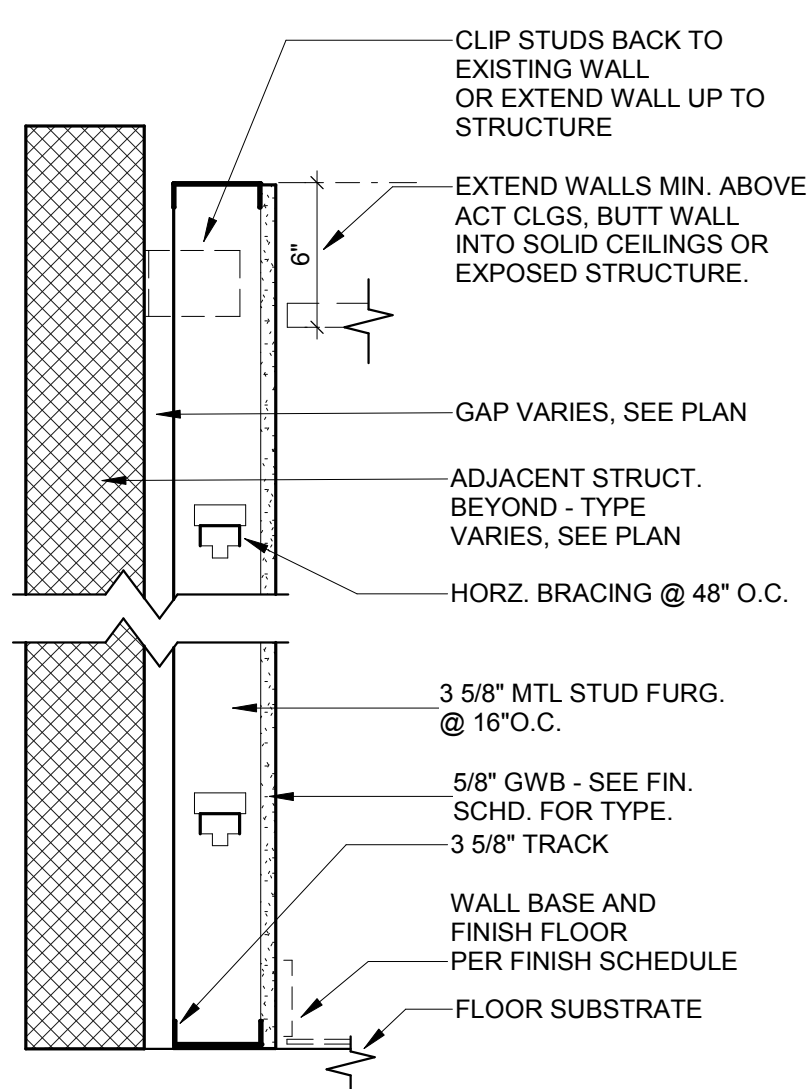


5 3 5/8" MTL. STUD FURRING
THICKNESS: 4 1/4"

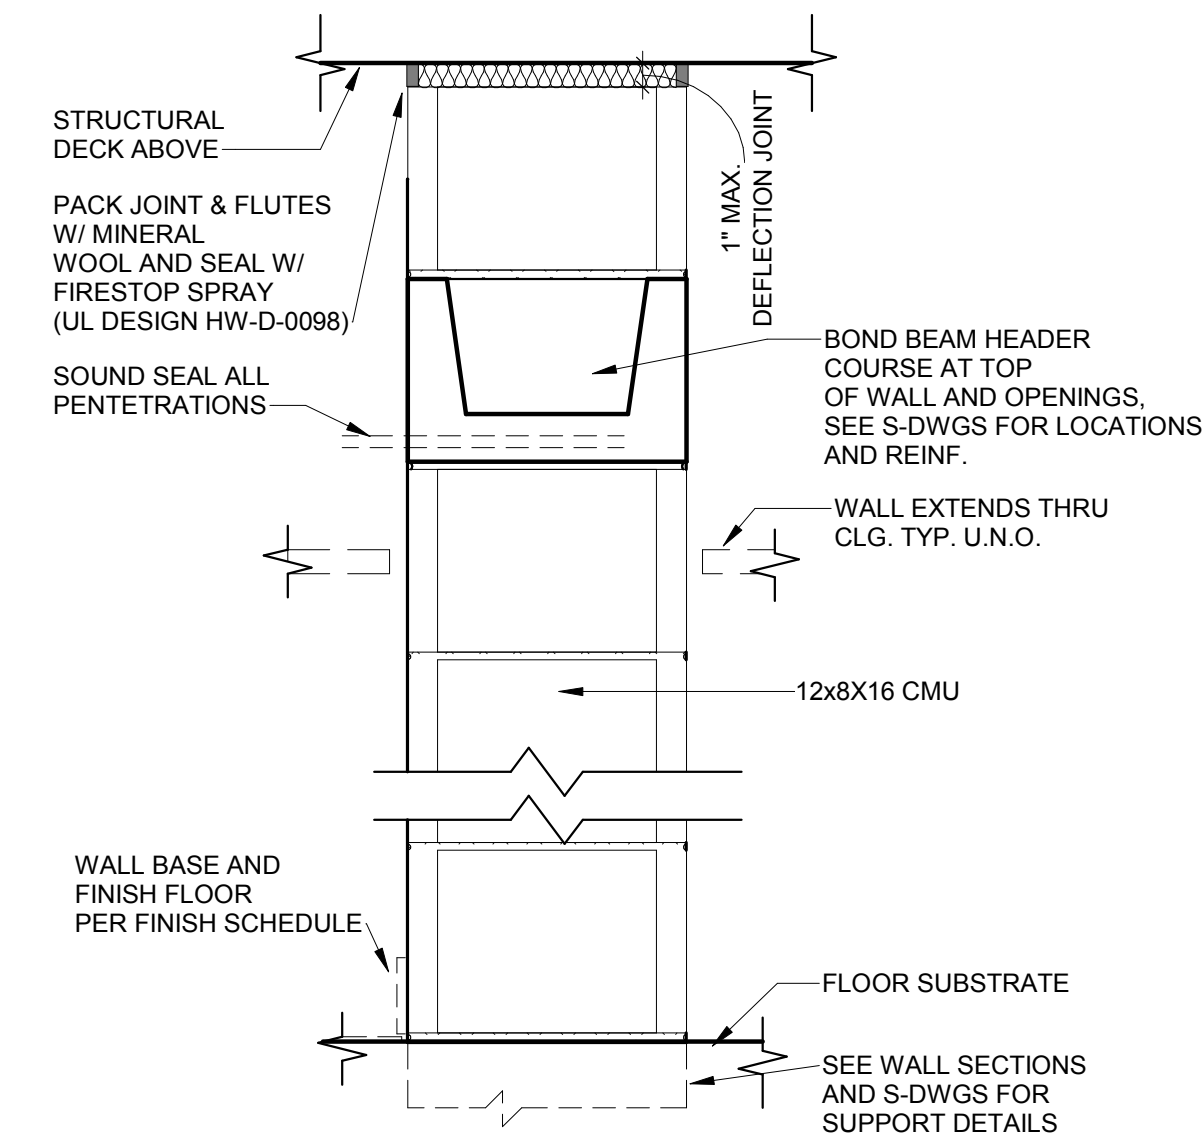


1 12" CMU - NON-RATED
STC: 50

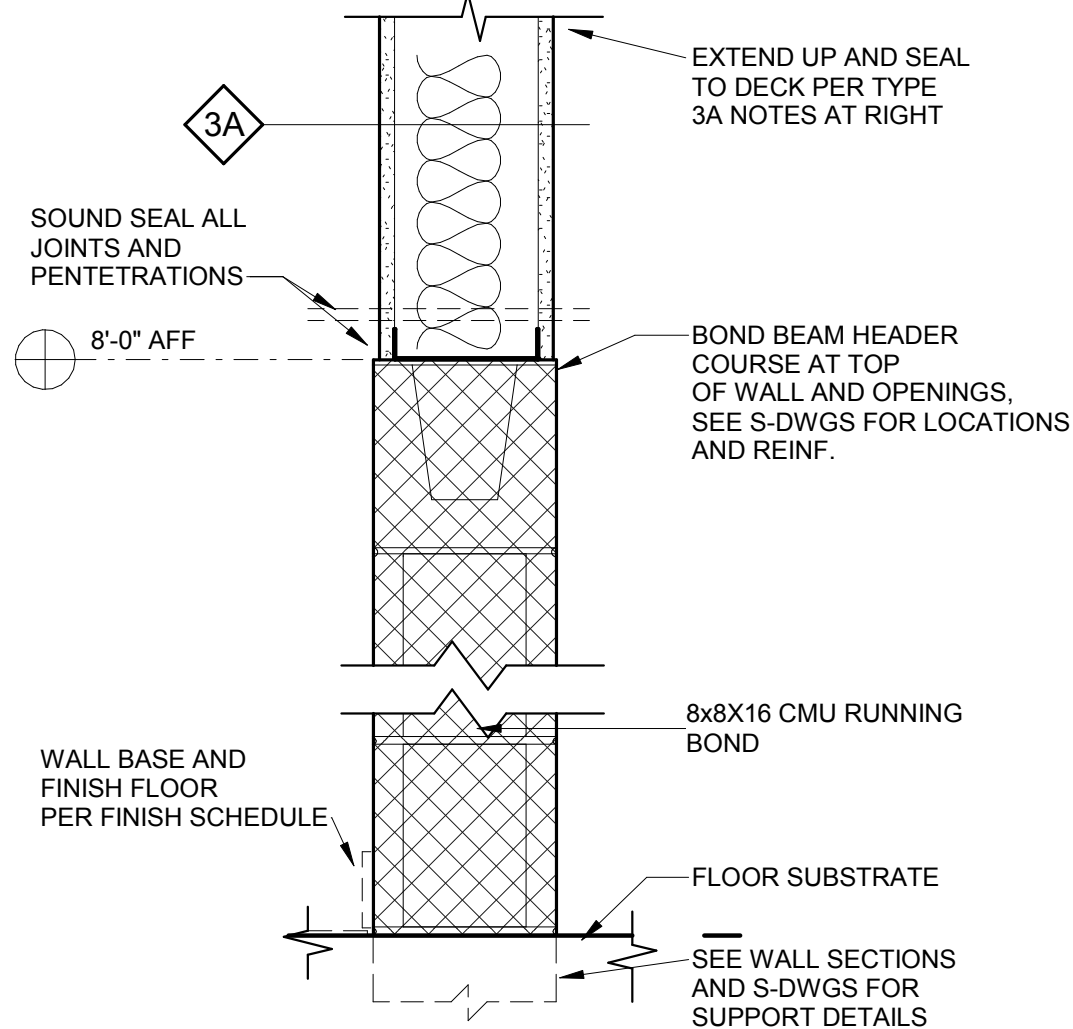


2 8" CMU - 6" MTL. STUD ABOVE, NON-RATED
STC: 50

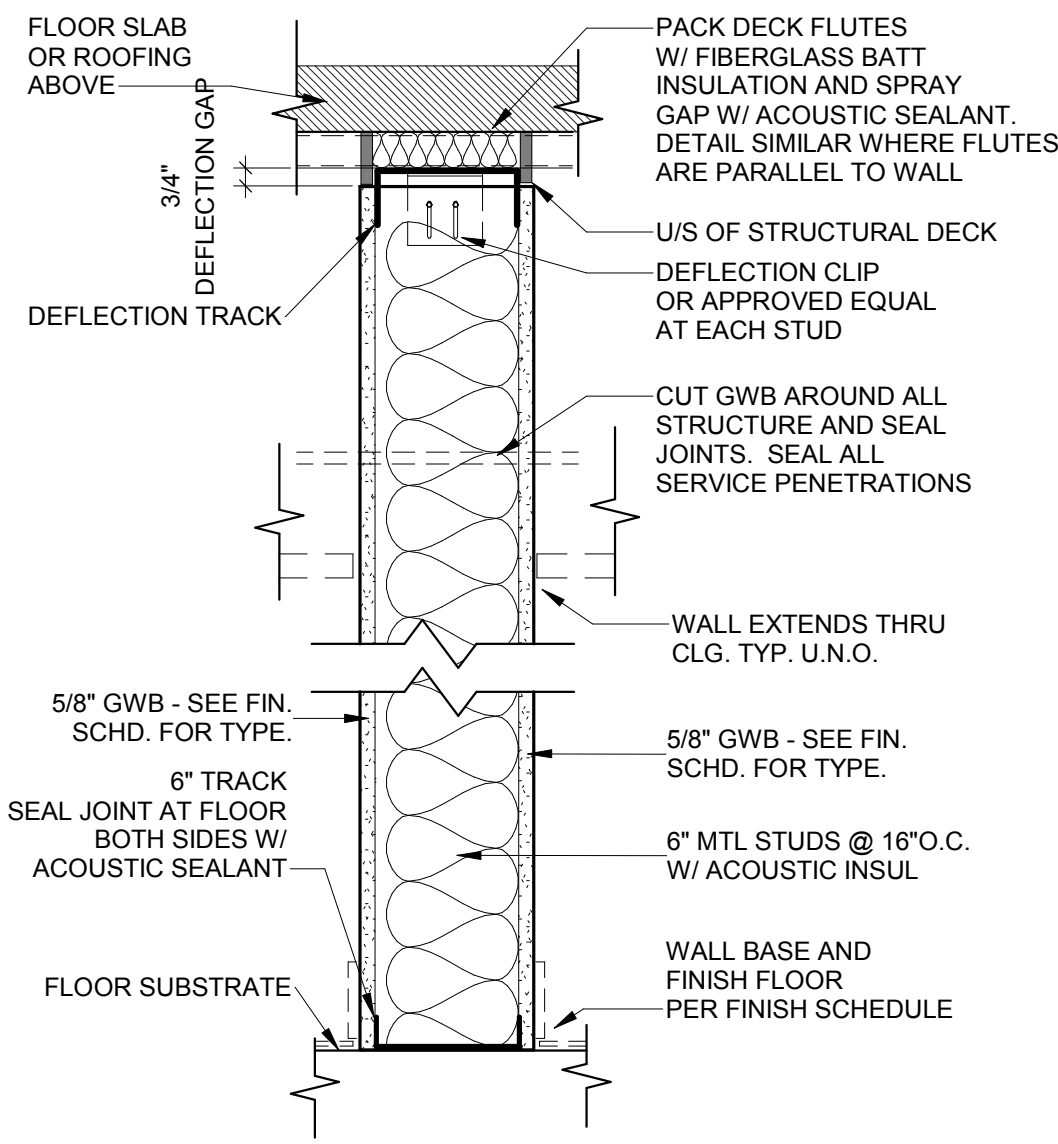


3A 6" MTL. STUD / ACOUSTIC
THICKNESS: 7 1/4"
STC: 41

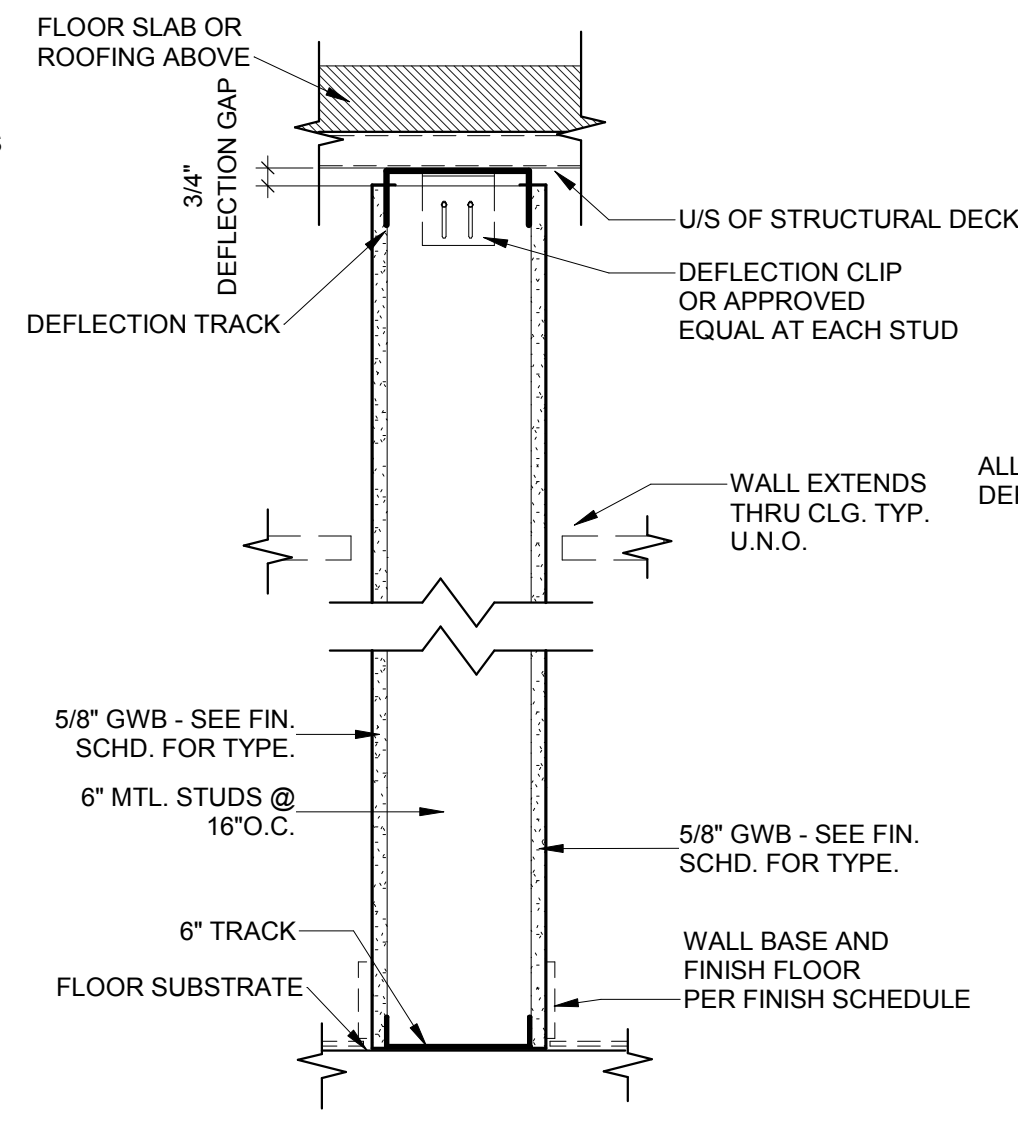


3 6" MTL. STUD
THICKNESS: 7 1/4"

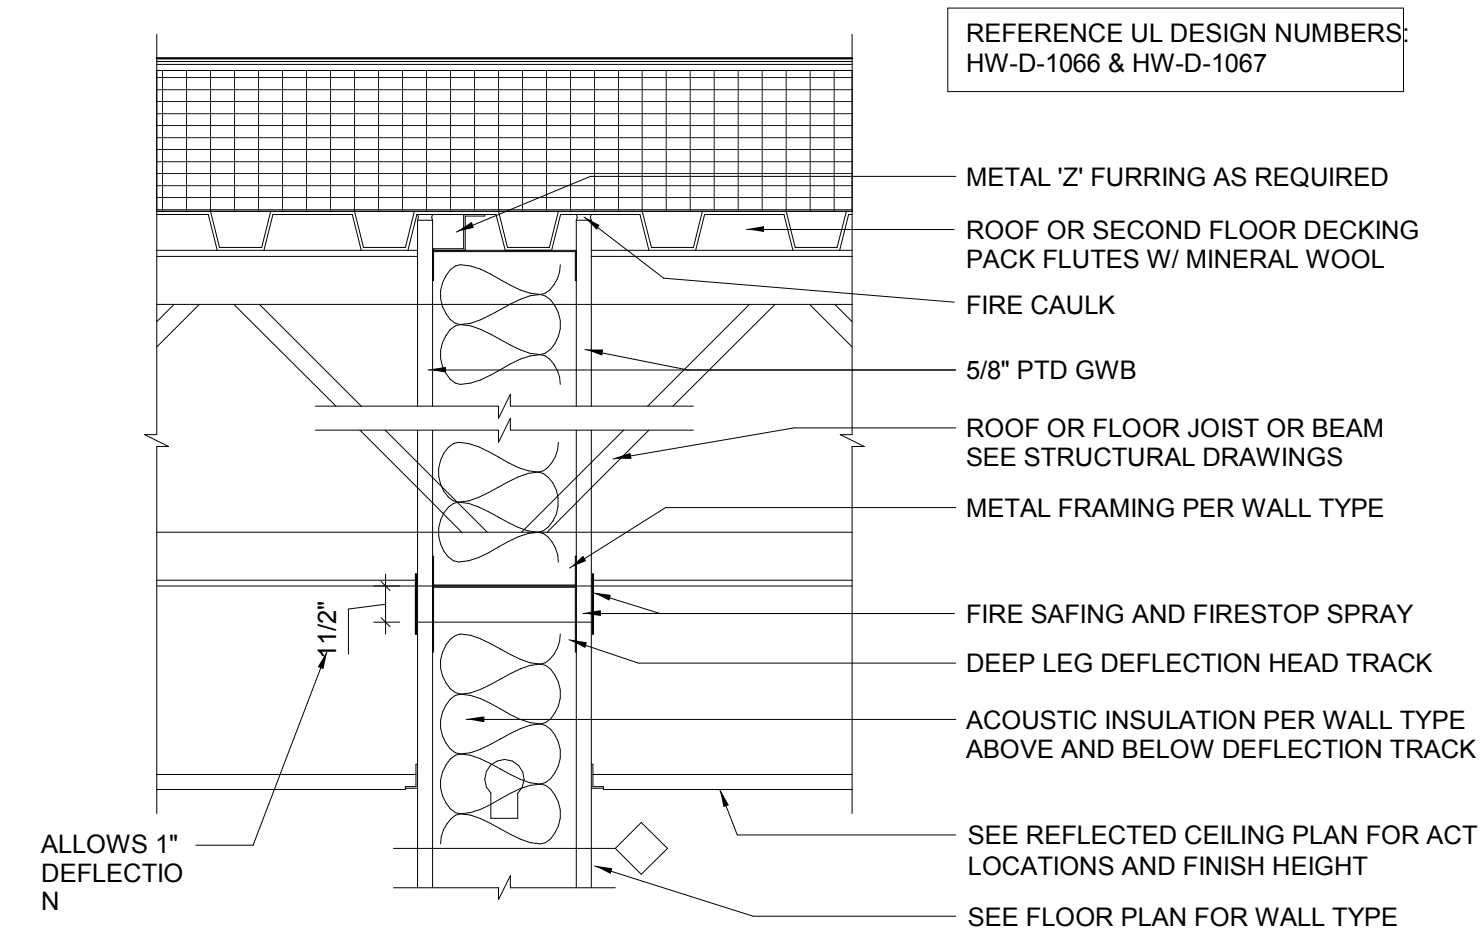

HEAD OF WALL PERPENDICULAR TO JOISTS OR BEAMS

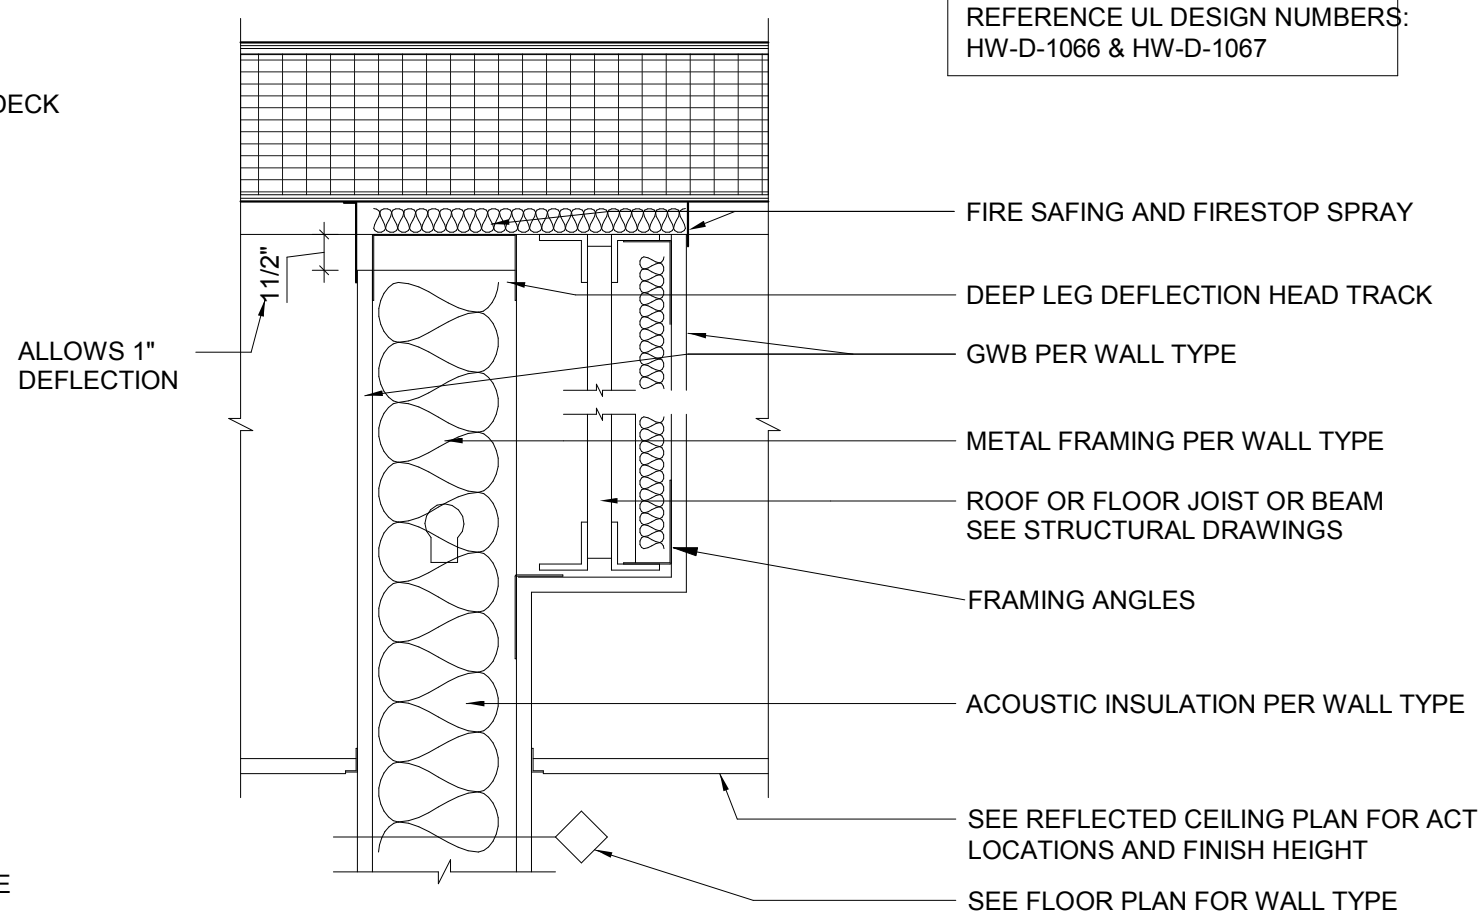

HEAD OF WALL PARALLEL AND OFFSET TO STRUCTURE

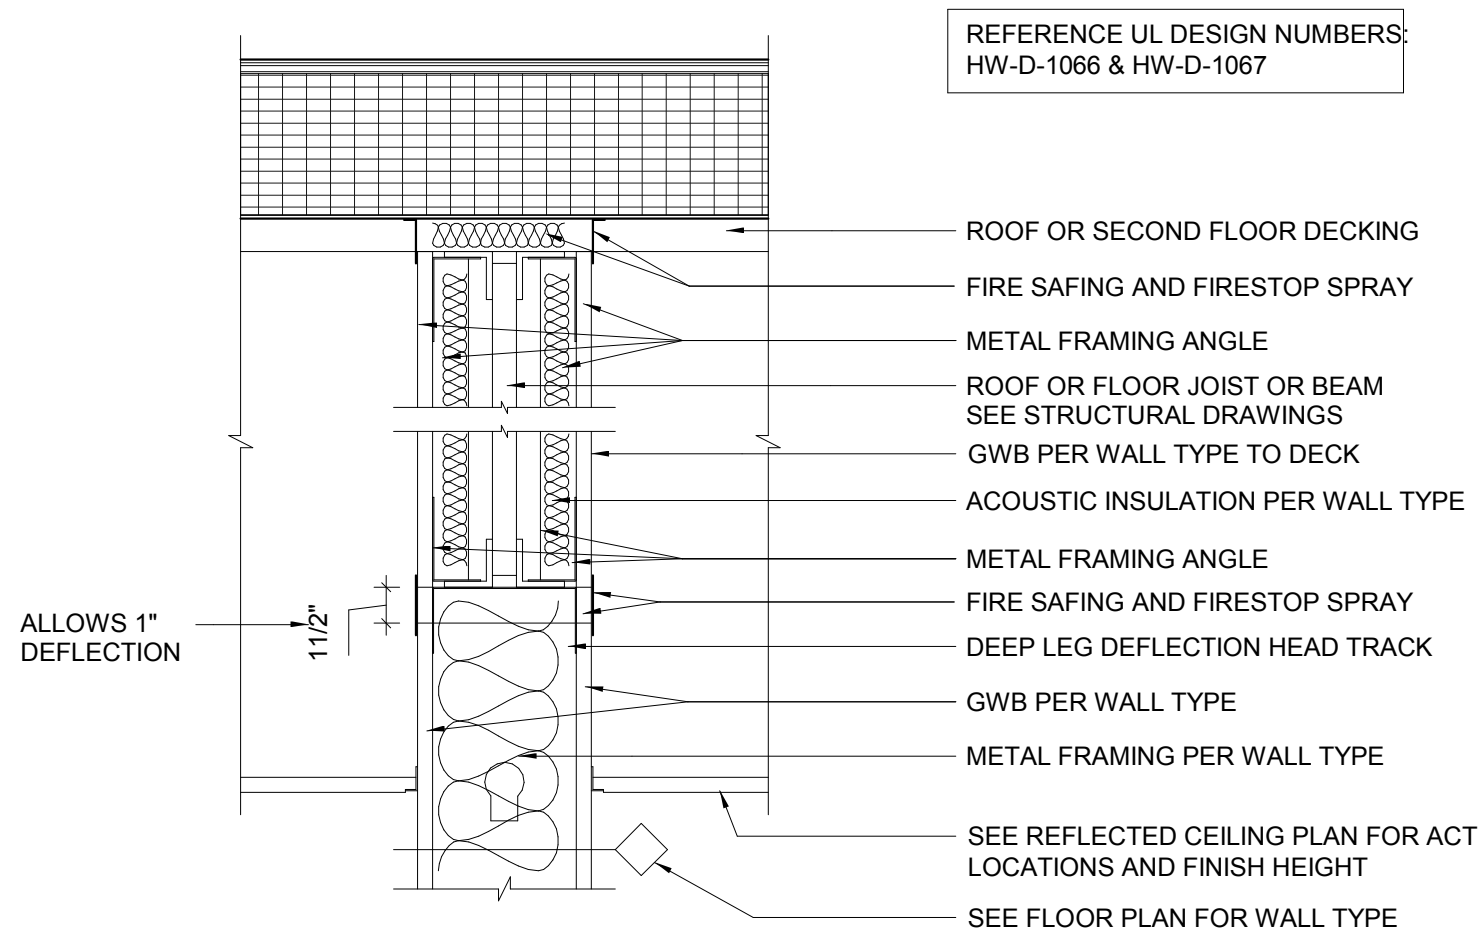

HEAD OF WALL PARALLEL AND UNDER STRUCTURE

1 TYPICAL HEAD OF WALL DETAILS
1 1/2" = 1'-0"

GENERAL WALL TYPE NOTES:

1. FOR LOAD-BEARING COLD-ROLLED LIGHT GAGE STEEL (LGS) WIND FRAMING, SEE WALL SECTIONS.
2. FOR ALL OTHER METAL STUD (MTL) INTERIOR FURRING AND PARTITION WALLS, SEE SECTION 092116.
3. STUD SIZES NOTED ARE FOR DESIGN INTENT AND BID PURPOSES ONLY. SEE SPECIFICATIONS FOR PERFORMANCE REQUIREMENTS TO BE VERIFIED BY THE SUBCONTRACTOR.
4. SEE PLANS, SECTIONS AND PLAN DETAILS FOR ADDITIONAL INFORMATION ON FURRING REQUIREMENTS.
5. SEE INTERIOR ELEVATIONS AND FINISH SCHEDULE FOR EXTENT OF WALL FINISHES AND BASE.

ACOUSTIC AND CONTROL JOINT NOTES:

1. ACOUSTIC WALL: SEAL PERIMETER OF WALLS AT OUTSIDE LAYER OF GWB BOTH SIDES OF WALL AT BASE, SIDES, AND ANY PENETRATIONS WITH ACOUSTIC SEALANT. SET BOTTOM TRACK IN BED OF ACOUSTICAL SEALANT AND PROVIDE SEALANT AT BASE OF GWB AND DECK.
2. CONTROL JOINTS - PROVIDE AT MIN. SPACING AND LOCATIONS REQUIRED BY SPECIFICATIONS AND AS INDICATED ON DRAWINGS.

BreadLoaf

Architects
Planners
Builders

1293 Route 7 South
Middlebury, VT 05753
P (802) 388-9871
F (802) 388-3815
www.breadloaf.com

Civil/Structural Engineer
Engineering Ventures, PC
85 Mechanic Street, Suite E2-3
Lebanon, NH 03766
P (603) 442-9333
F (603) 442-9331

Mechanical Engineer
VHV Company
16 Teegan Street
Winooski, VT 05404
P (802) 655-8805
F (802) 655-8809

Electrical Engineer
Interstate Electrical Services
15 Cote Lane
Bedford, NH 03110
P (603) 627-3230

Fire Protection Engineer
John L. Carter Sprinkler
Company, Inc.
9 Dunklee Road
Bow, NH 03304
P (603) 224-5438
F (603) 224-6481

© 2018, Bread Loaf Corporation
Seal:

Revised		
No.	Date	Description

NEWPORT
COMMUNITY CENTER

NEWPORT, NH


Proj. No: 18412 Drawn: SR
Date: 12/20/2018 Chk'd: JD

Partition Types
and Notes


A-9.2

DESIGN DEVELOPMENT


TOILET ACCESSORIES SCHEDULE				
Room & Type	Description	Qty.	Supplied By	Installed By
LAV A 125				
T-1	ADA TOILET 42" & 36" GRAB BARS	1	CONTRACTOR	CONTRACTOR
T-7	TOILET PAPER DISP. SURF. MTD.	1	OWNER	CONTRACTOR
T-14	SOAP DISPENSER SURF. MTD.	1	OWNER	CONTRACTOR
T-15	PAPER TOWEL DISP. SURF. MTD.	1	OWNER	CONTRACTOR
T-22	24" X 36" UNIT MIRROR	1	CONTRACTOR	CONTRACTOR
T-29	18"L VERT S.S. GRAB BAR	1	CONTRACTOR	CONTRACTOR
LAV B 126				
T-1	ADA TOILET 42" & 36" GRAB BARS	1	CONTRACTOR	CONTRACTOR
T-7	TOILET PAPER DISP. SURF. MTD.	1	OWNER	CONTRACTOR
T-14	SOAP DISPENSER SURF. MTD.	1	OWNER	CONTRACTOR
T-15	PAPER TOWEL DISP. SURF. MTD.	1	OWNER	CONTRACTOR
T-22	24" X 36" UNIT MIRROR	1	CONTRACTOR	CONTRACTOR
T-29	18"L VERT S.S. GRAB BAR	1	CONTRACTOR	CONTRACTOR
MEN'S 114				
T-1	ADA TOILET 42" & 36" GRAB BARS	1	CONTRACTOR	CONTRACTOR
T-7	TOILET PAPER DISP. SURF. MTD.	3	OWNER	CONTRACTOR
T-14	SOAP DISPENSER SURF. MTD.	2	OWNER	CONTRACTOR
T-15	PAPER TOWEL DISP. SURF. MTD.	1	OWNER	CONTRACTOR
T-16	BABY CHANGING STATION SURF. MTD.	1	CONTRACTOR	CONTRACTOR
T-20	30" X 40" UNIT MIRROR	3	CONTRACTOR	CONTRACTOR
T-29	18"L VERT S.S. GRAB BAR	1	CONTRACTOR	CONTRACTOR
SHOWER A 105				
T-1	ADA TOILET 42" & 36" GRAB BARS	1	CONTRACTOR	CONTRACTOR
T-14	SOAP DISPENSER SURF. MTD.	1	OWNER	CONTRACTOR
T-15	PAPER TOWEL DISP. SURF. MTD.	1	OWNER	CONTRACTOR
T-22	24" X 36" UNIT MIRROR	1	CONTRACTOR	CONTRACTOR
T-29	18"L VERT S.S. GRAB BAR	1	CONTRACTOR	CONTRACTOR
SHOWER B 106				
T-1	ADA TOILET 42" & 36" GRAB BARS	1	CONTRACTOR	CONTRACTOR
T-14	SOAP DISPENSER SURF. MTD.	1	OWNER	CONTRACTOR
T-15	PAPER TOWEL DISP. SURF. MTD.	1	OWNER	CONTRACTOR
T-22	24" X 36" UNIT MIRROR	1	CONTRACTOR	CONTRACTOR
T-29	18"L VERT S.S. GRAB BAR	1	CONTRACTOR	CONTRACTOR
WOMEN'S 115				
T-1	ADA TOILET 42" & 36" GRAB BARS	1	CONTRACTOR	CONTRACTOR
T-7	TOILET PAPER DISP. SURF. MTD.	5	OWNER	CONTRACTOR
T-14	SOAP DISPENSER SURF. MTD.	2	OWNER	CONTRACTOR
T-15	PAPER TOWEL DISP. SURF. MTD.	1	OWNER	CONTRACTOR
T-16	BABY CHANGING STATION SURF. MTD.	1	CONTRACTOR	CONTRACTOR
T-20	30" X 40" UNIT MIRROR	3	CONTRACTOR	CONTRACTOR
T-29	18"L VERT S.S. GRAB BAR	1	CONTRACTOR	CONTRACTOR

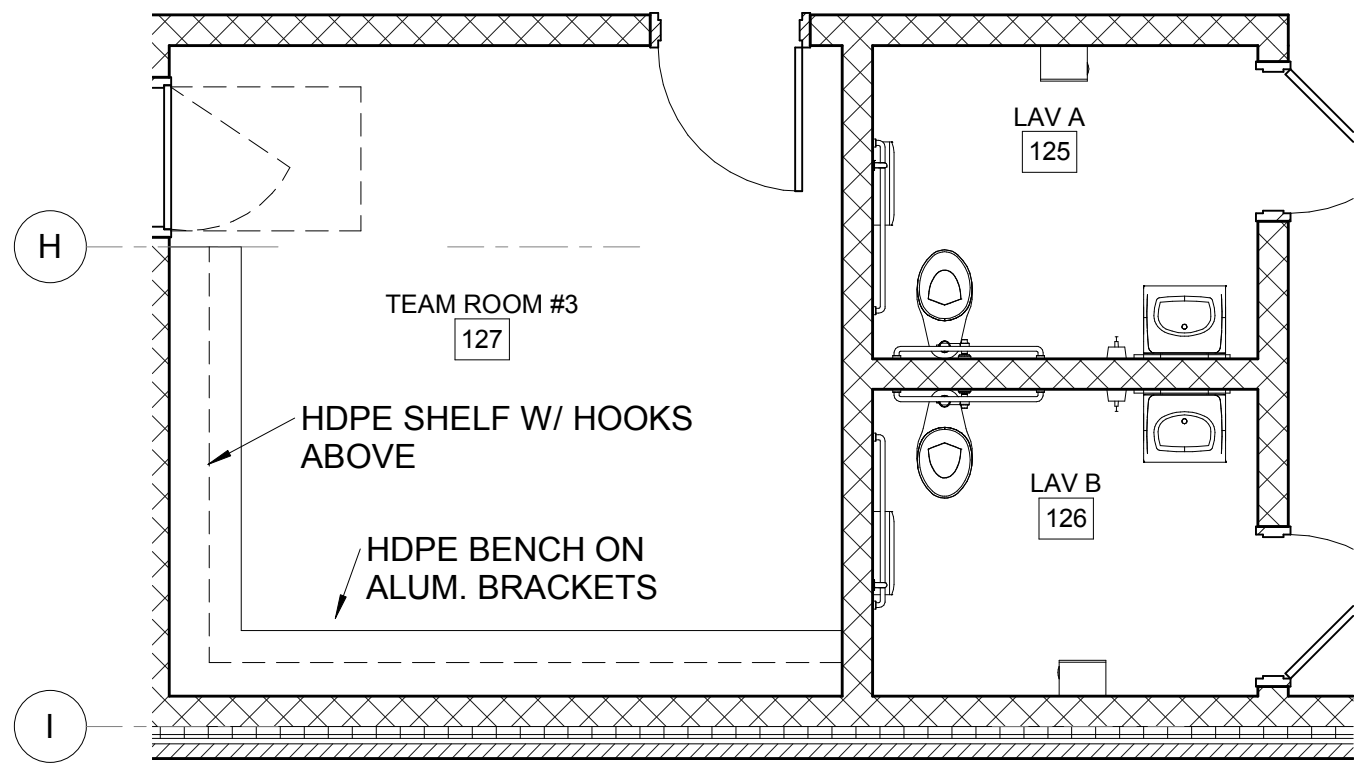


15 TEAM ROOM / LAVATORY PLAN
A-2.1A-9.3 1/4" = 1'-0"

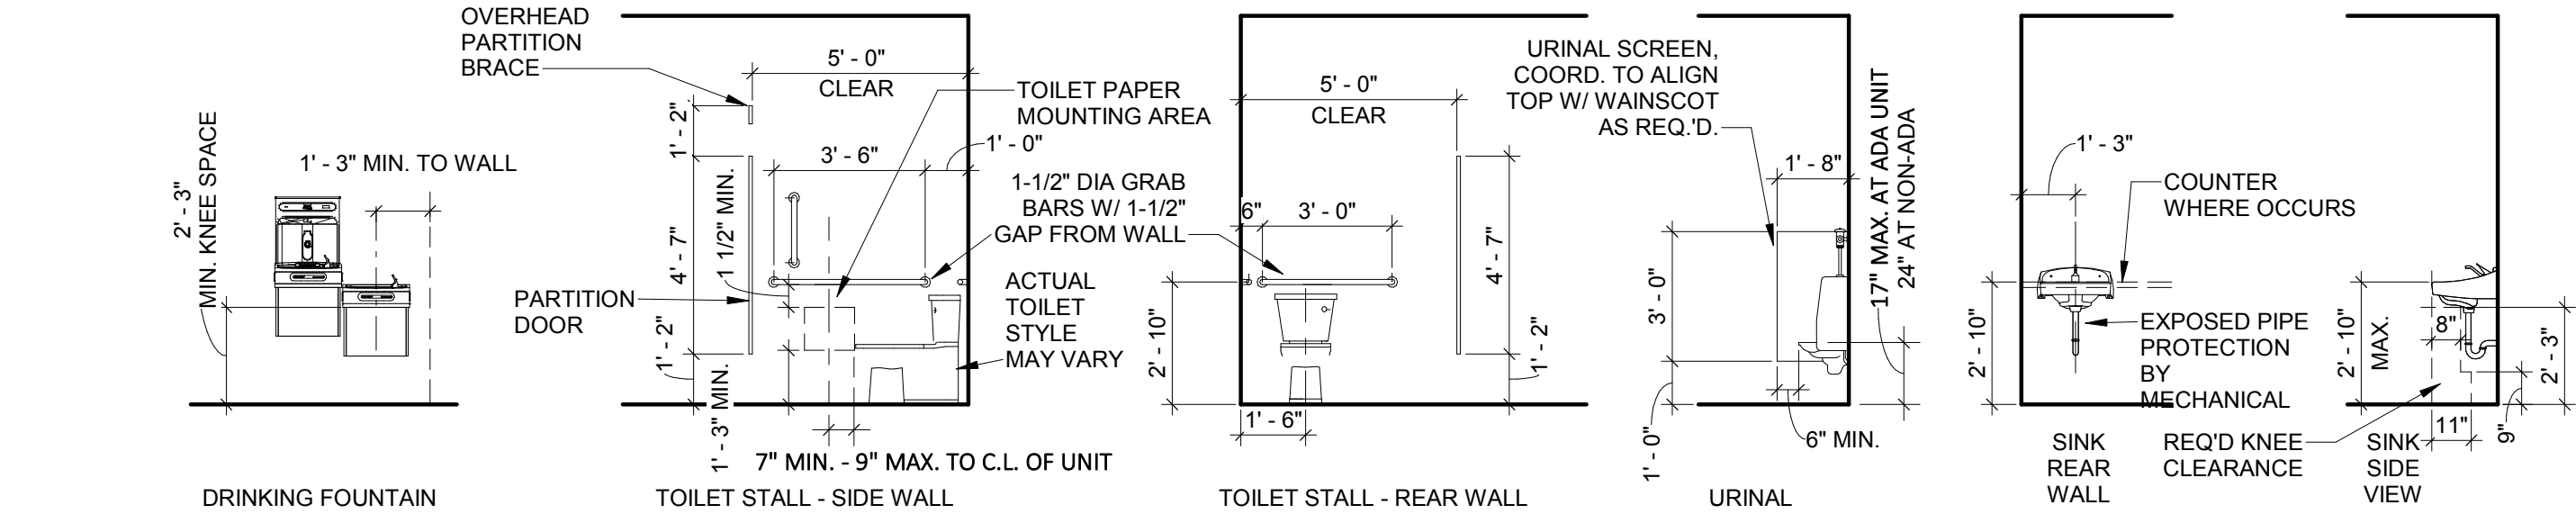


TYPICAL PLUMBING FIXTURES AND ACCESSORIES MOUNTING HEIGHTS

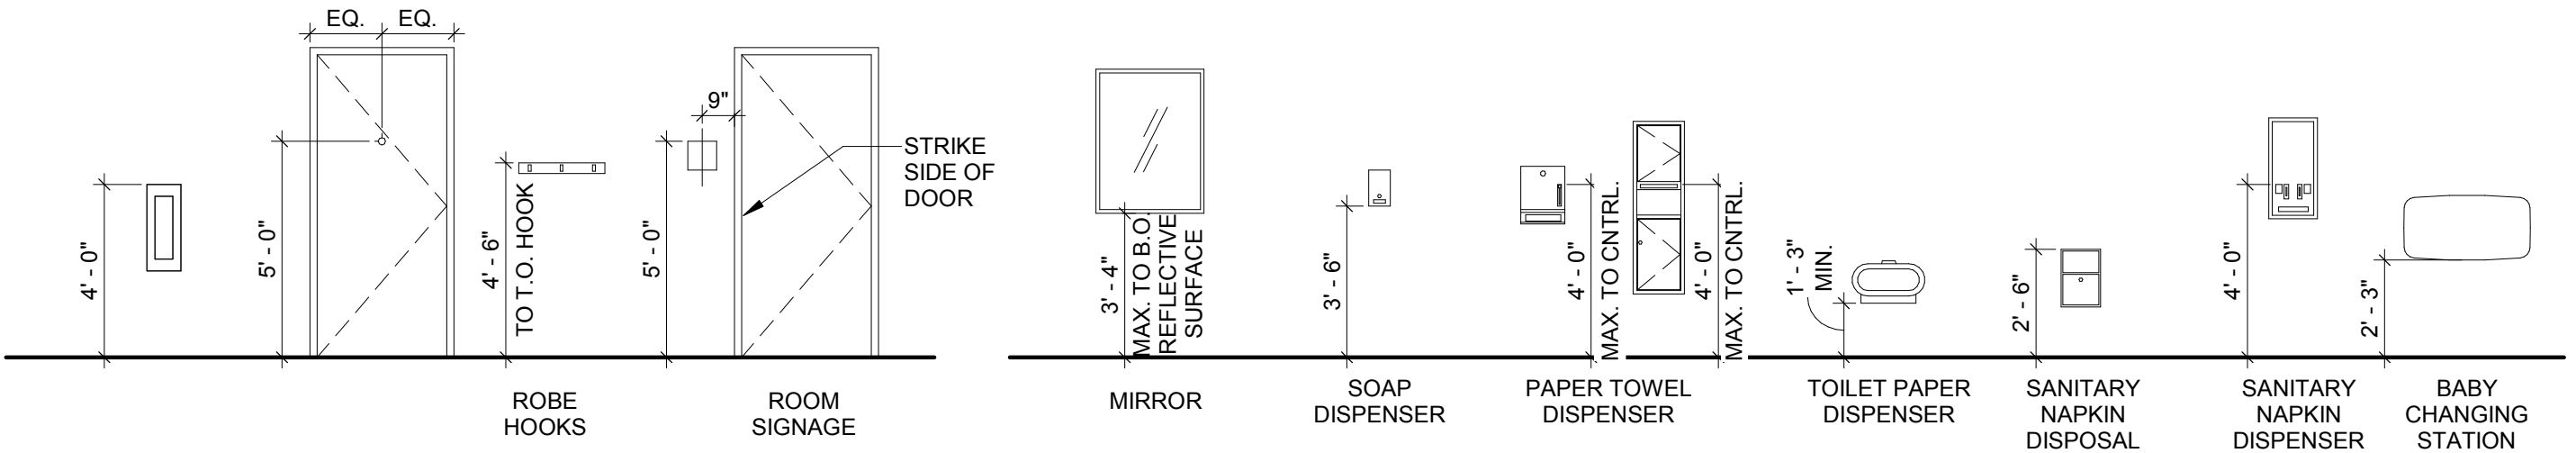


TYPICAL SPECIALTIES MOUNTING HEIGHTS

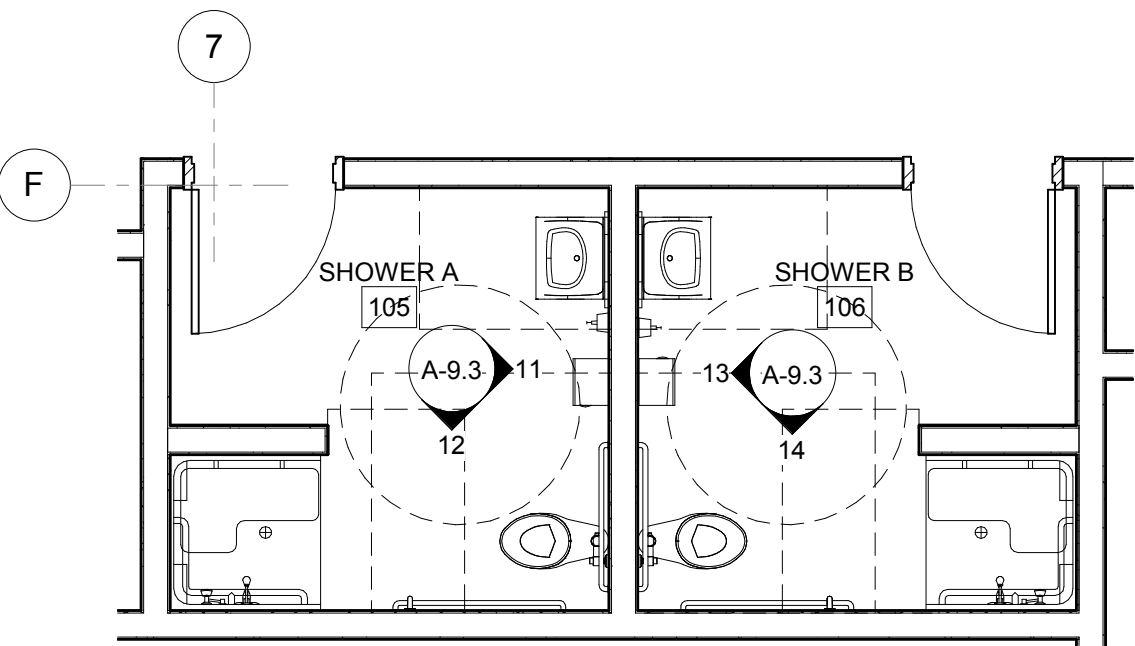


10 ENLARGED SHOWER ROOM PLANS
A-2.1A-9.3 1/4" = 1'-0"

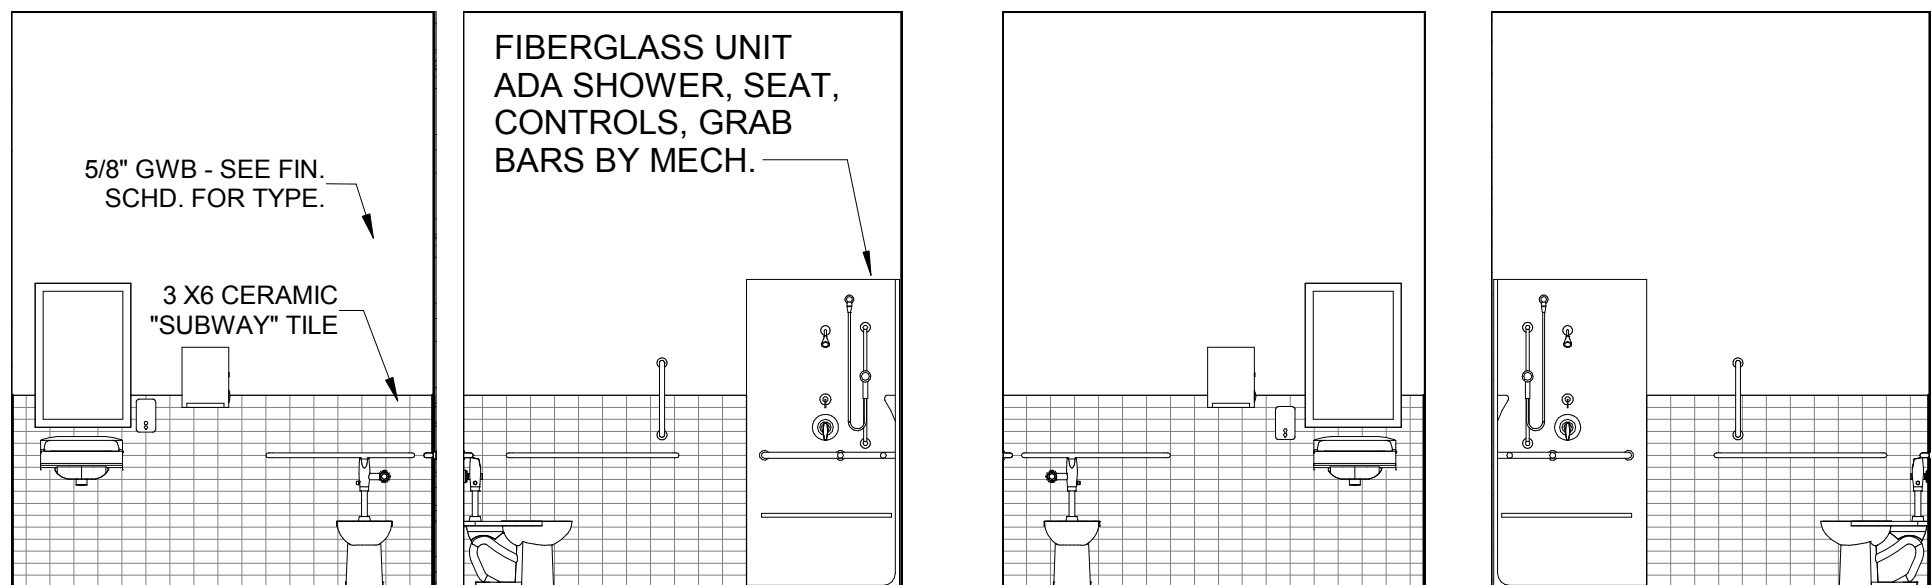


11 SHOWER A SOUTH 1/4" = 1'-0"
12 SHOWER A WEST 1/4" = 1'-0"
13 SHOWER B NORTH 1/4" = 1'-0"
14 SHOWER B WEST 1/4" = 1'-0"

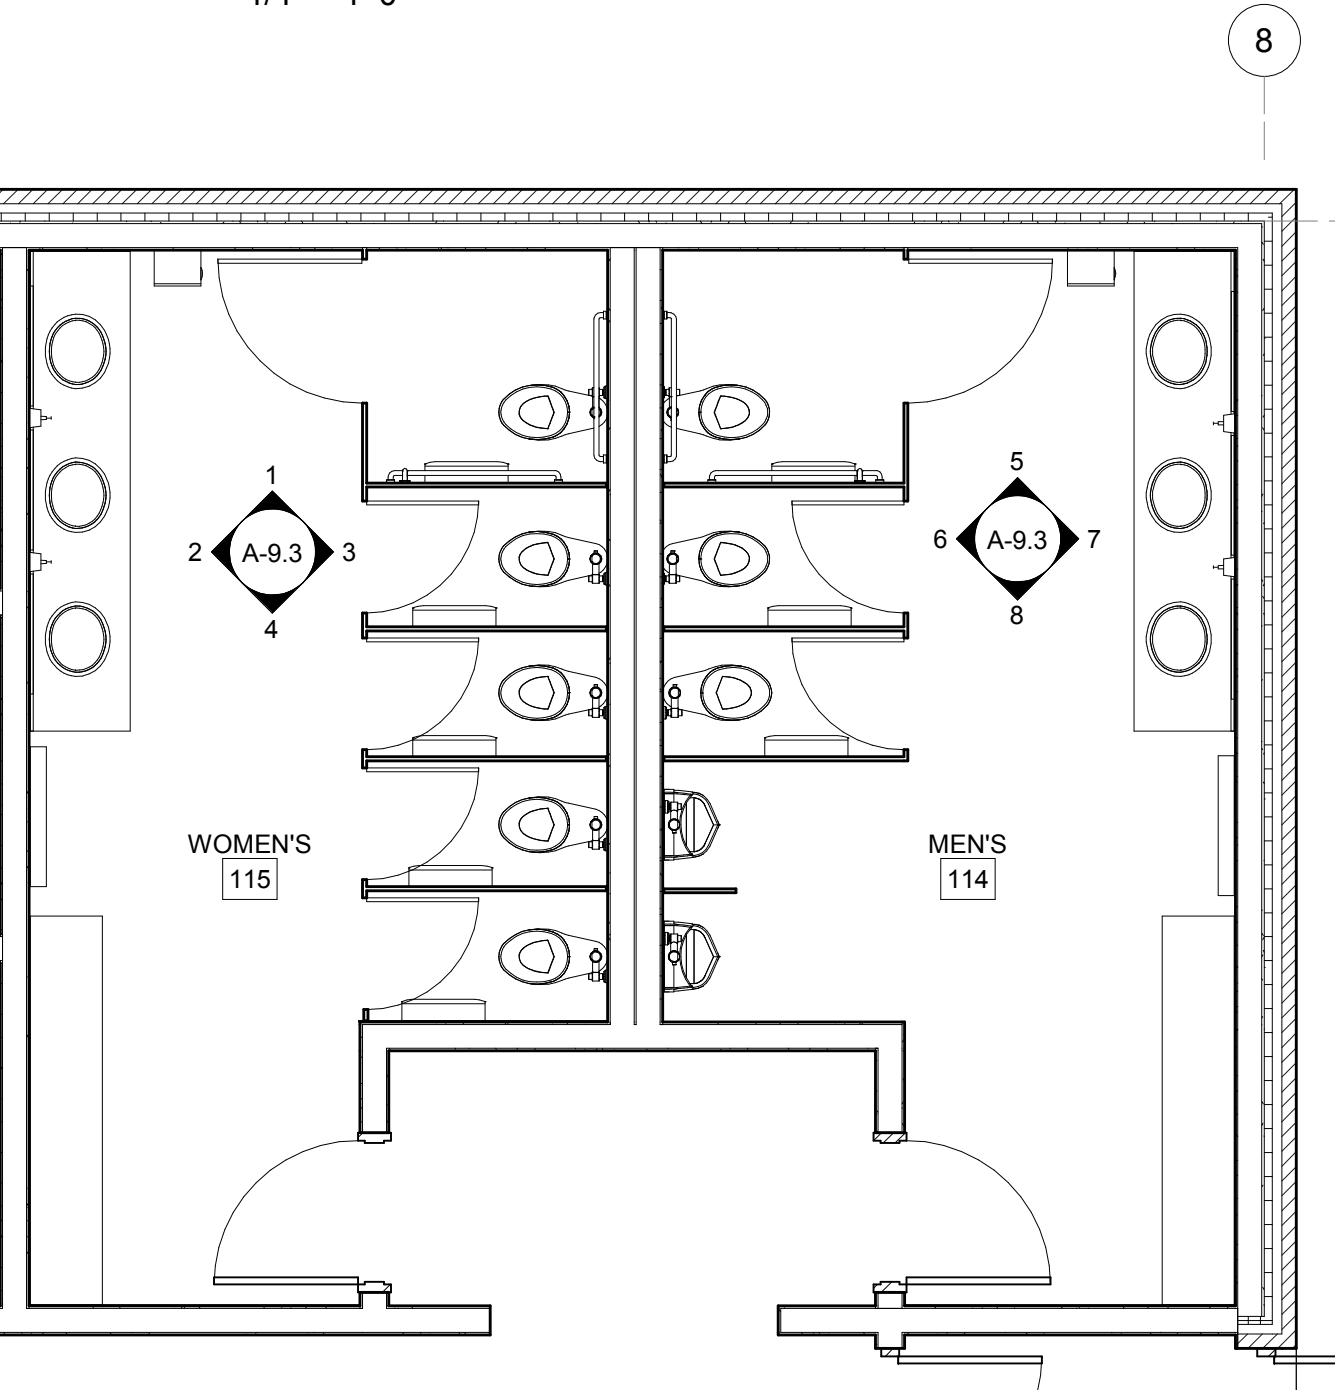


9 ENLARGED RESTROOM PLAN
A-2.1A-9.3 1/4" = 1'-0"

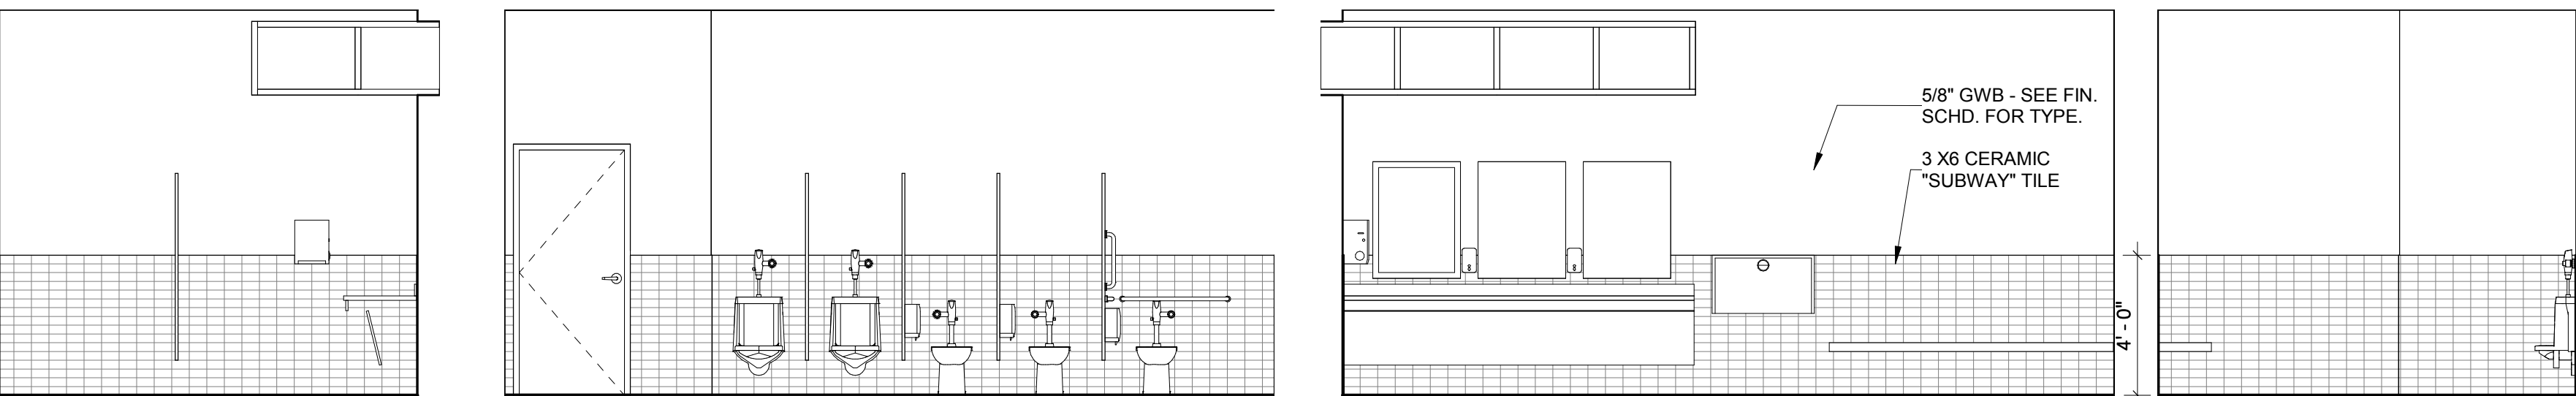


5 MENS EAST ELEVATION 1/4" = 1'-0"
6 MENS NORTH ELEVATION 1/4" = 1'-0"
7 MENS SOUTH ELEVATION 1/4" = 1'-0"
8 MENS WEST ELEVATION 1/4" = 1'-0"

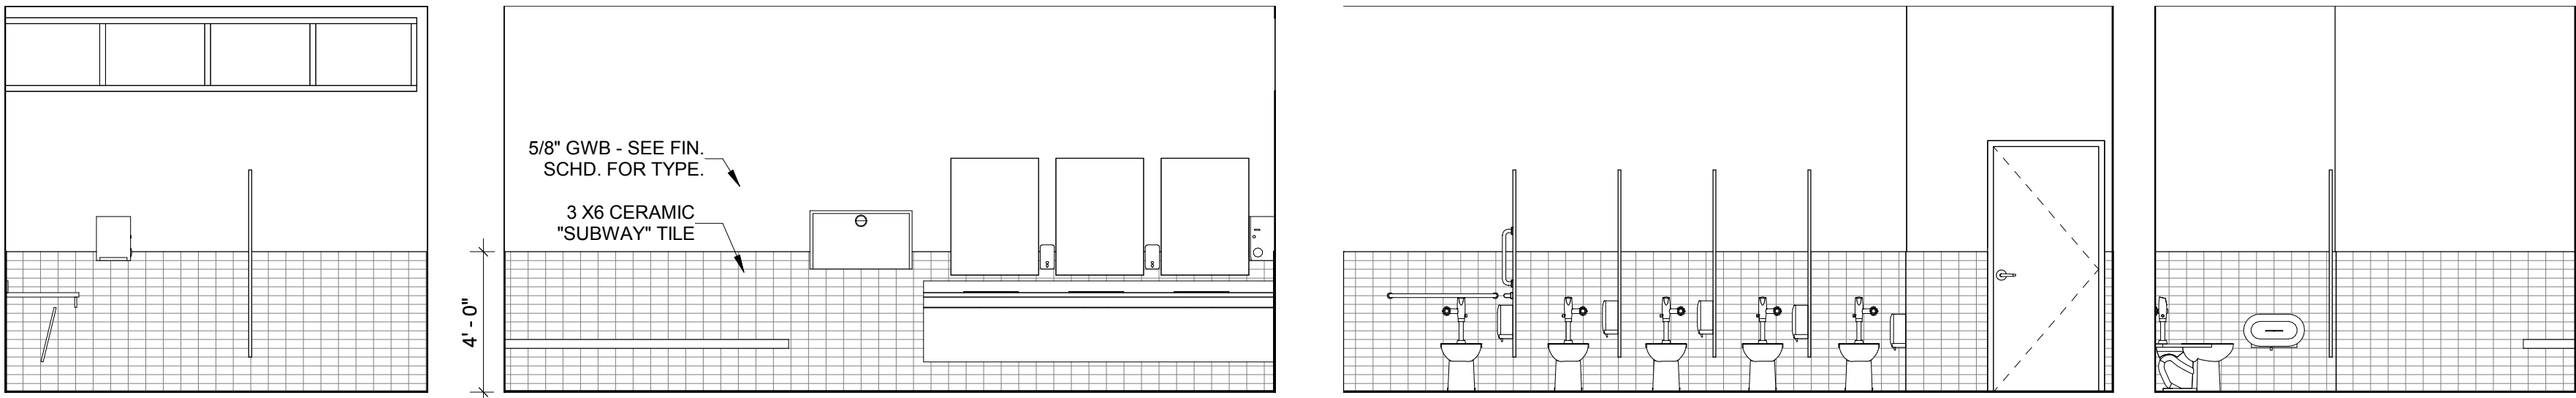

1 WOMENS EAST ELEVATION 1/4" = 1'-0"
2 WOMENS NORTH ELEVATION 1/4" = 1'-0"
3 WOMENS SOUTH ELEVATION 1/4" = 1'-0"
4 WOMENS WEST ELEVATION 1/4" = 1'-0"

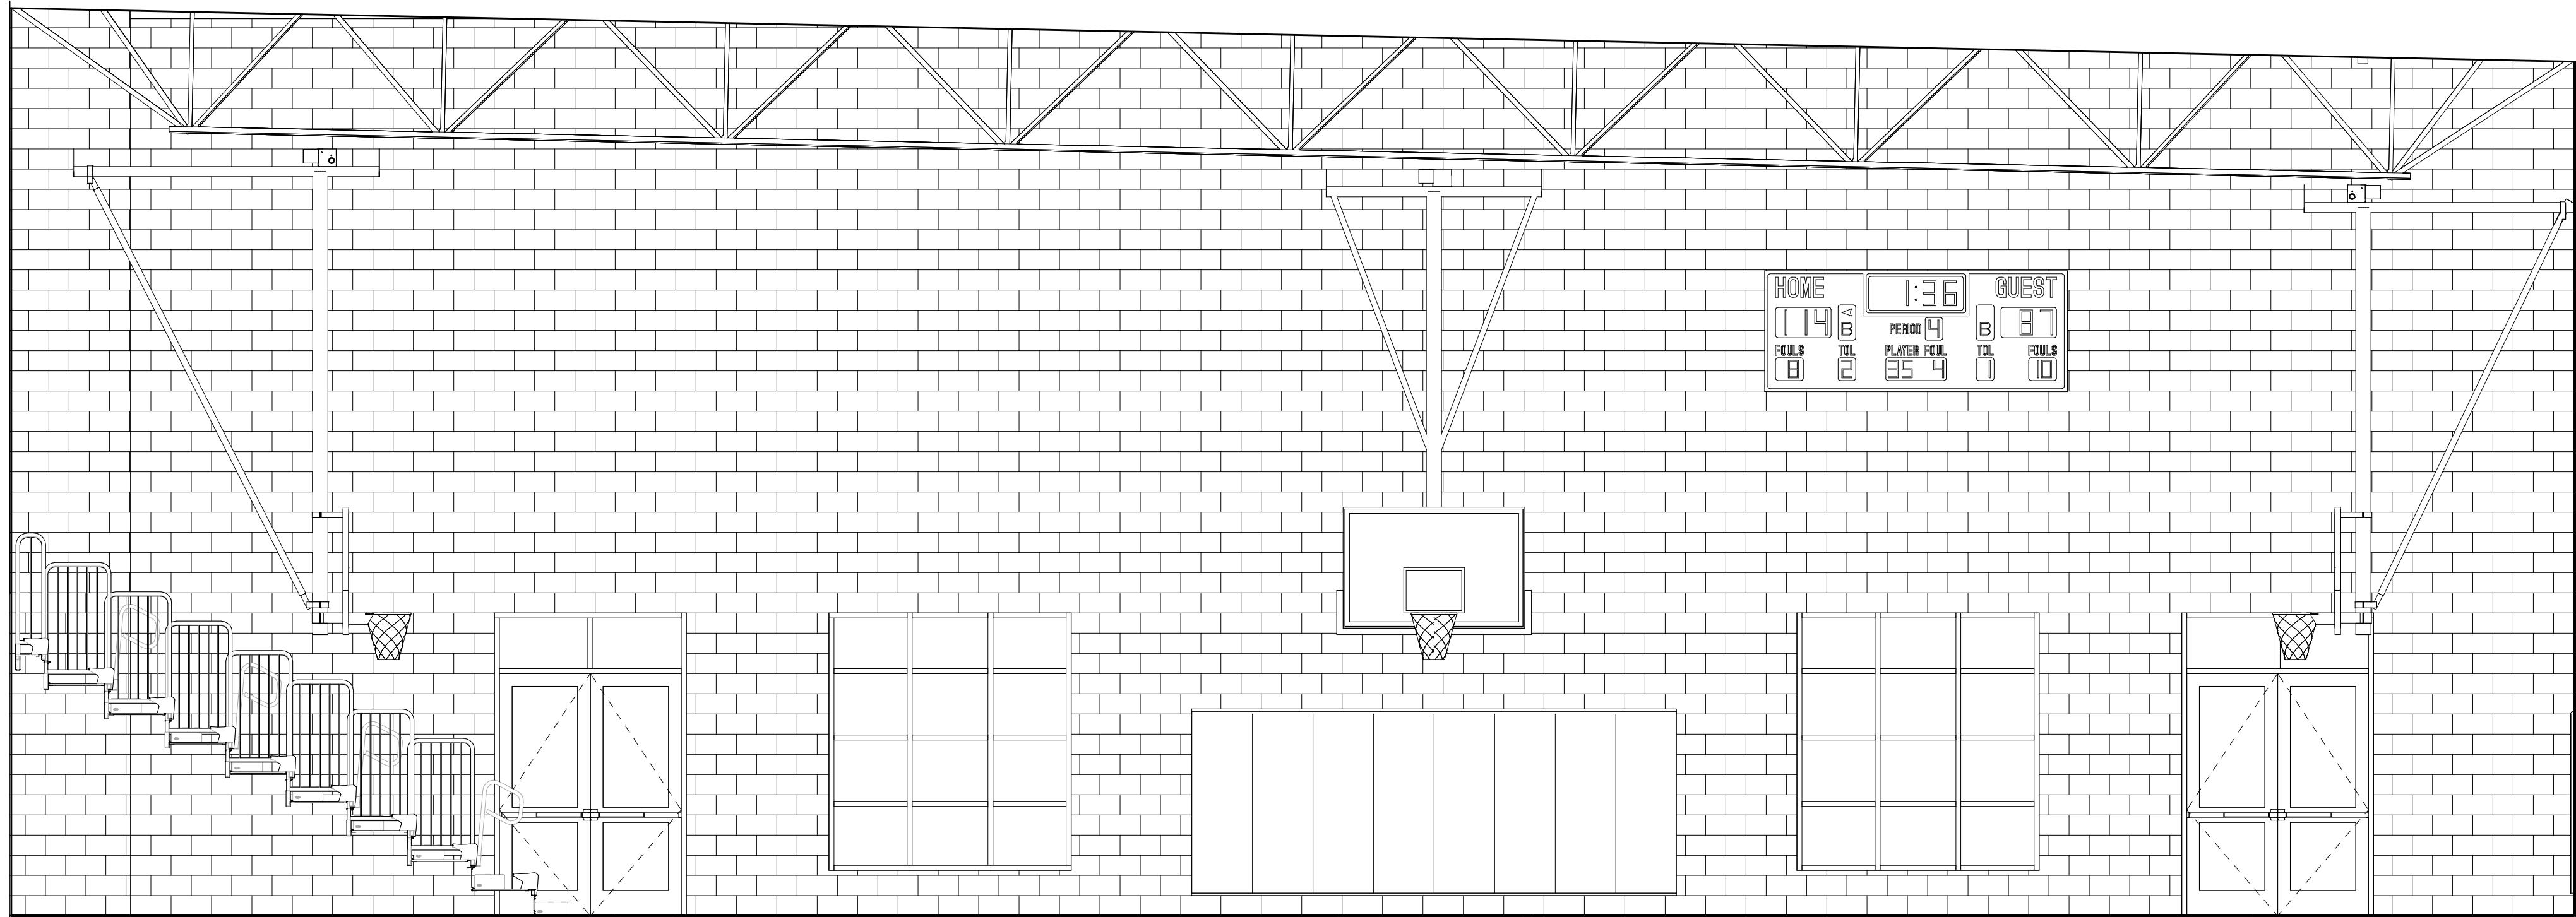

2 GYMNASIUM SOUTH ELEVATION
A2.1/A3.4 1/4" = 1'-0"

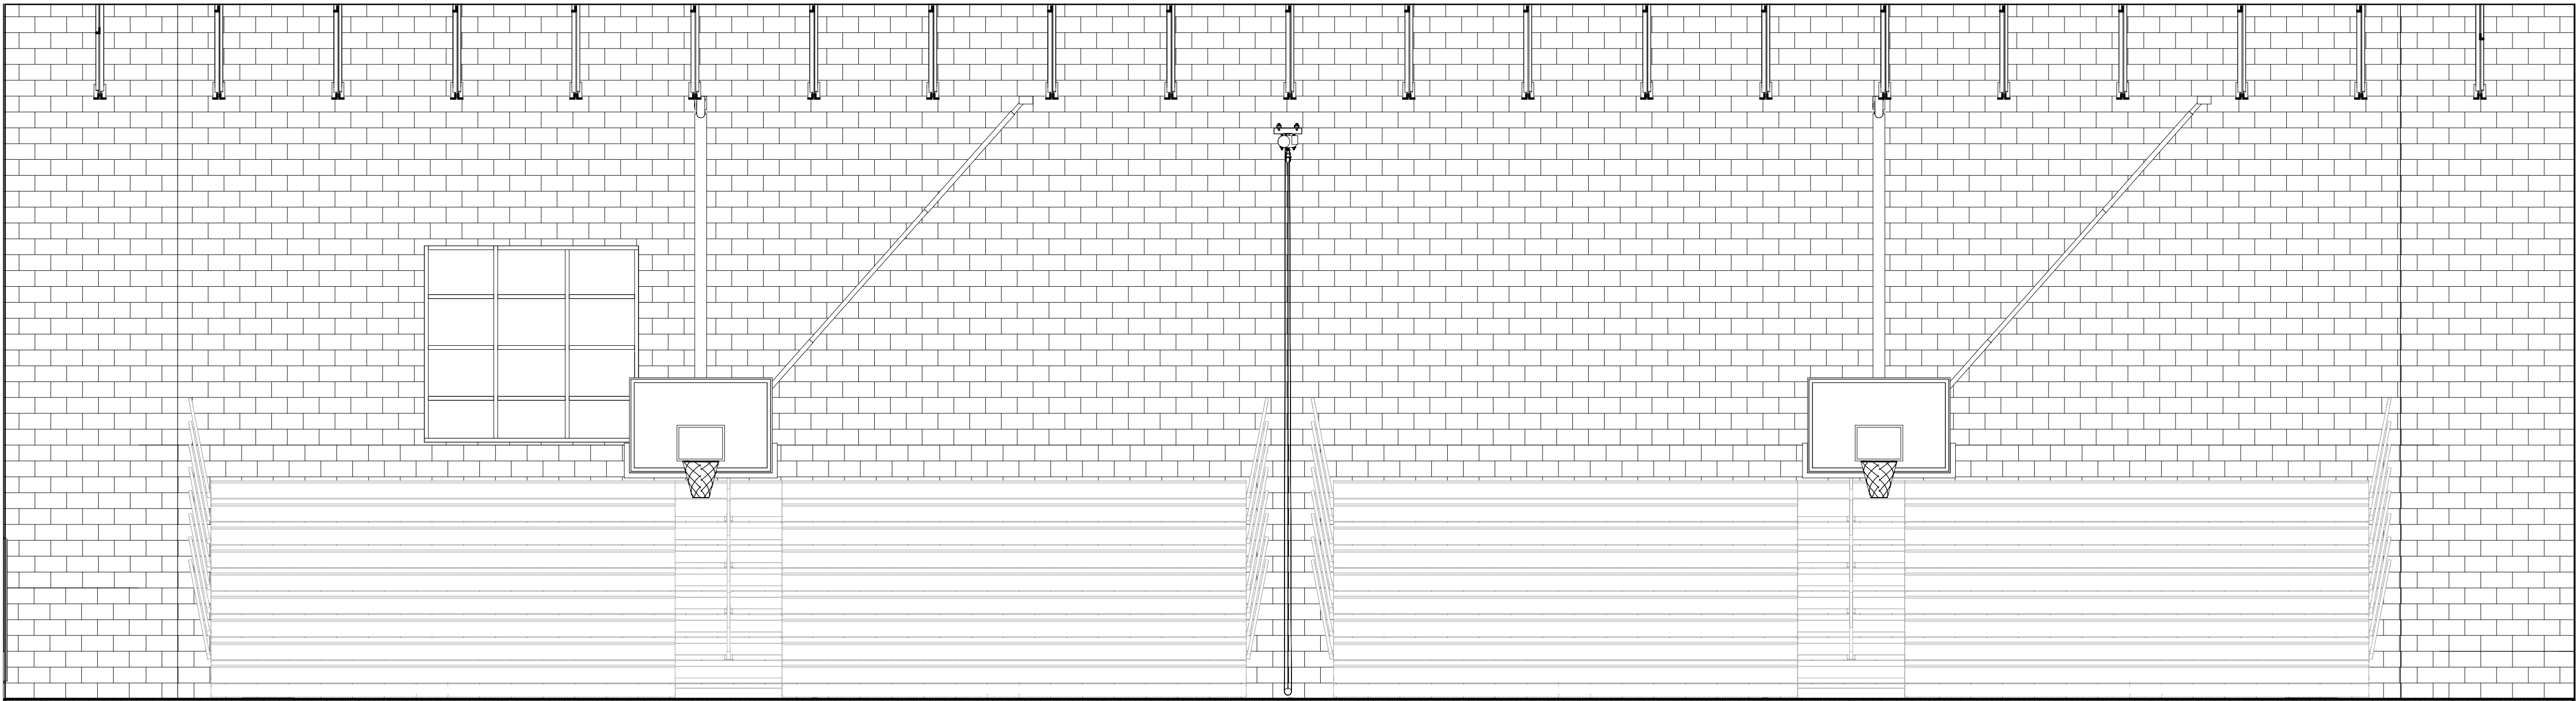

1 GYMNASIUM EAST ELEVATION
A2.1/A3.4 1/4" = 1'-0"

DESIGN DEVELOPMENT

Revised
No. Date Description


NEWPORT
COMMUNITY CENTER

NEWPORT, NH


Proj. No: 18412 Drawn: SR
Date: 12/20/2018 Chk'd: JD

Gymnasium
Interior
Elevations

A-9.4

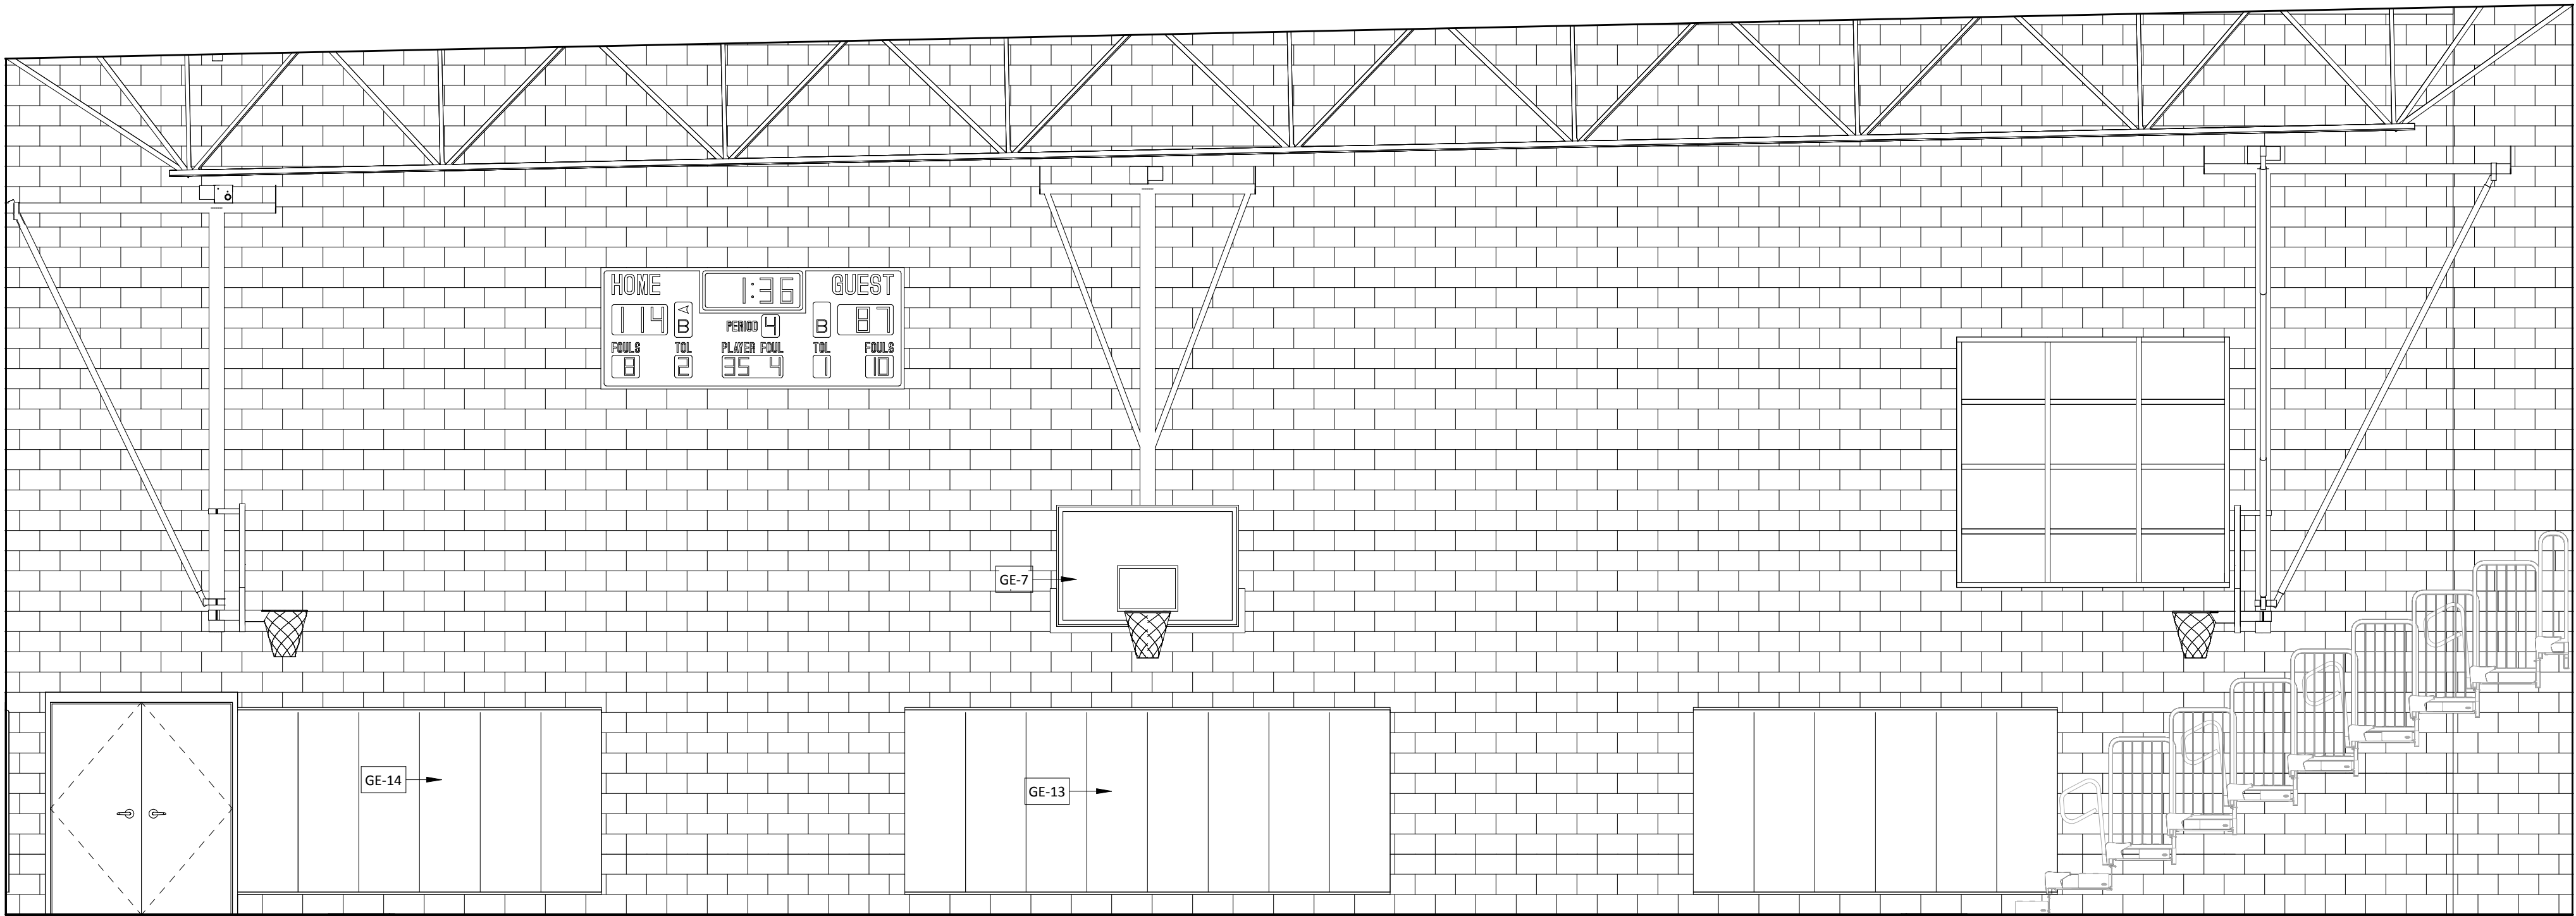

2 GYMNASIUM NORTH ELEVATION
A-2.1/A-9.5 1/4" = 1'-0"

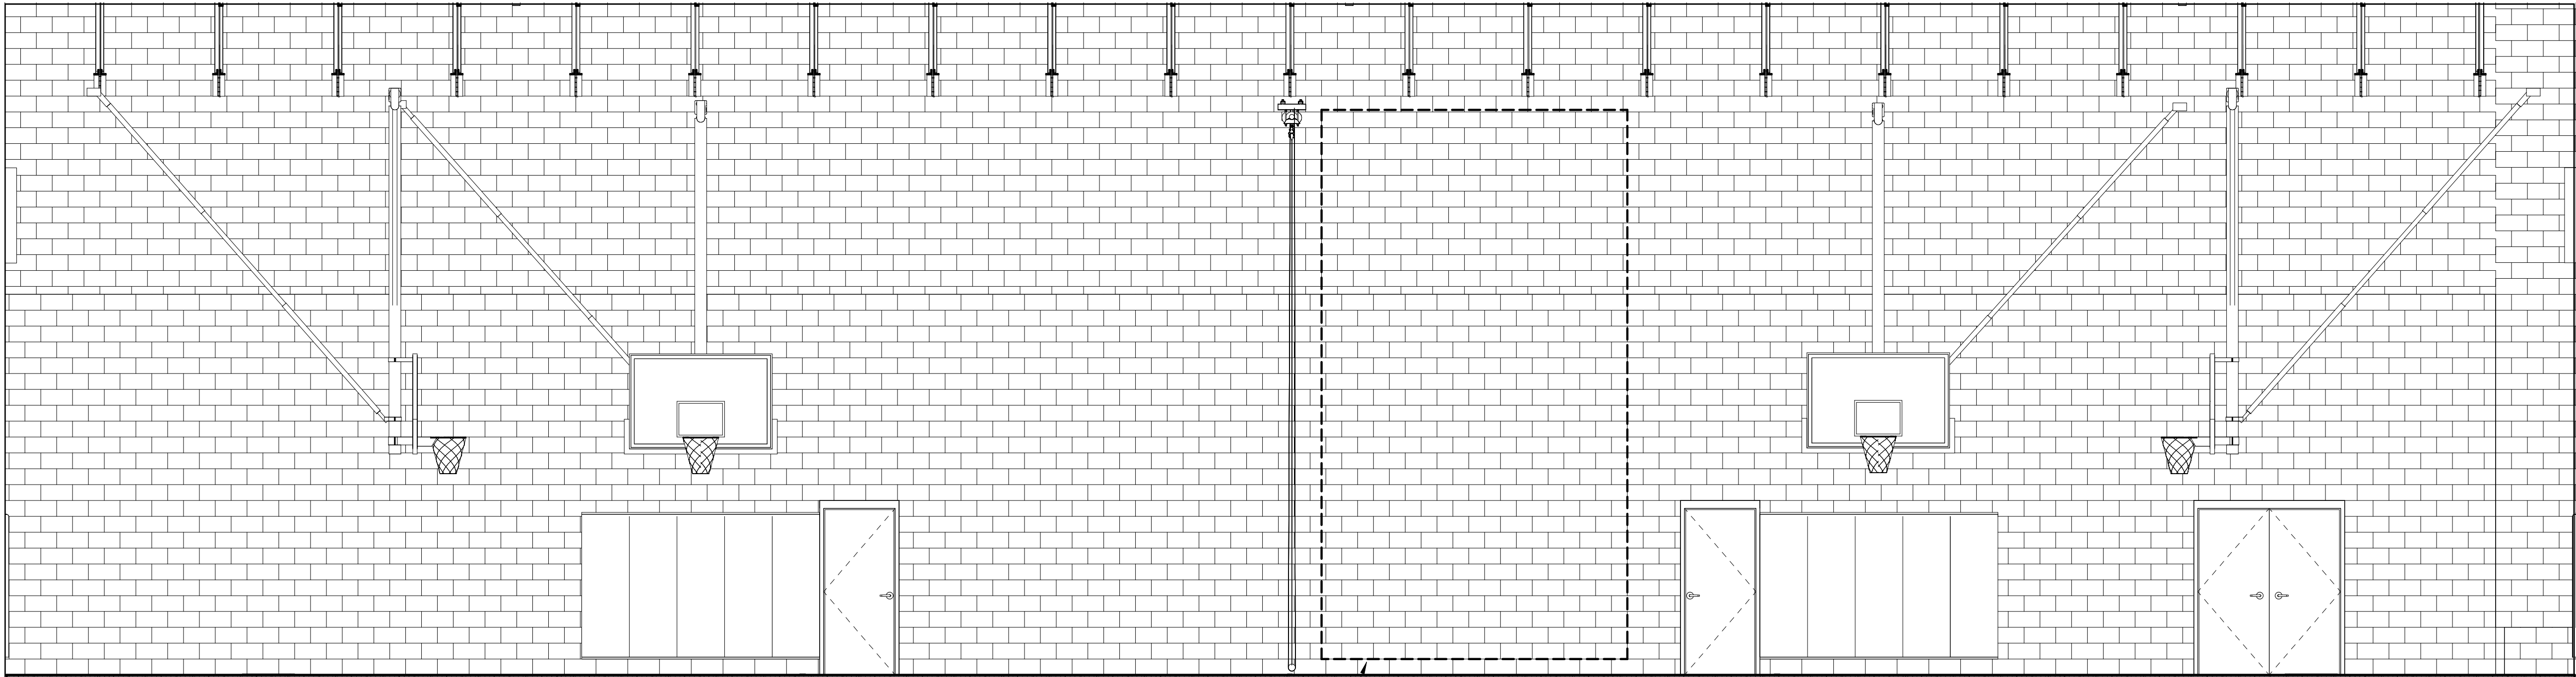

REINFORCED WALL CORES W/ EMBED PLATES
FOR FUTURE CLIMBING WALL

1 GYMNASIUM WEST ELEVATION
A-2.1/A-9.5 1/4" = 1'-0"

DESIGN DEVELOPMENT

Revised		
No.	Date	Description

NEWPORT
COMMUNITY CENTER


NEWPORT, NH

Proj. No: 18412 Drawn: SR
Date: 12/20/2018 Chk'd: JD


Gymnasium
Interior
Elevations

A-9.5


GYMNASIUM EQUIPMENT SCHEDULE				
Mark	Description	Length	Height	Comments
GE-1	Gym Divider	30' - 0"	12' - 0"	Multipurpose Room
GE-2	Gym Divider	80' - 0"	24' - 0"	
GE-3	Basketball Backstop			Rear Fold
GE-4	Basketball Backstop			Side Fold
GE-5	Basketball Backstop			Side Fold
GE-6	Basketball Backstop			Side Fold
GE-7	Basketball Backstop			Rear Fold
GE-10	Wall Mounted Electric Scoreboard			
GE-11	Wall Mounted Electric Scoreboard			
GE-12	Wall Pad	16' - 0"	6' - 0"	
GE-13	Wall Pad	16' - 0"	6' - 0"	
GE-14	Wall Pad	12' - 0"	6' - 0"	
GE-15	Wall Pad	12' - 0"	6' - 0"	
GE-24	Wall Pad	10' - 0"	6' - 0"	
GE-26	Wall Pad	10' - 0"	6' - 0"	
GE-28	MAXAM Telescopic Gym Bleacher Bank - Wall Attached			North End Section
GE-29	MAXAM Telescopic Gym Bleacher Aisle - Wall Attached			North Stair Section
GE-30	MAXAM Telescopic Gym Bleacher Bank - Wall Attached			North Center Section
GE-31	MAXAM Telescopic Gym Bleacher Bank - Wall Attached			South Center Section
GE-32	MAXAM Telescopic Gym Bleacher Aisle - Wall Attached			South Stair Section
GE-33	MAXAM Telescopic Gym Bleacher Bank - Wall Attached			South End Section

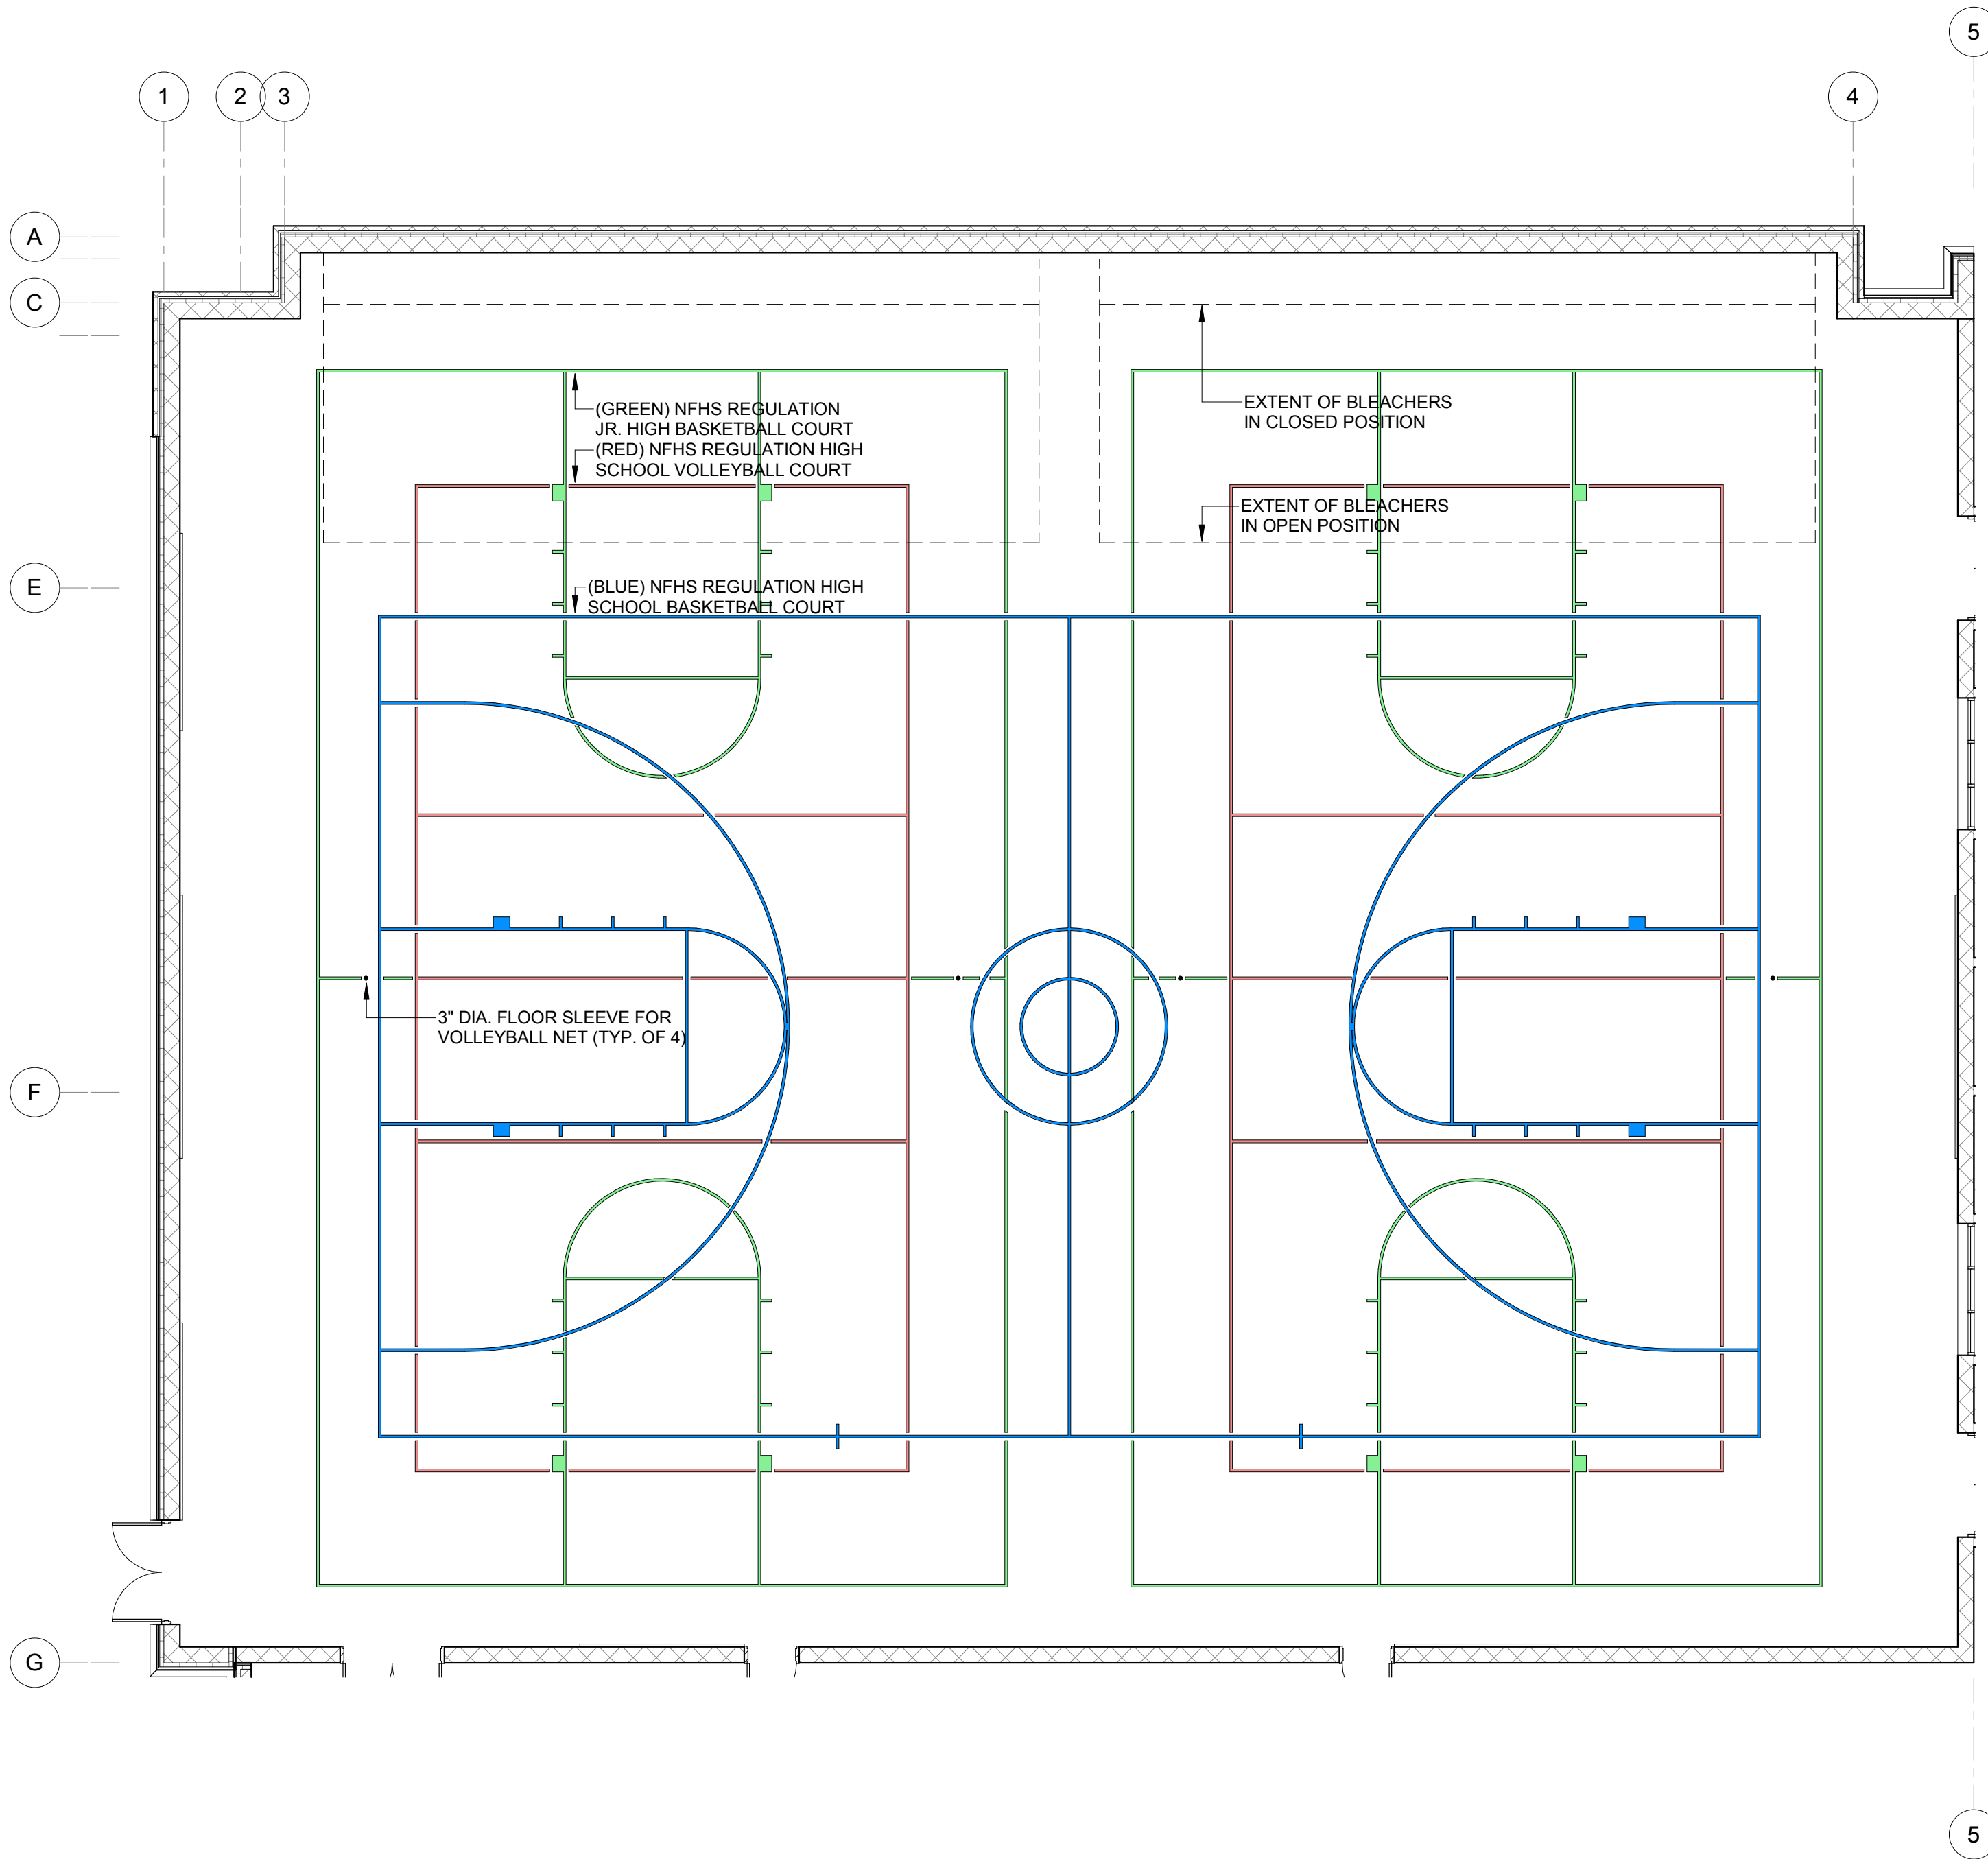

1 GYM FLOOR STRIPING PLAN
A-9.1A-9.6 1/8" = 1'-0"

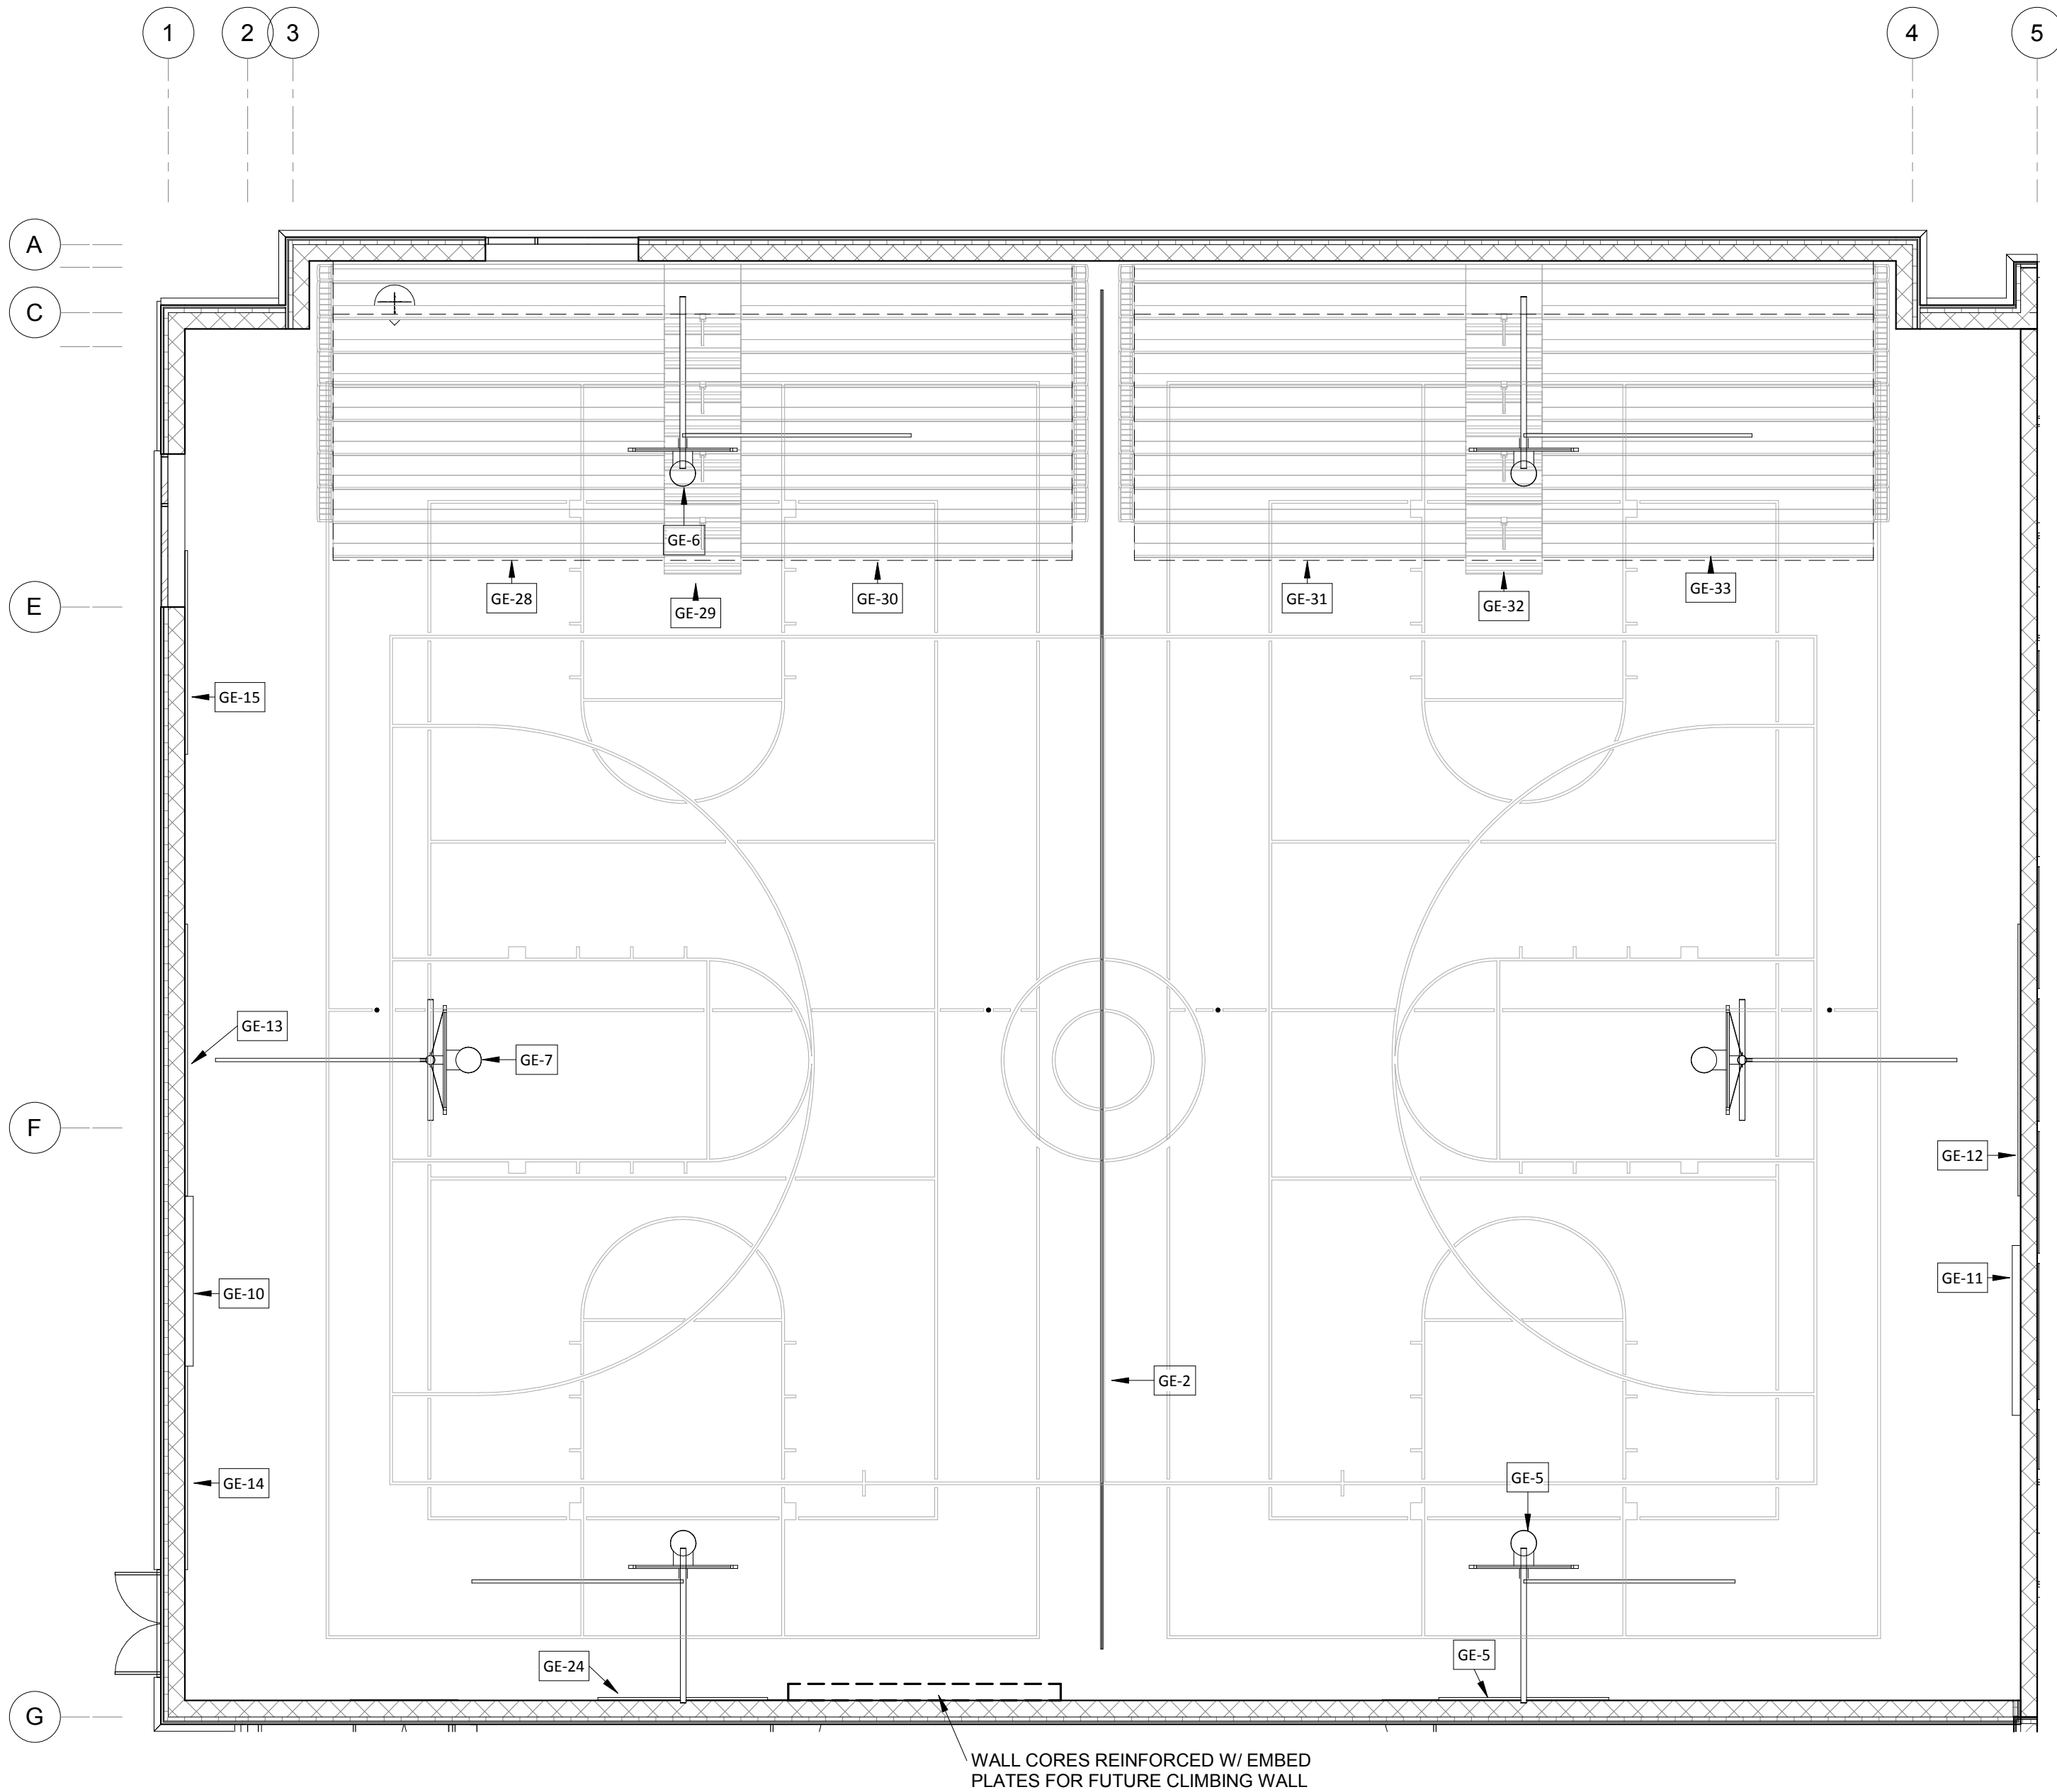

2 GYM EQUIPMENT PLAN
A-9.1A-9.6 1/8" = 1'-0"

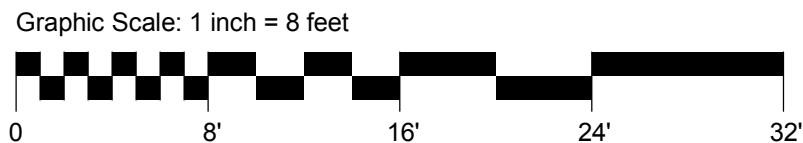

DESIGN DEVELOPMENT

NEWPORT
COMMUNITY CENTER

NEWPORT, NH

Proj. No: 18412 Drawn: SR
Date: 12/20/2018 Chk'd: JD

Gym Floor
Layout Plan

A-9.6

Revised		
No.	Date	Description


NEWPORT
COMMUNITY CENTER

NEWPORT, NH


Proj. No: 18412 Drawn: SR
Date: 12/20/2018 Chk'd: JD

Lobby Interior
Elevations

A-9.7

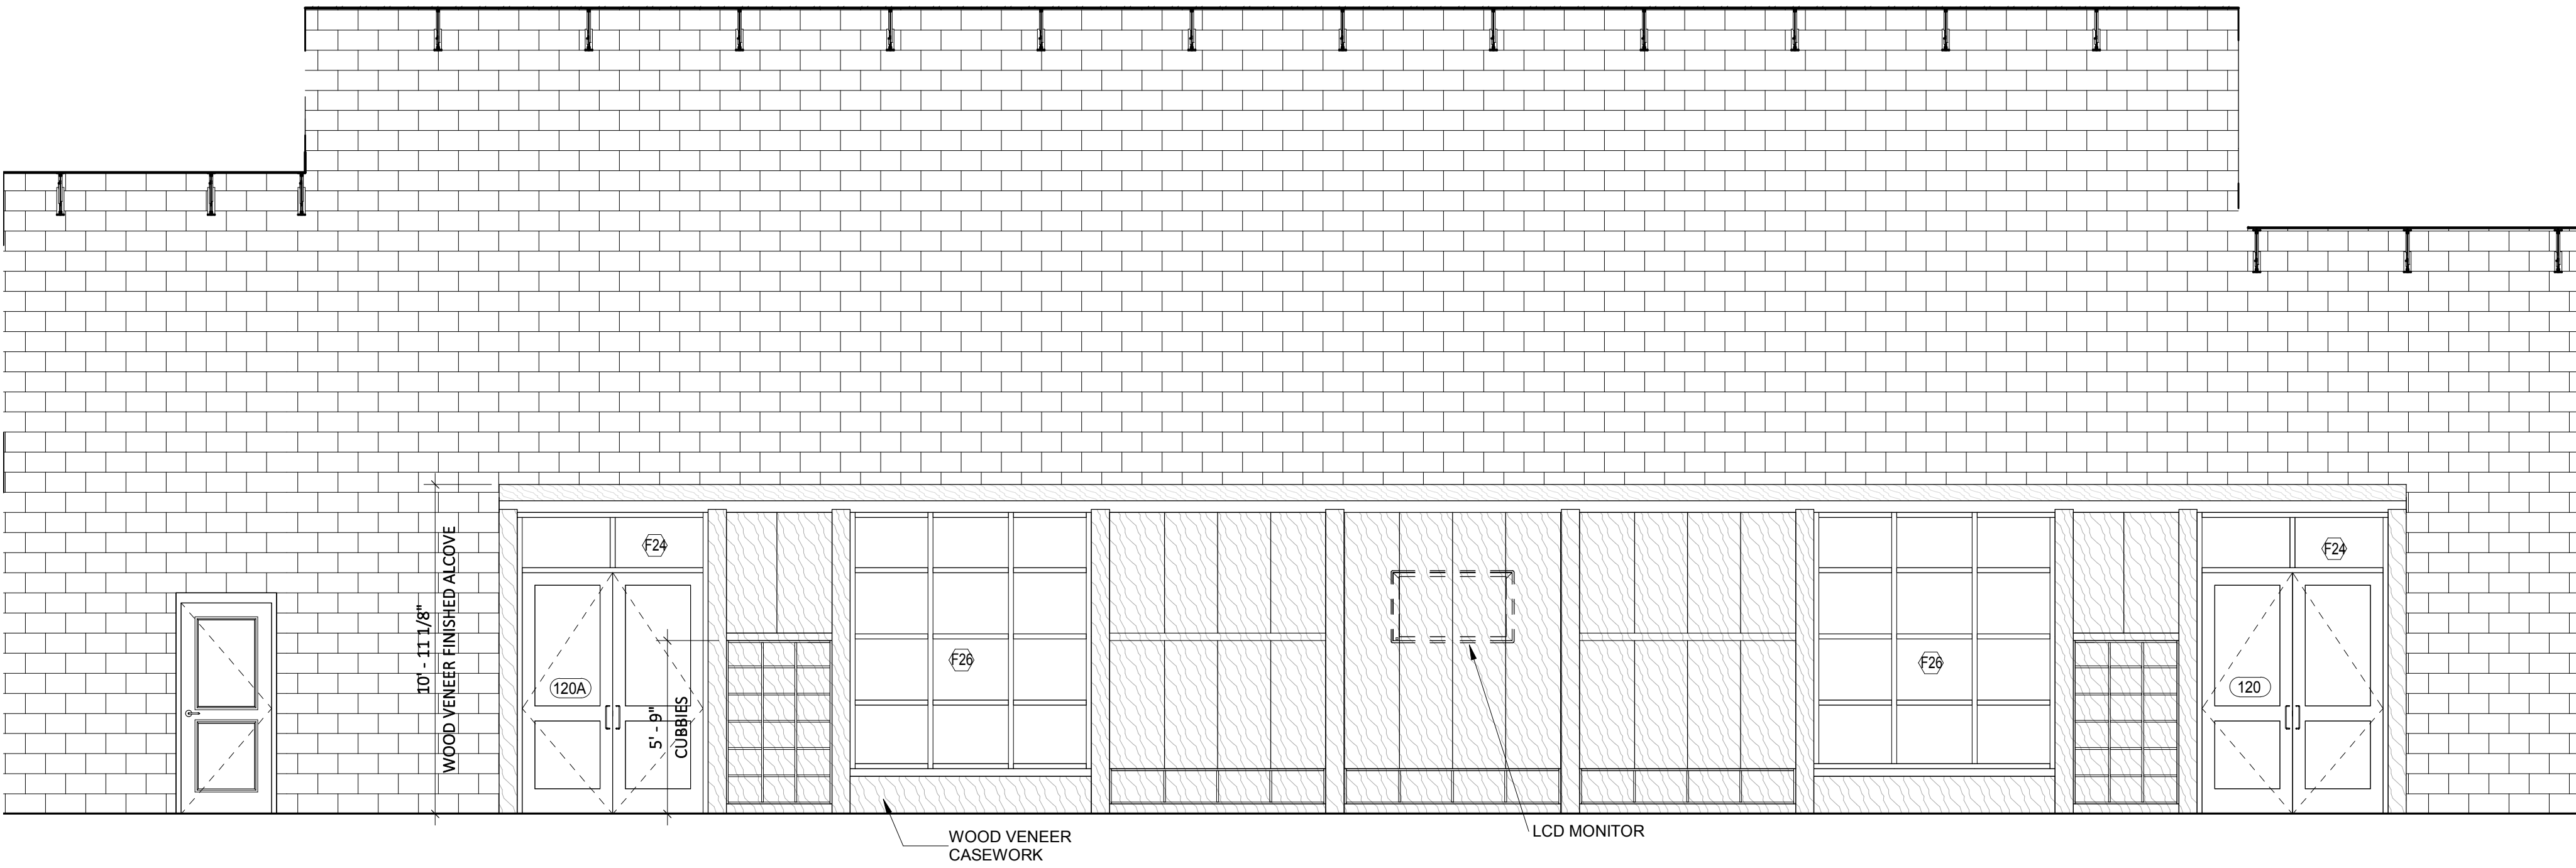


4 LOBBY NORTH ELEVATION
A-2.1(A&Z) 1/4" = 1'-0"

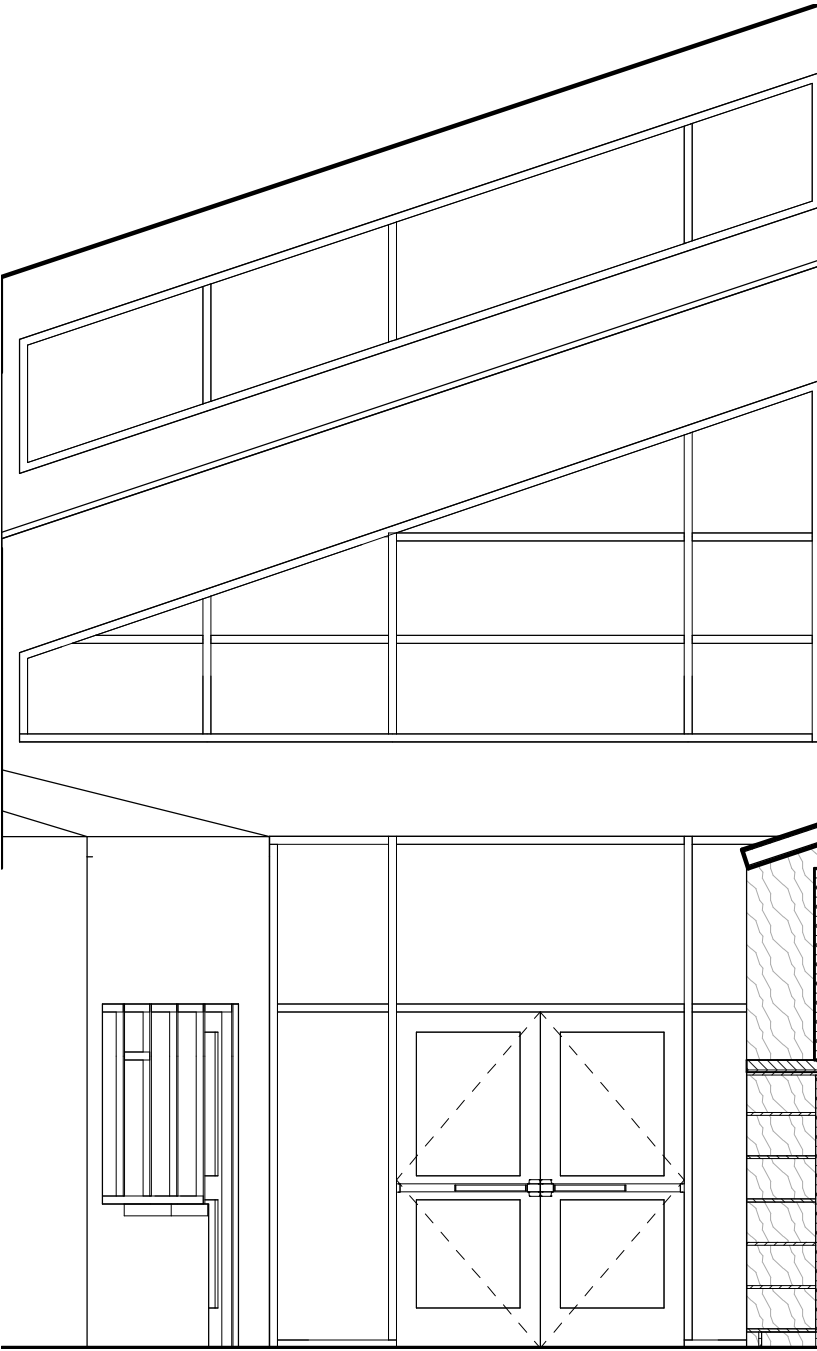

3 LOBBY WEST ELEVATION
A-2.1(A&Z) 1/4" = 1'-0"




2 LOBBY SOUTH ELEVATION
A-2.1(A&Z) 1/4" = 1'-0"

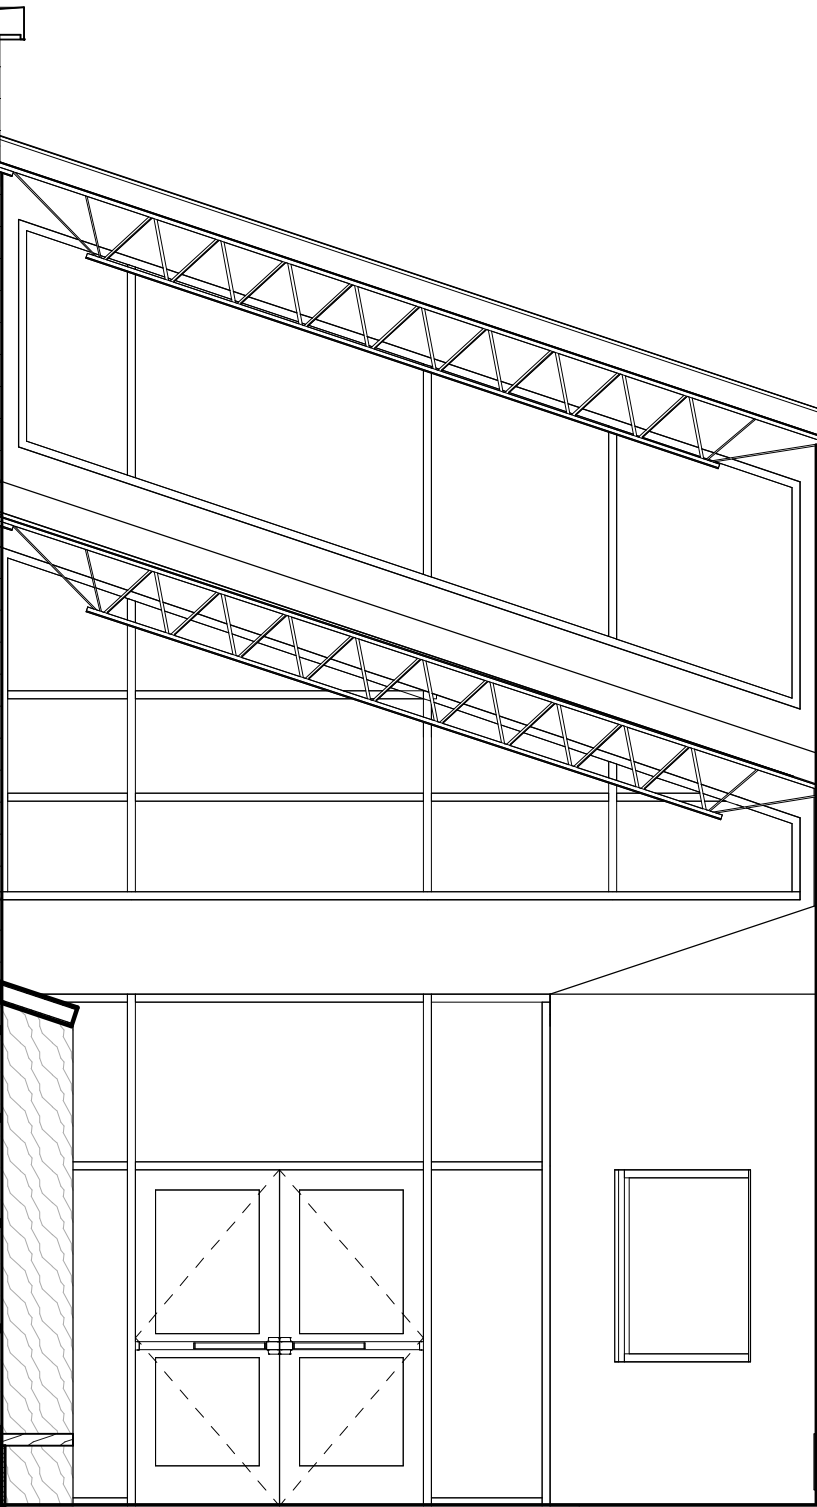


1 LOBBY EAST ELEVATION
A-2.1(A&Z) 1/4" = 1'-0"


DESIGN DEVELOPMENT

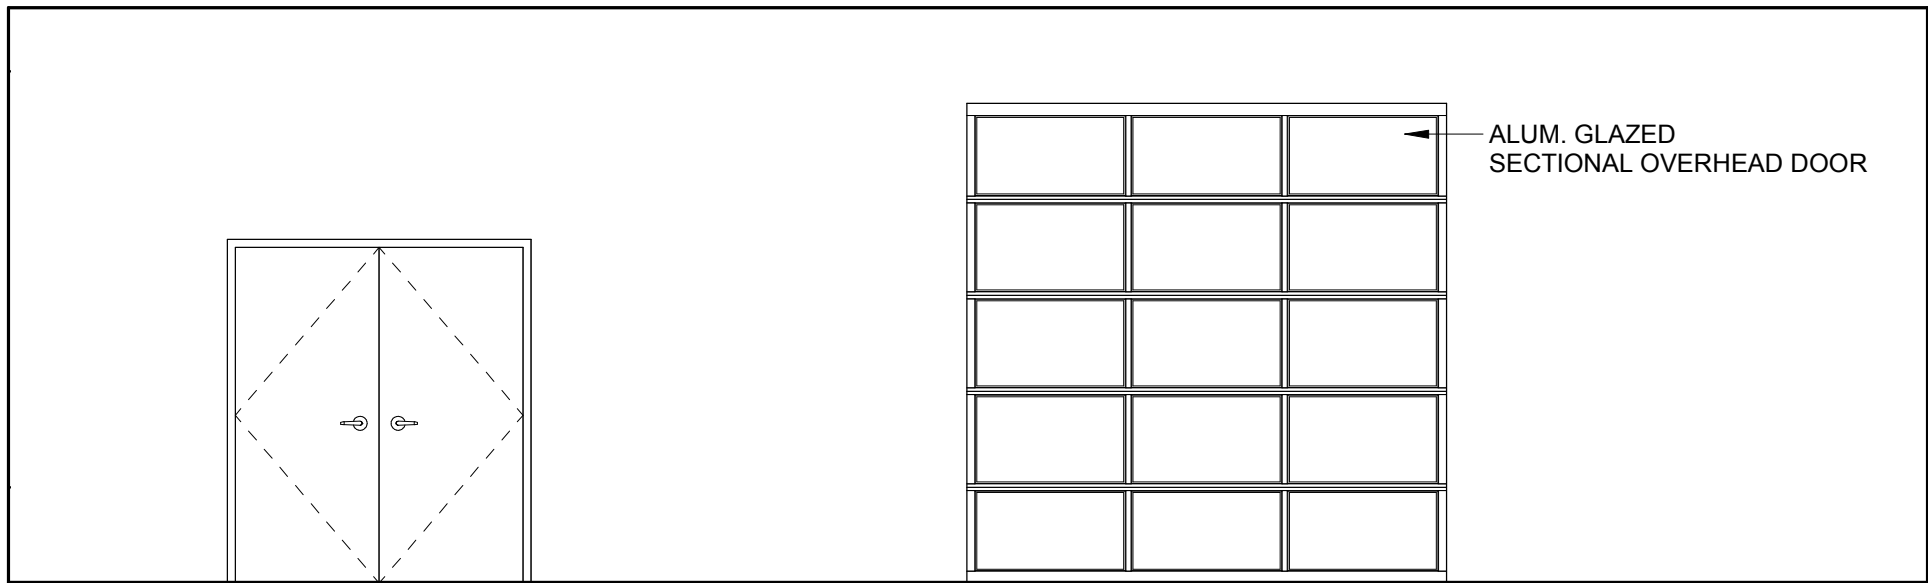


4 MULTI-PURPOSE AB NORTH ELEVATION
A-2.1/A-9.8 1/4" = 1'-0"

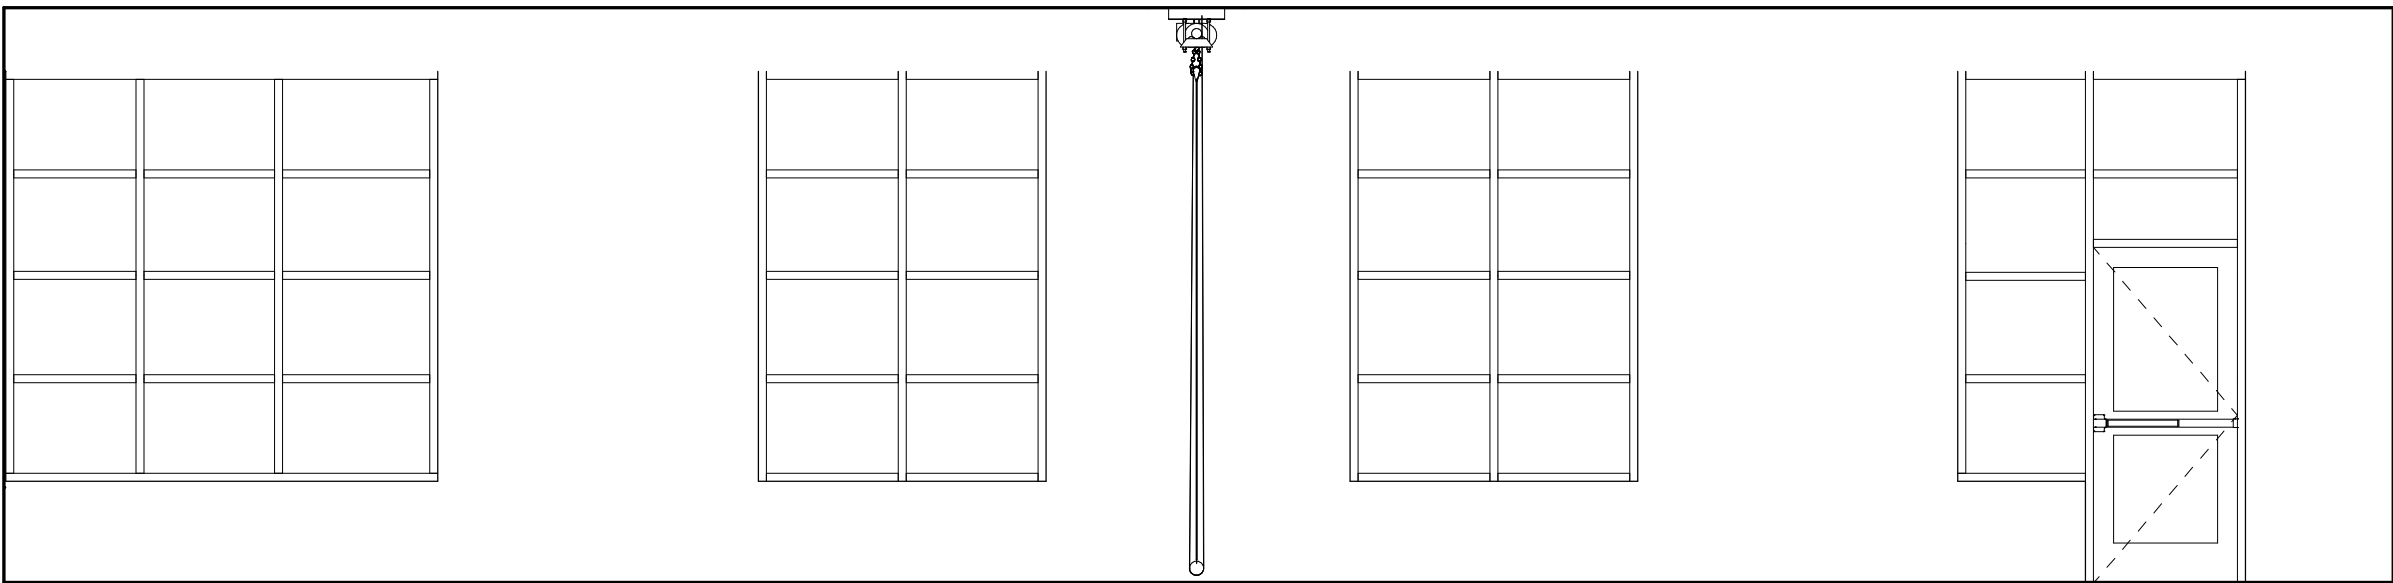

3 MULTI-PURPOSE AB WEST ELEVATION
A-2.1/A-9.8 1/4" = 1'-0"

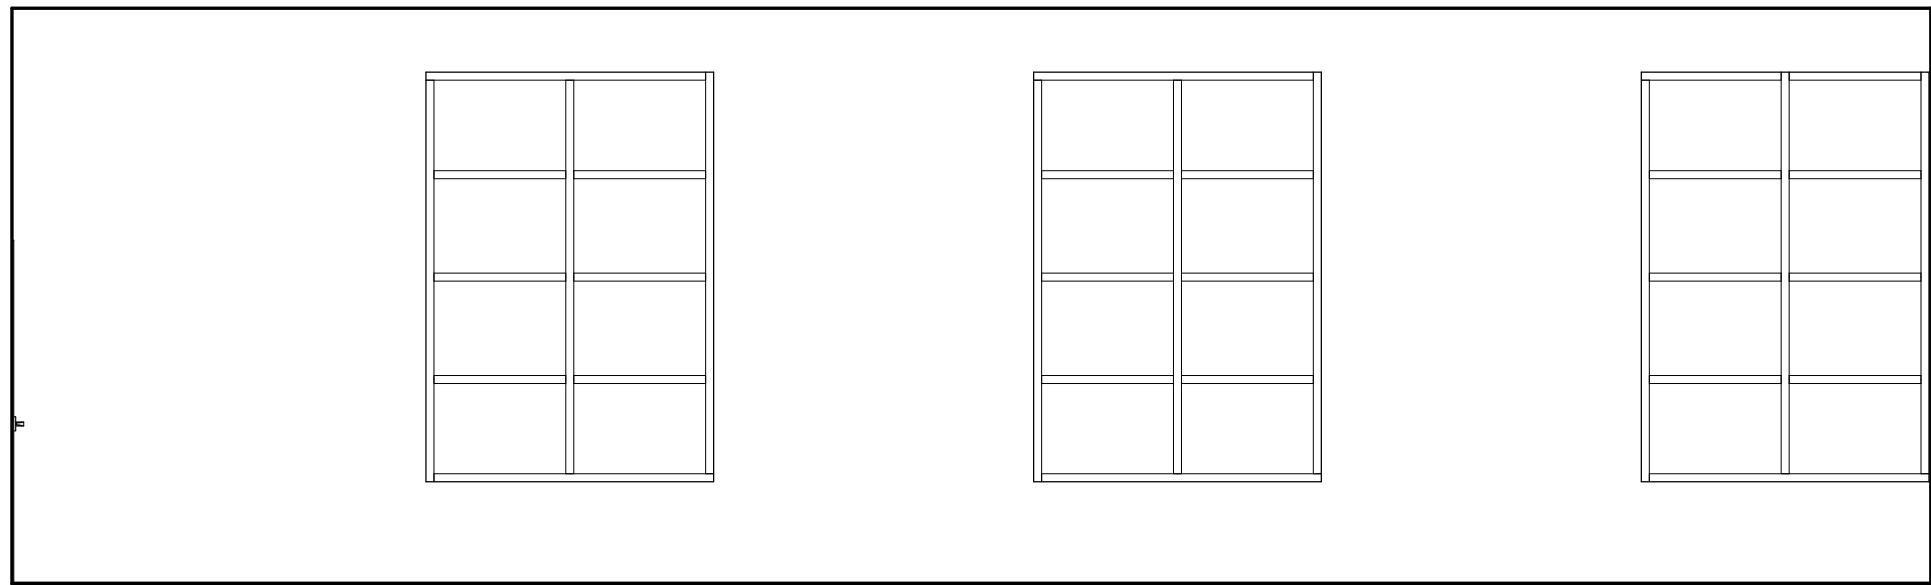

2 MULTI-PURPOSE AB SOUTH ELEVATION
A-2.1/A-9.8 1/4" = 1'-0"

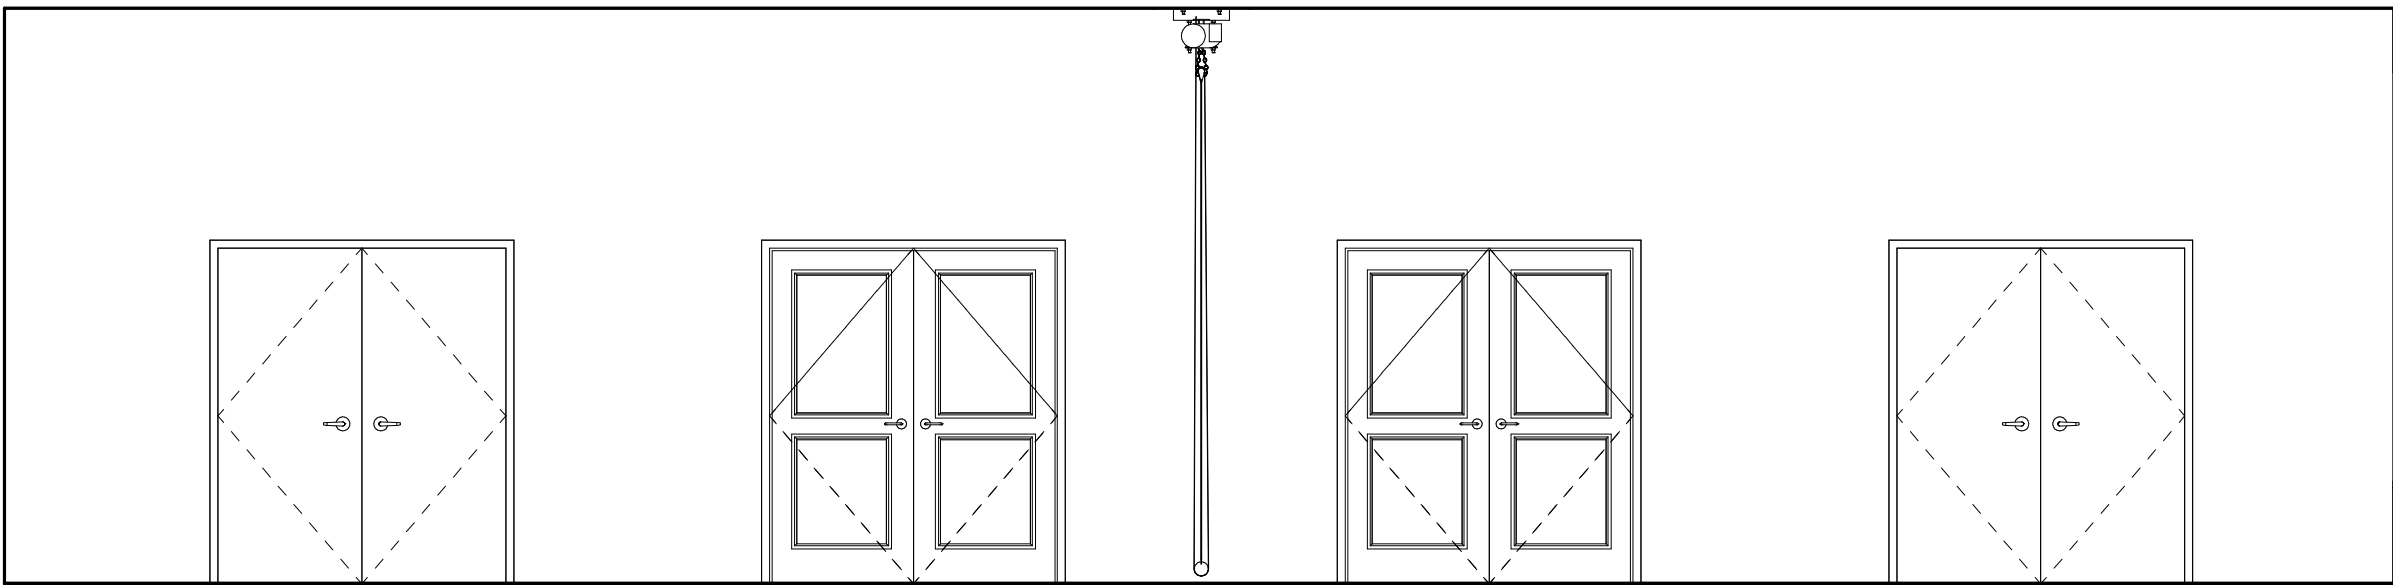

1 MULTI-PURPOSE AB EAST ELEVATION
A-2.1/A-9.8 1/4" = 1'-0"

DESIGN DEVELOPMENT

Revised		
No.	Date	Description

NEWPORT
COMMUNITY CENTER

NEWPORT, NH

Proj. No: 18412 Drawn: SR
Date: 12/20/2018 Chk'd: JD

Multi - Purpose
AB Interior
Elevations

A-9.8